



Fire Alarm Pull


Fire Extinguisher


Evacuation Route


Shelter Areas
(Severe Storms)

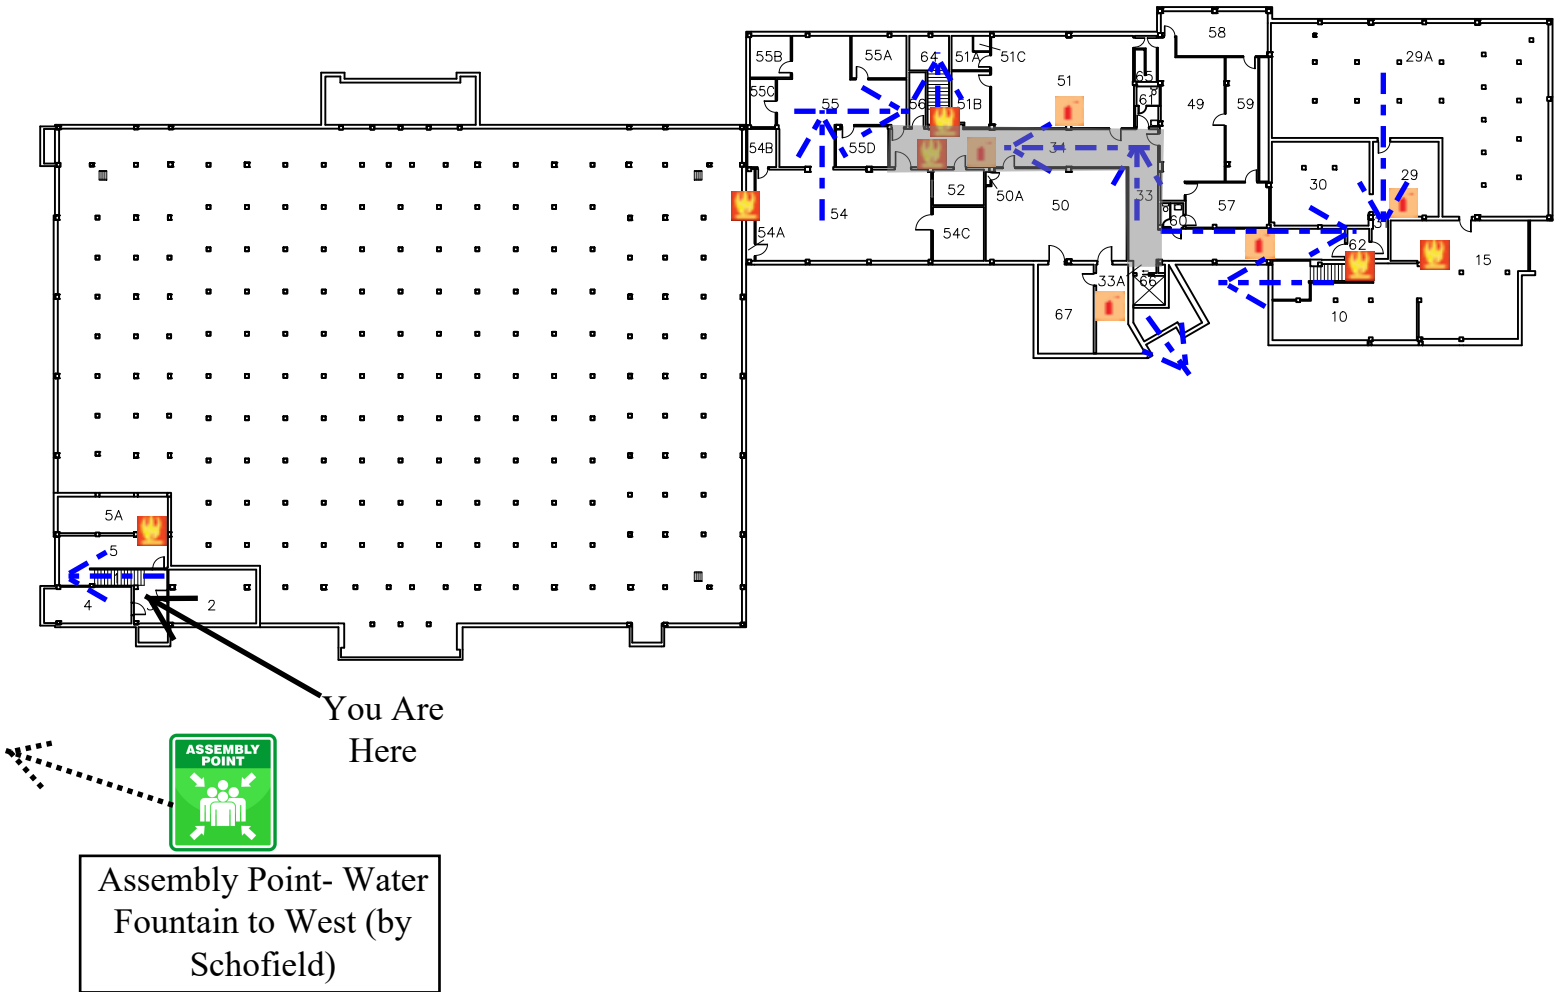

University of Wisconsin-Eau Claire

Facilities Planning

Brewer, Campus School, Kjer, Zorn
Basement Plan

DATE:


Oct 2021

DWG NO:

1



 Fire Alarm Pull
 Fire Extinguisher
 Evacuation Route
 Shelter Areas
 (Severe Storms)

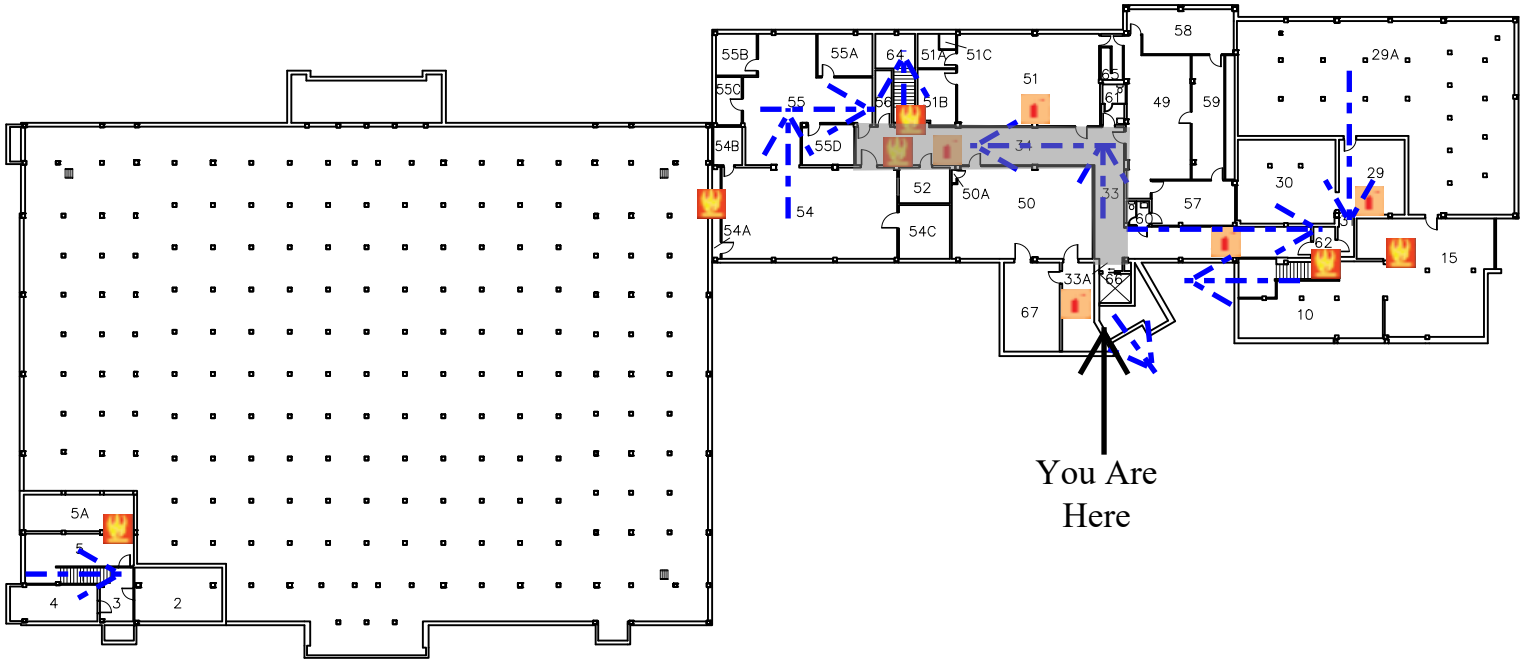

You Are
Here



Assembly Point- Water
Fountain to West (by
Schofield)



University of Wisconsin-Eau Claire

Facilities Planning

Brewer, Campus School, Kjer, Zorn
Basement Plan

DATE:
Oct 2021
DWG NO:
2





Fire Alarm Pull


Fire Extinguisher


Evacuation Route


Shelter Areas
(Severe Storms)

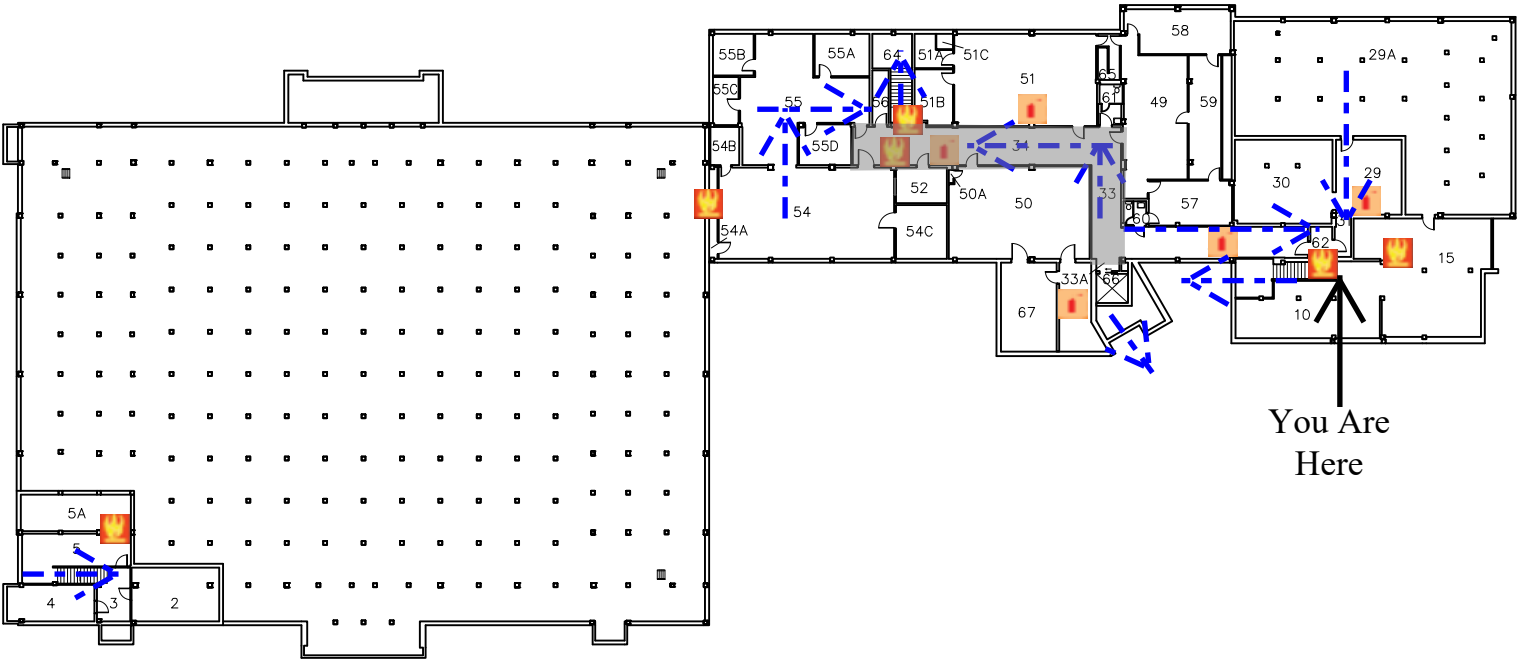




Assembly Point- Water Fountain to West (by Schofield)





 Fire Alarm Pull
 Fire Extinguisher
 Evacuation Route
 Shelter Areas
 (Severe Storms)

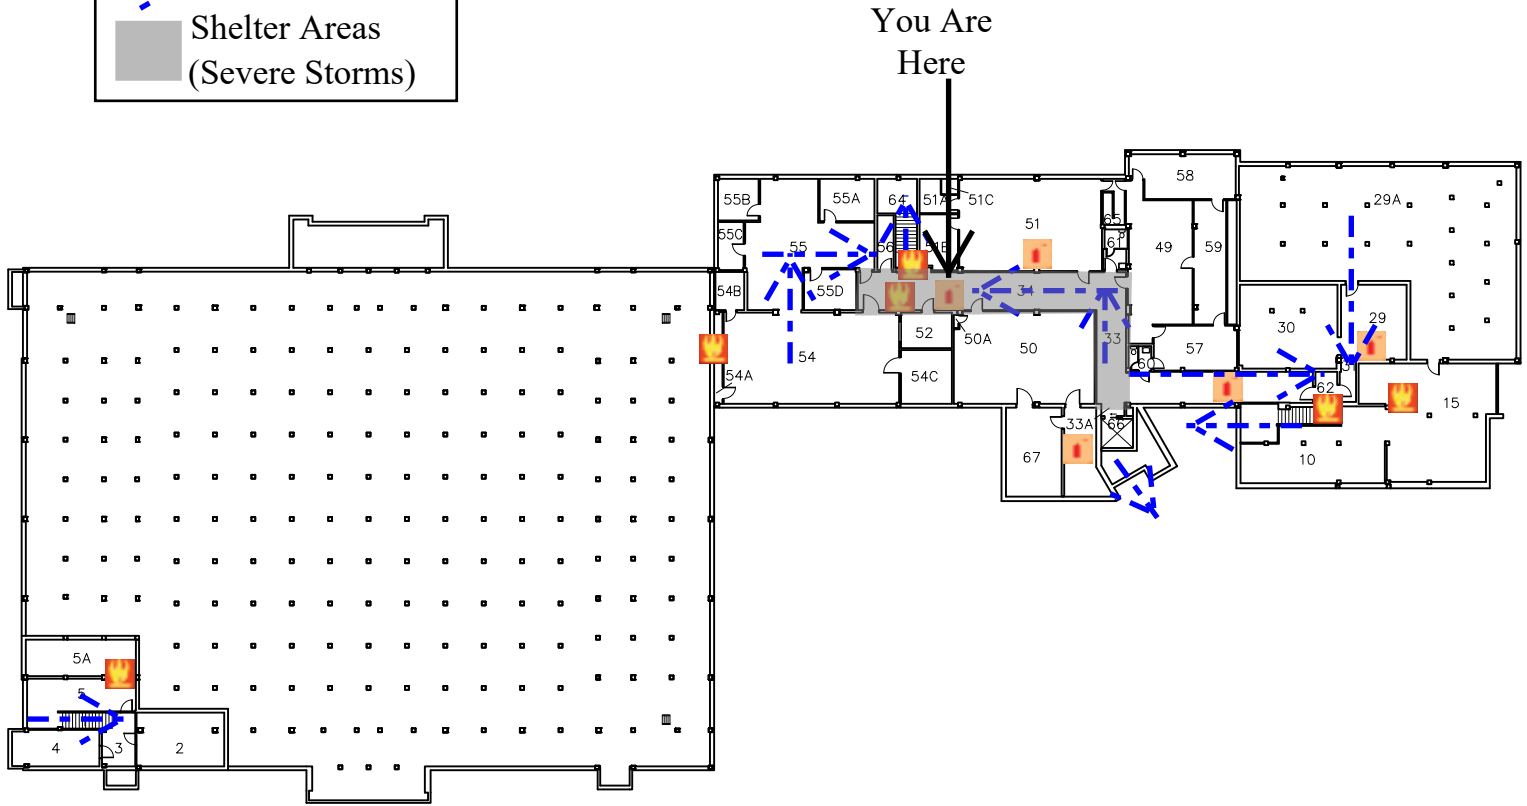



Assembly Point- Water Fountain to West (by Schofield)





 Fire Alarm Pull
 Fire Extinguisher
 AED
 Evacuation Route

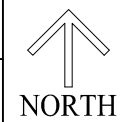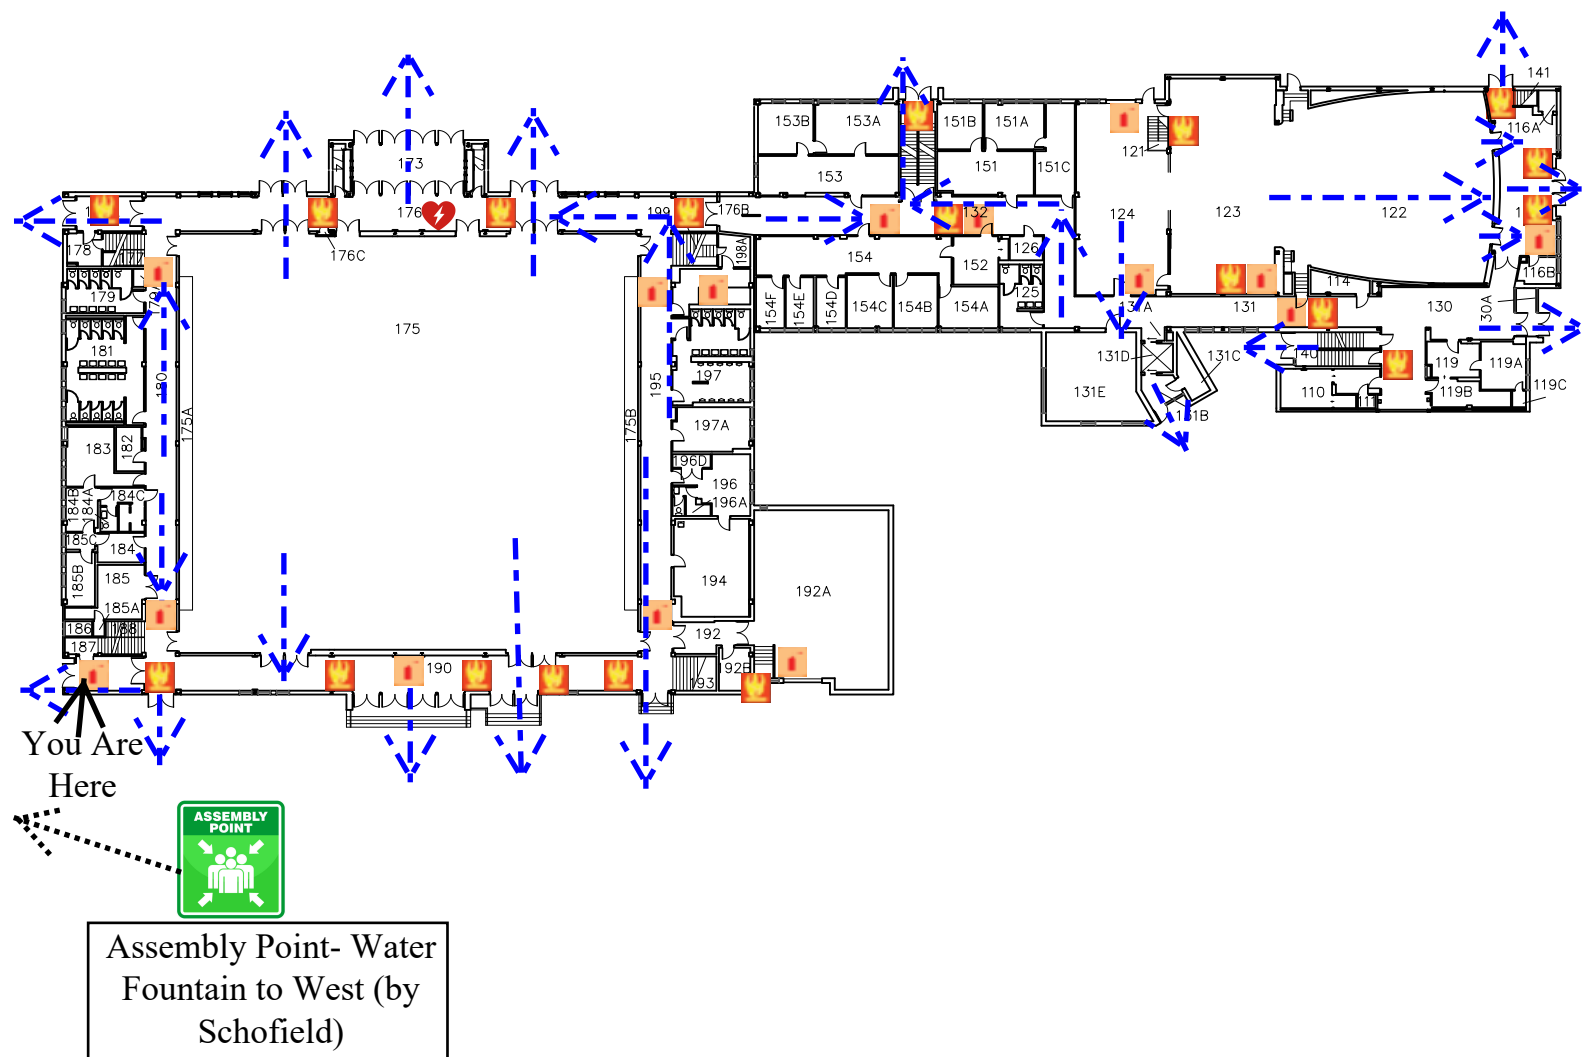



 Fire Alarm Pull
 Fire Extinguisher
 AED
 Evacuation Route

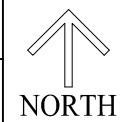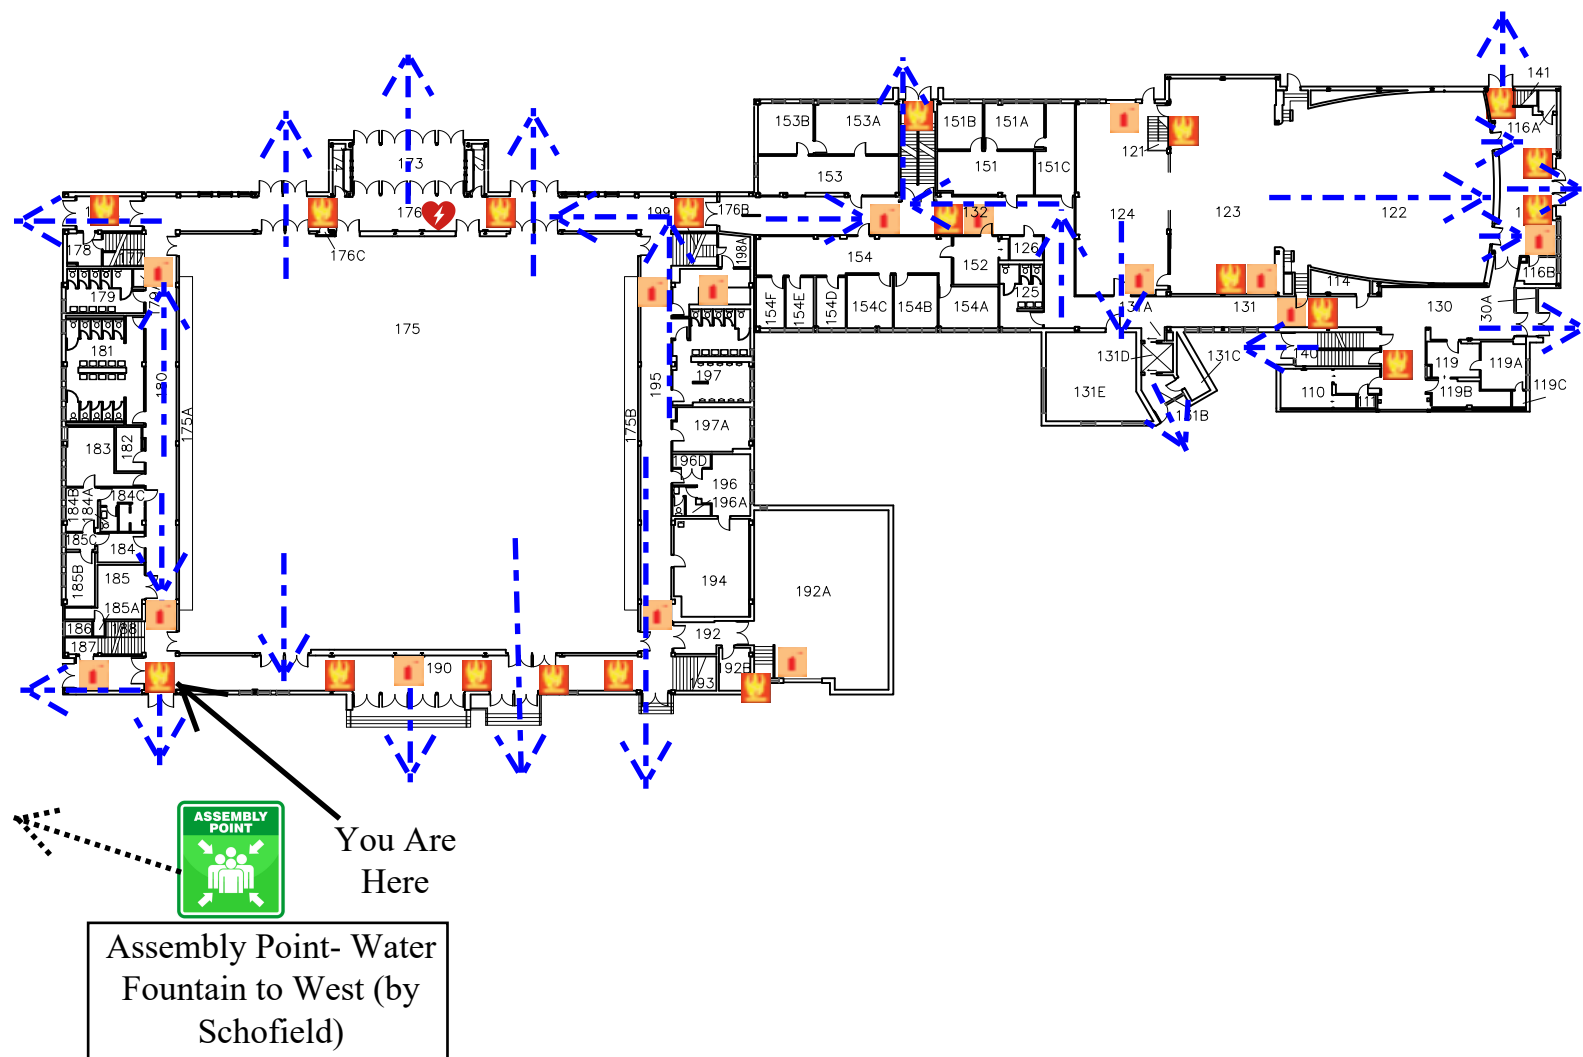


 Fire Alarm Pull
 Fire Extinguisher
 AED
 Evacuation Route

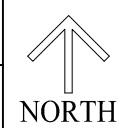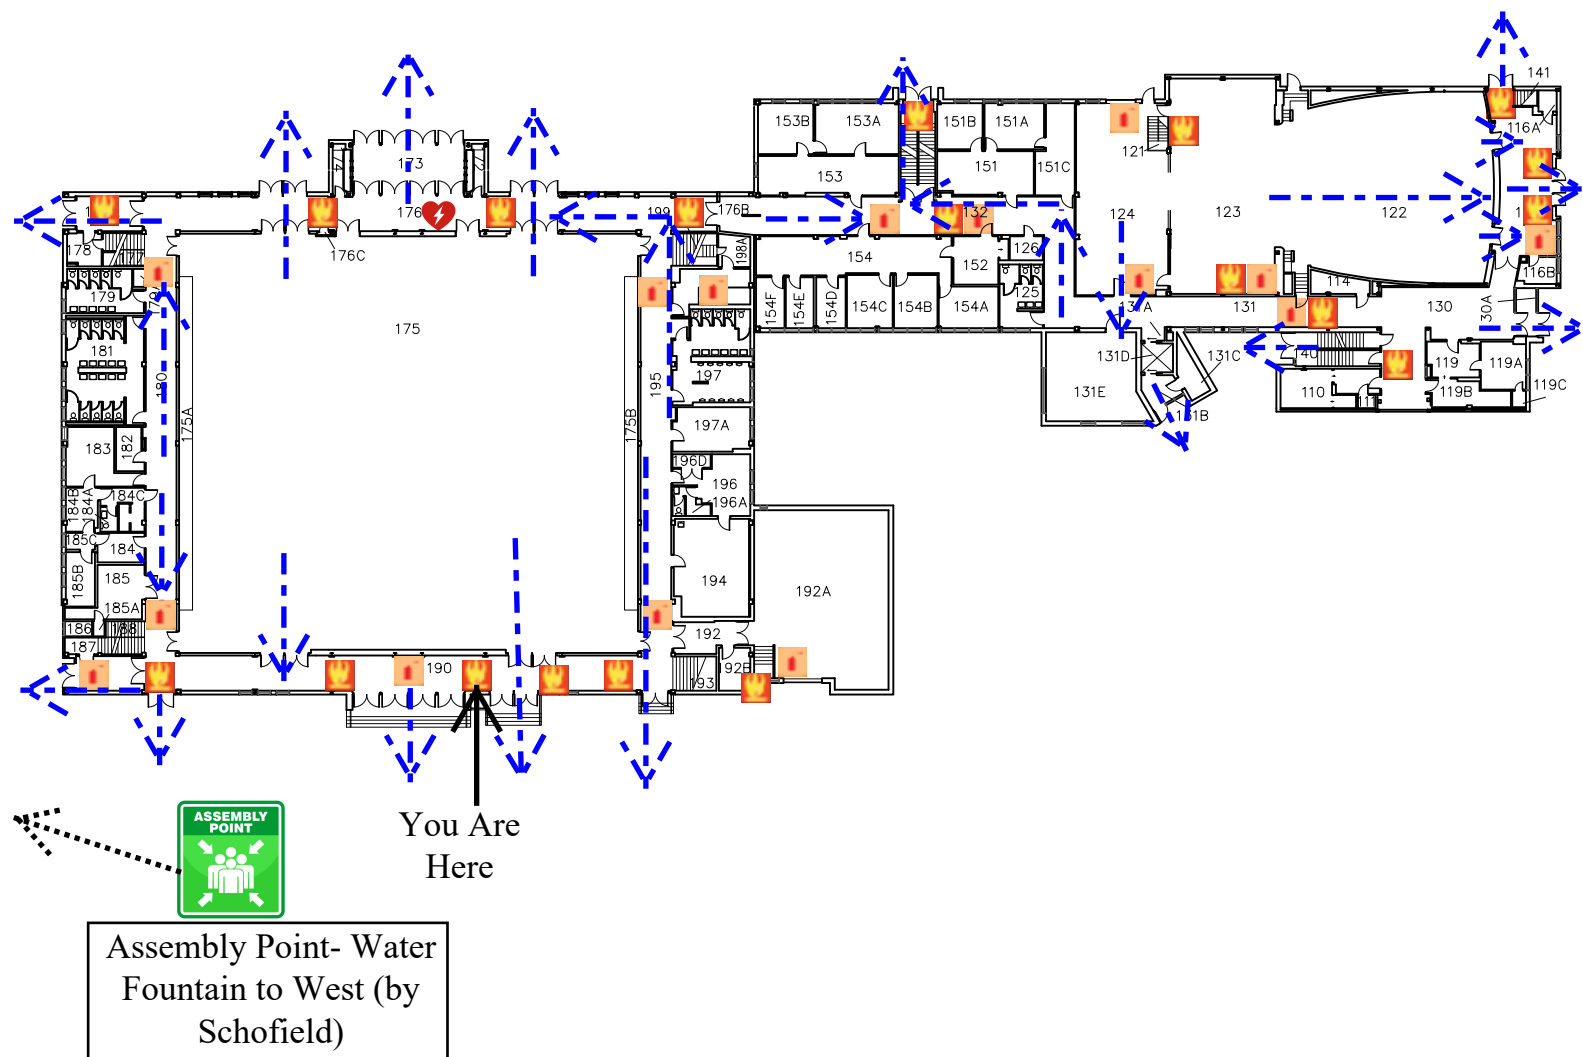

 

 Fire Alarm Pull
 Fire Extinguisher
 AED
 Evacuation Route

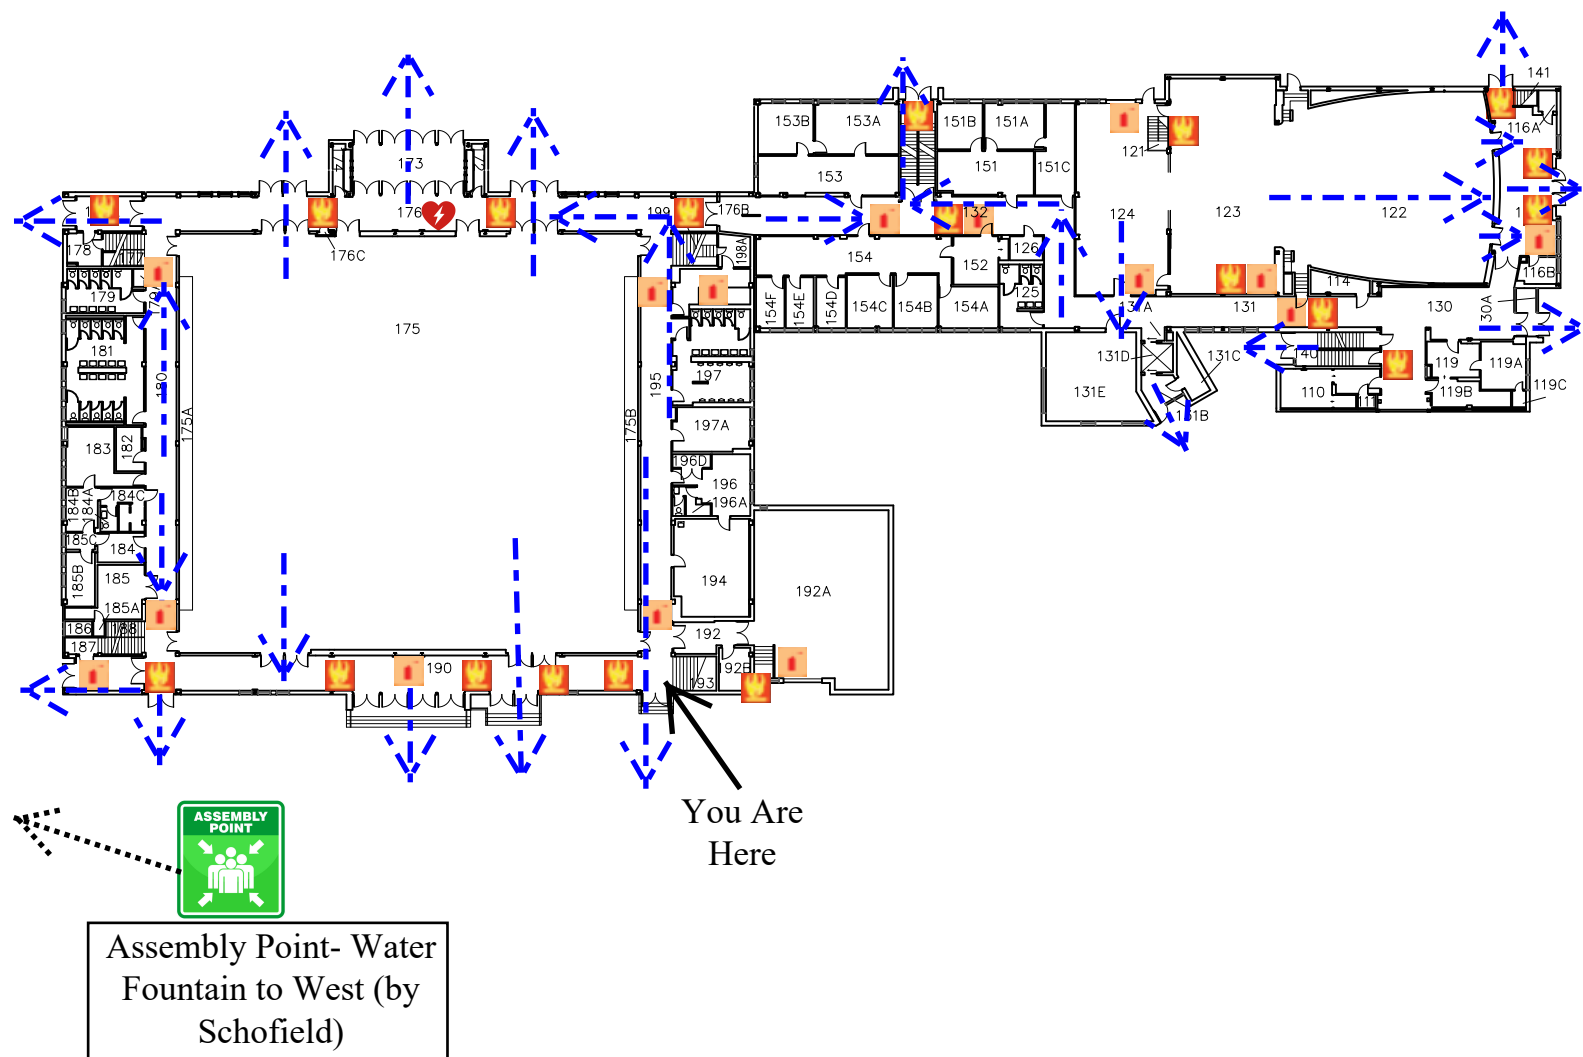


 Fire Alarm Pull
 Fire Extinguisher
 AED
 Evacuation Route

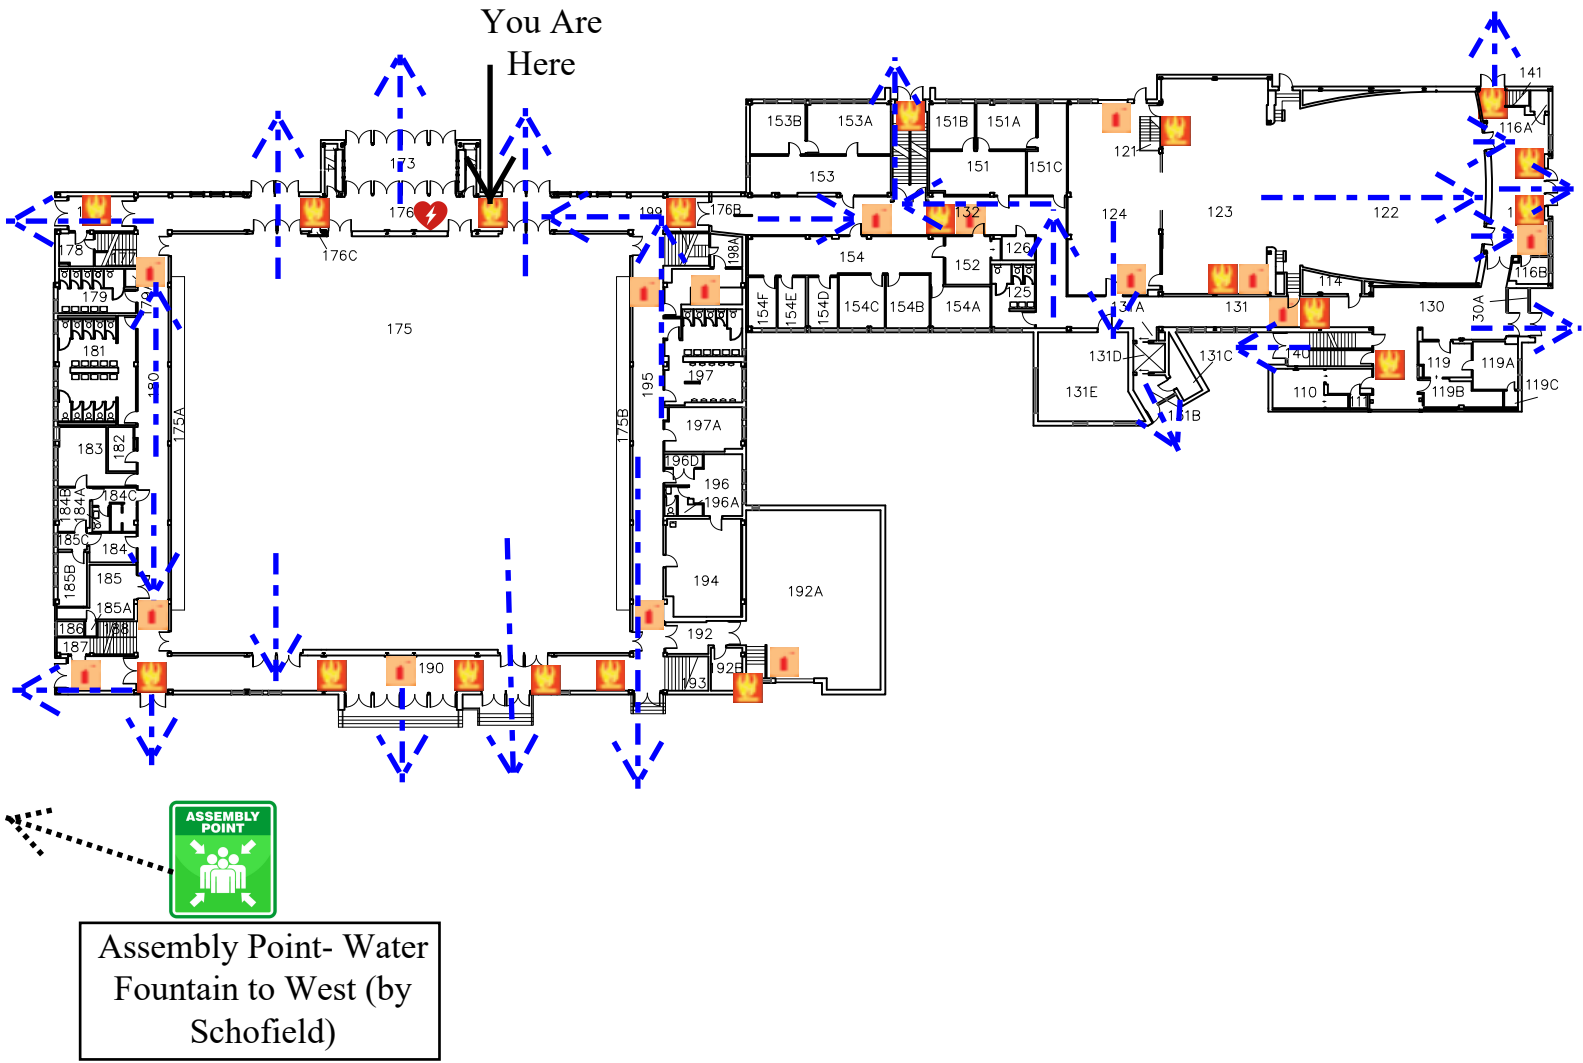


 Fire Alarm Pull
 Fire Extinguisher
 AED
 Evacuation Route

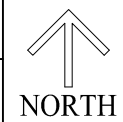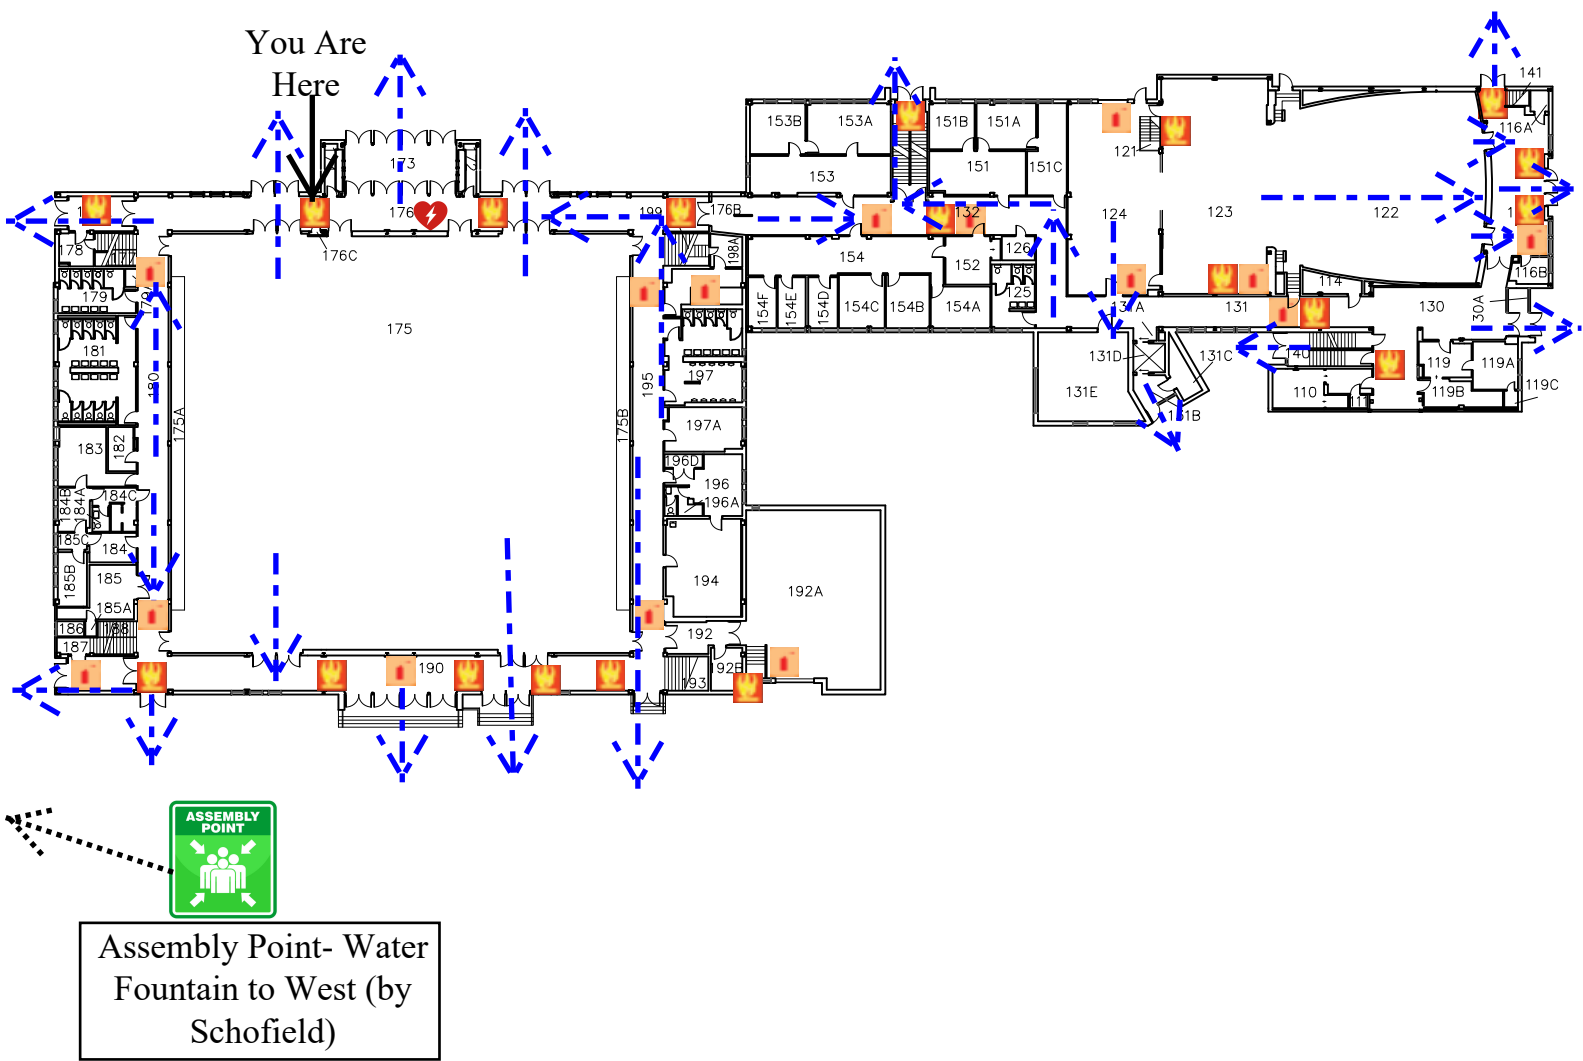

 Fire Alarm Pull
 Fire Extinguisher
 AED
 Evacuation Route

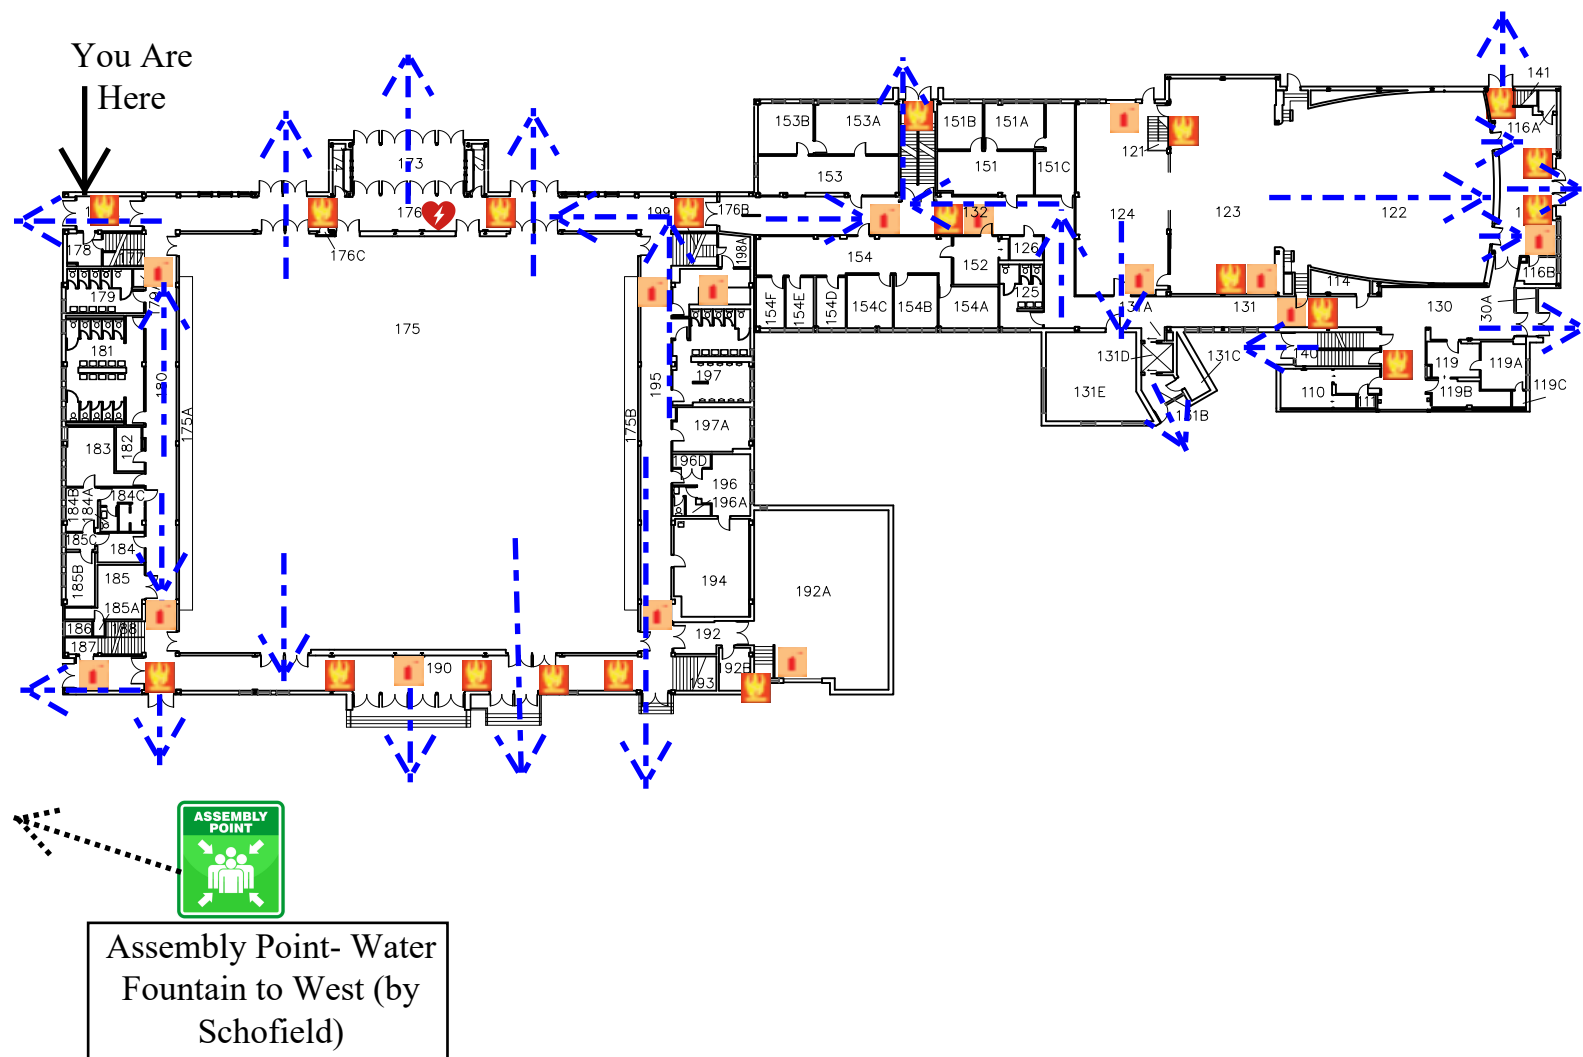

 Fire Alarm Pull
 Fire Extinguisher
 AED
 Evacuation Route

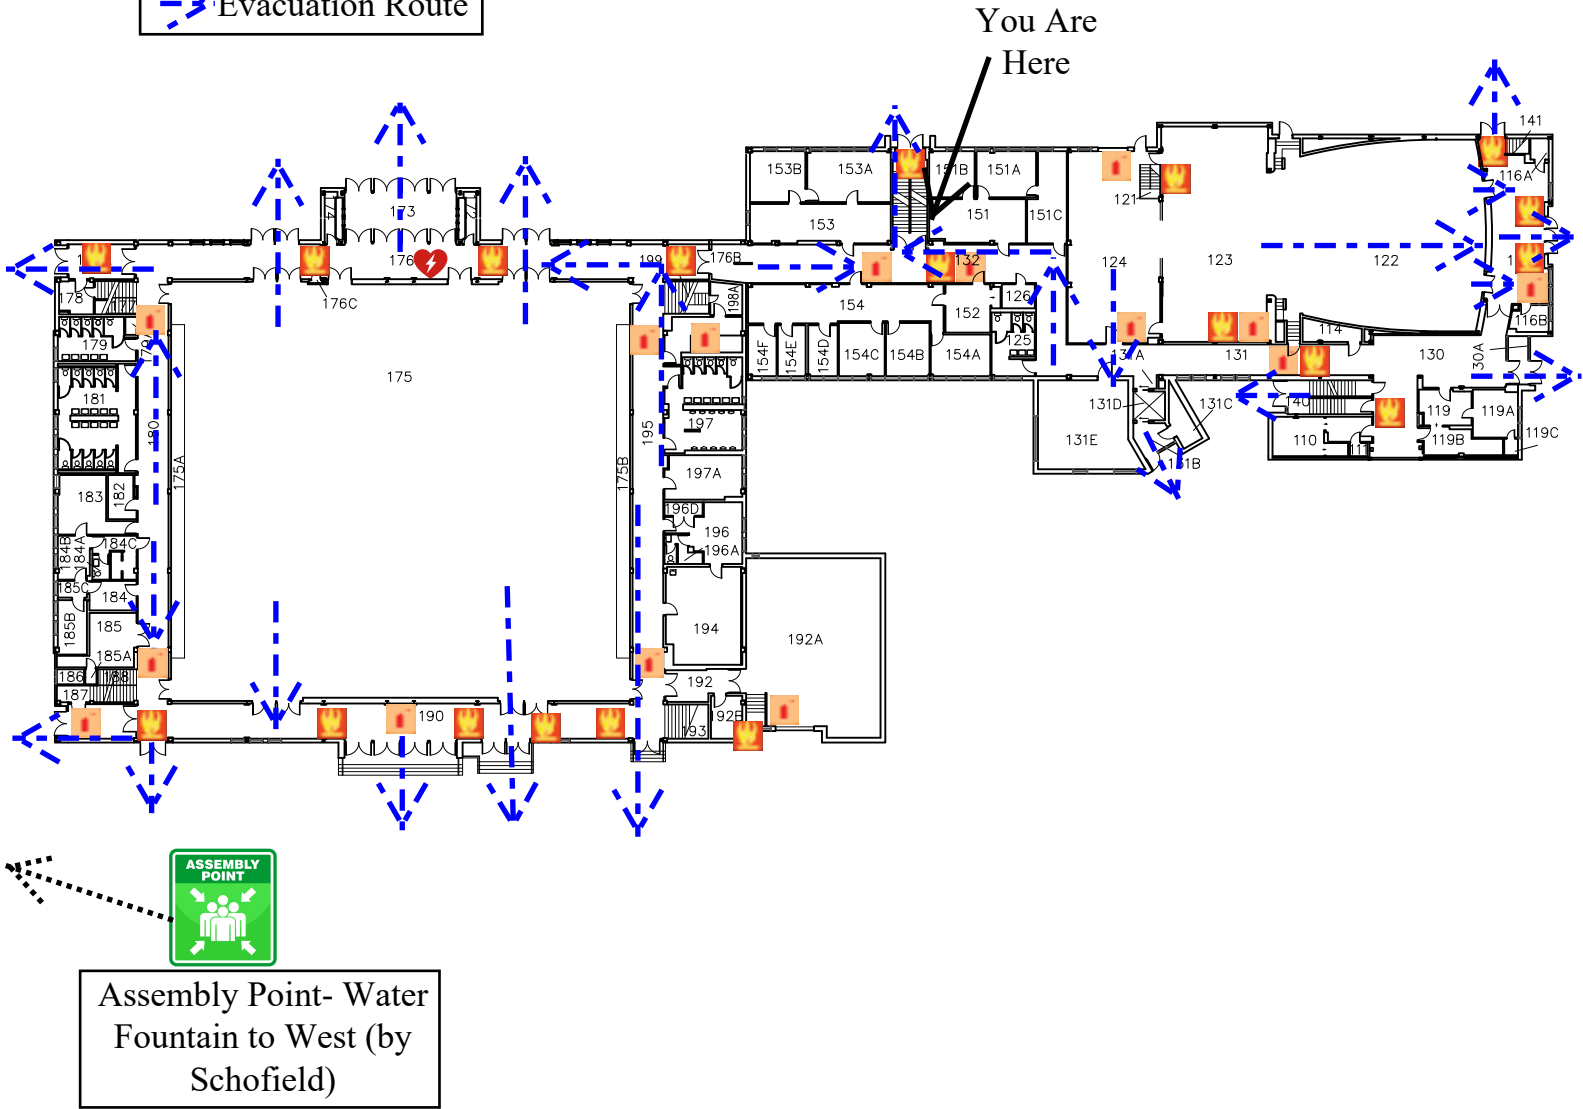

University of Wisconsin-Eau Claire

Facilities Planning

Brewer, Campus School, Kjer, Zorn
First Floor Plan

DATE:


Oct 2021

DWG NO:

8



 Fire Alarm Pull
 Fire Extinguisher
 AED
 Evacuation Route

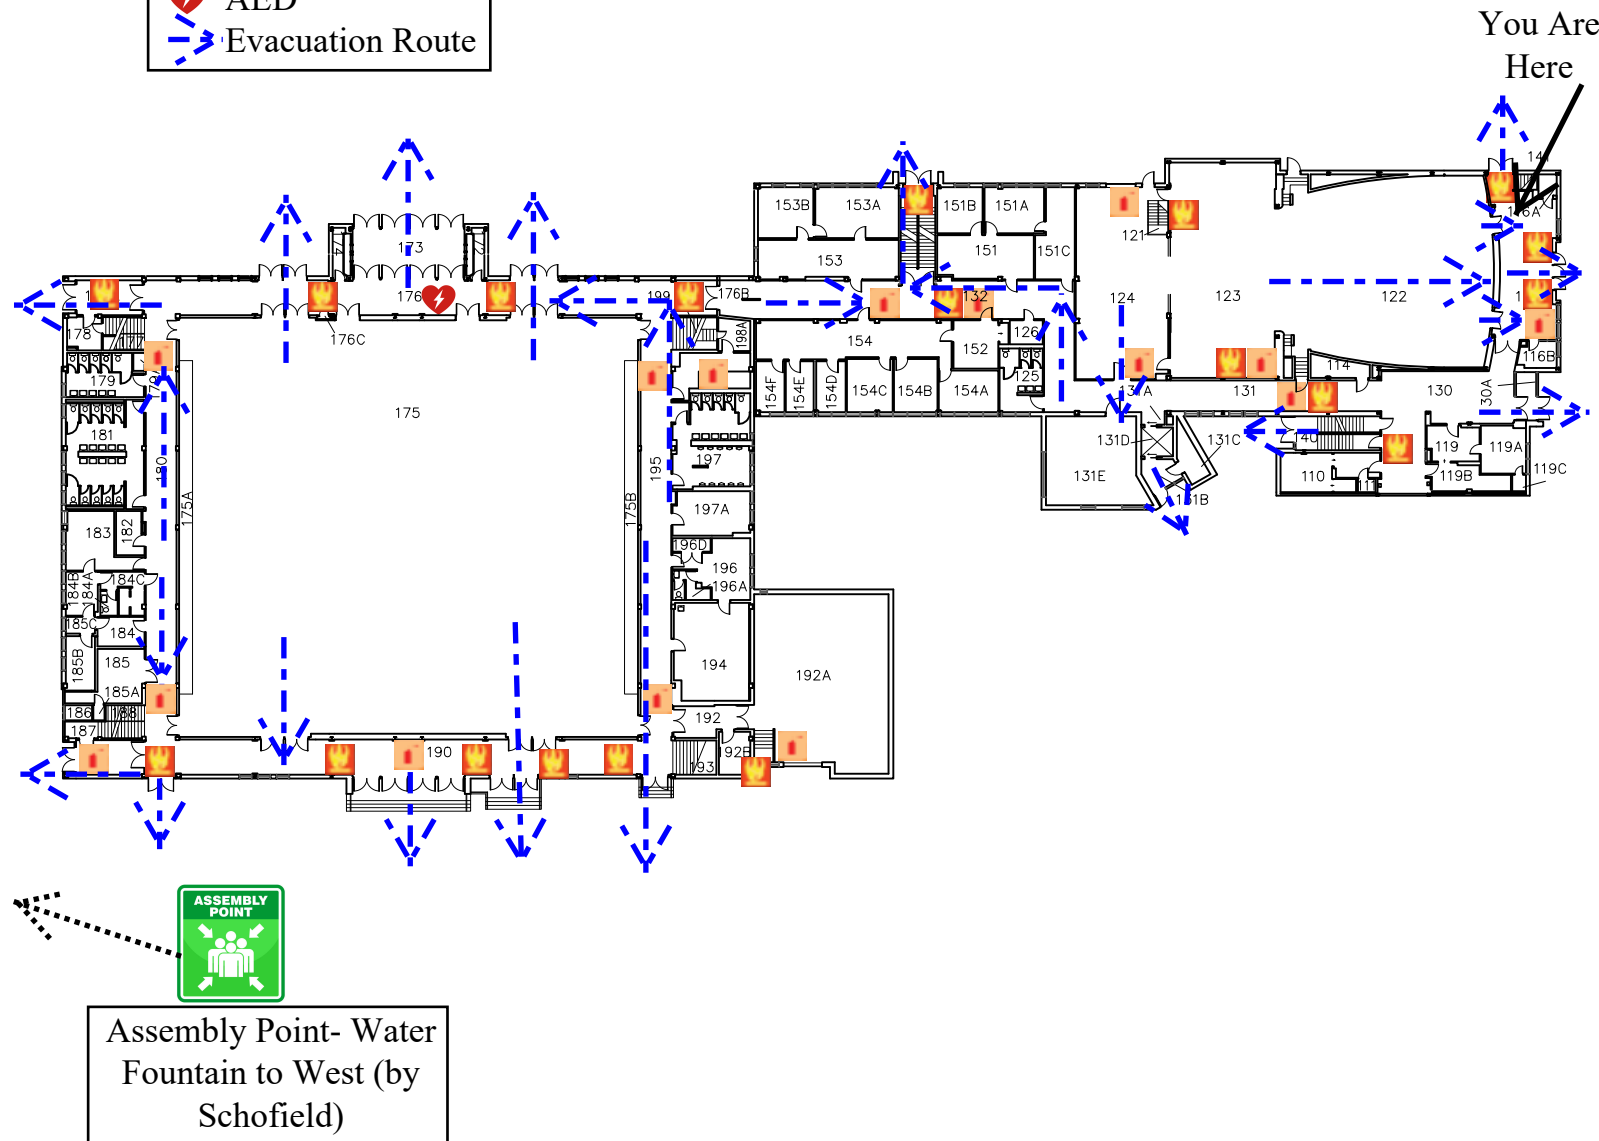


ASSEMBLY POINT



Assembly Point- Water Fountain to West (by Schofield)





 Fire Alarm Pull
 Fire Extinguisher
 AED
 Evacuation Route

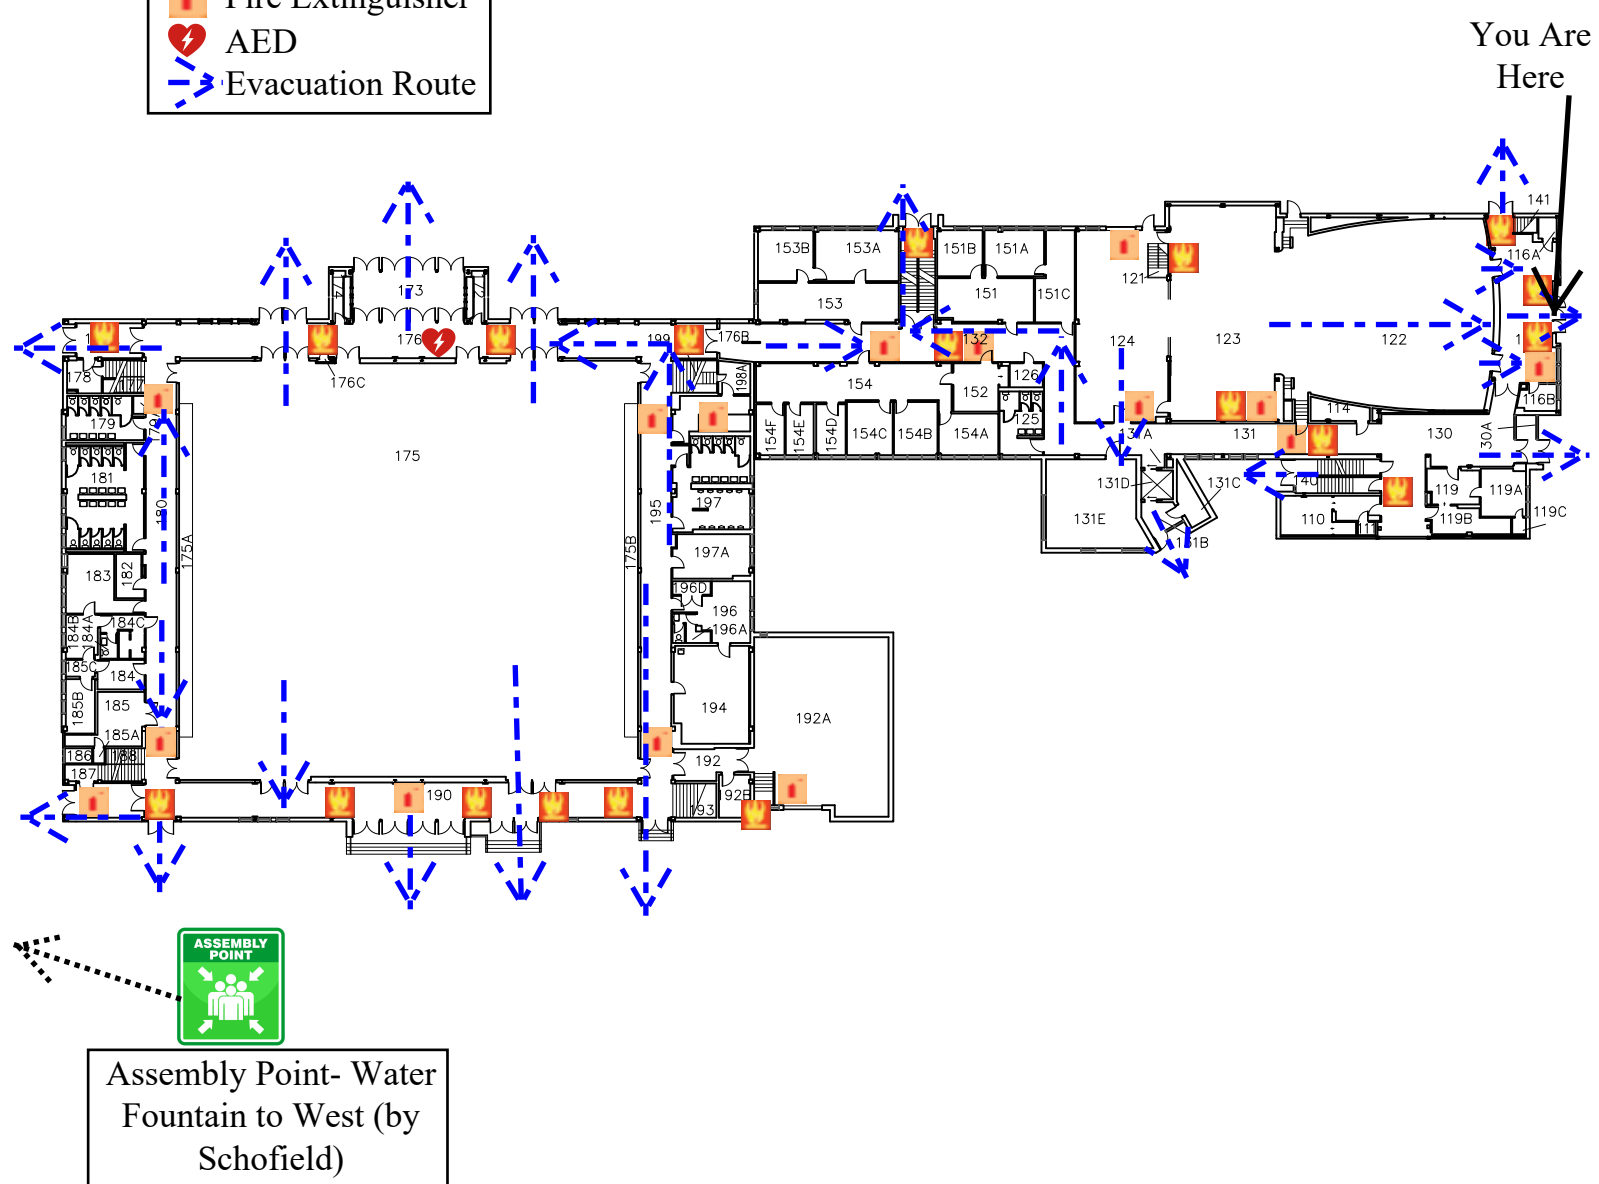



 Fire Alarm Pull
 Fire Extinguisher
 AED
 Evacuation Route

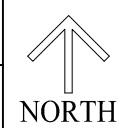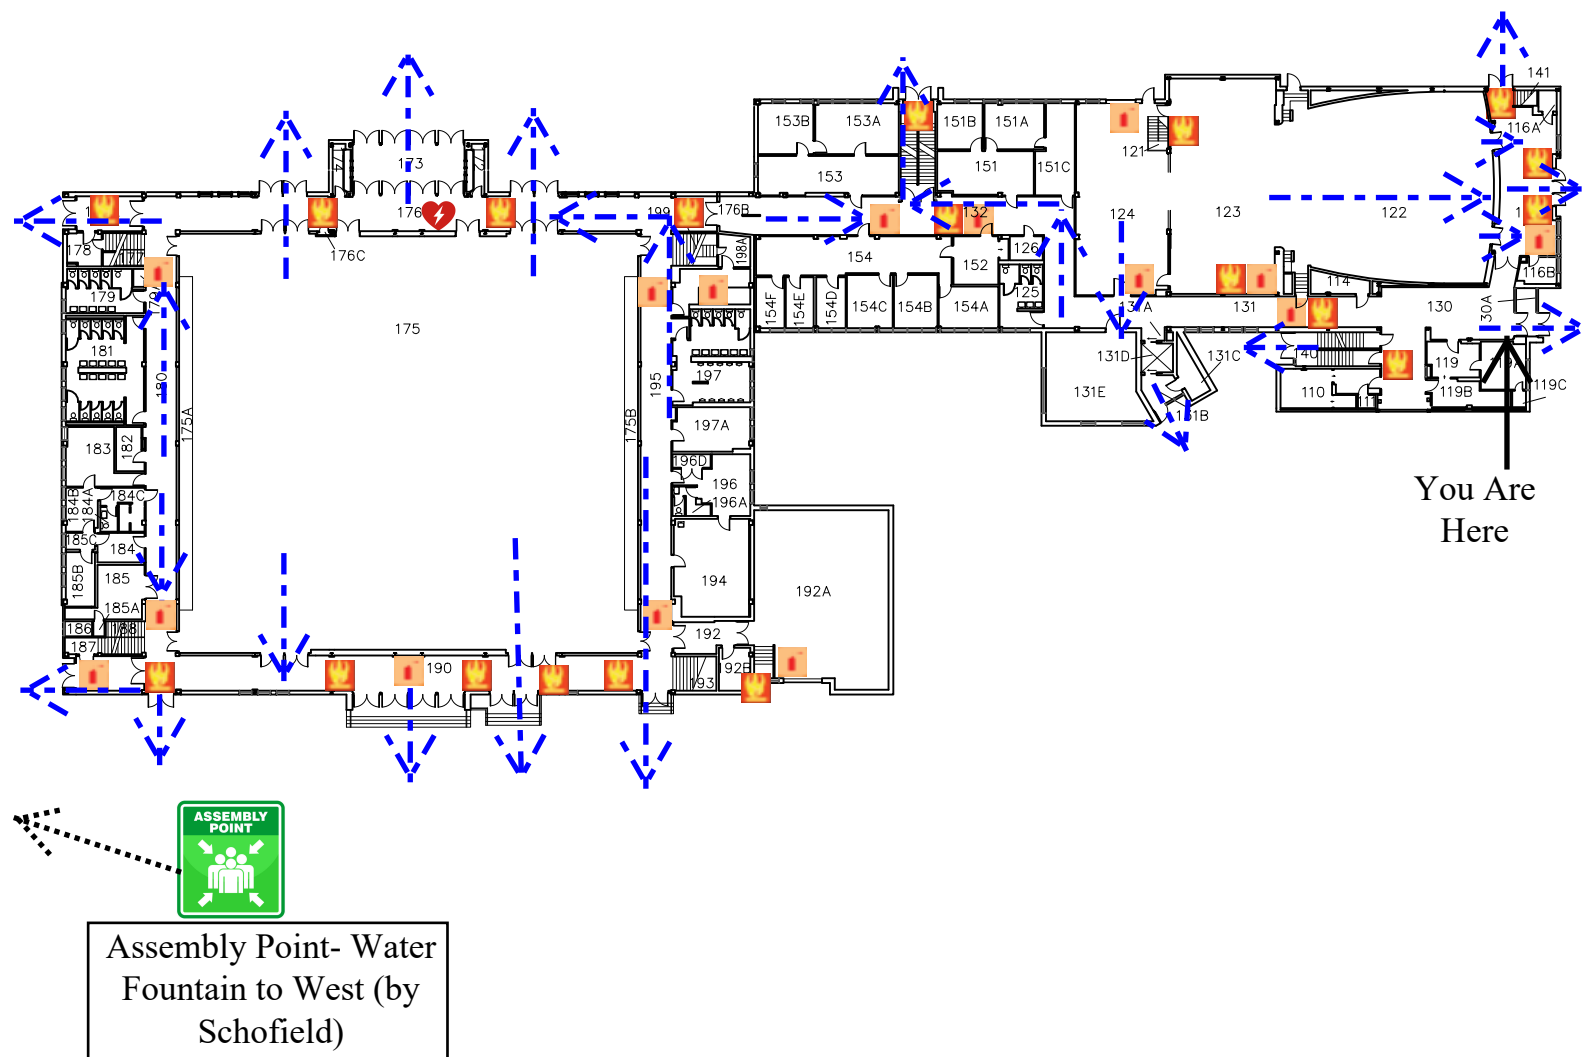

 
 Fire Alarm Pull
 Fire Extinguisher
 AED
 Evacuation Route

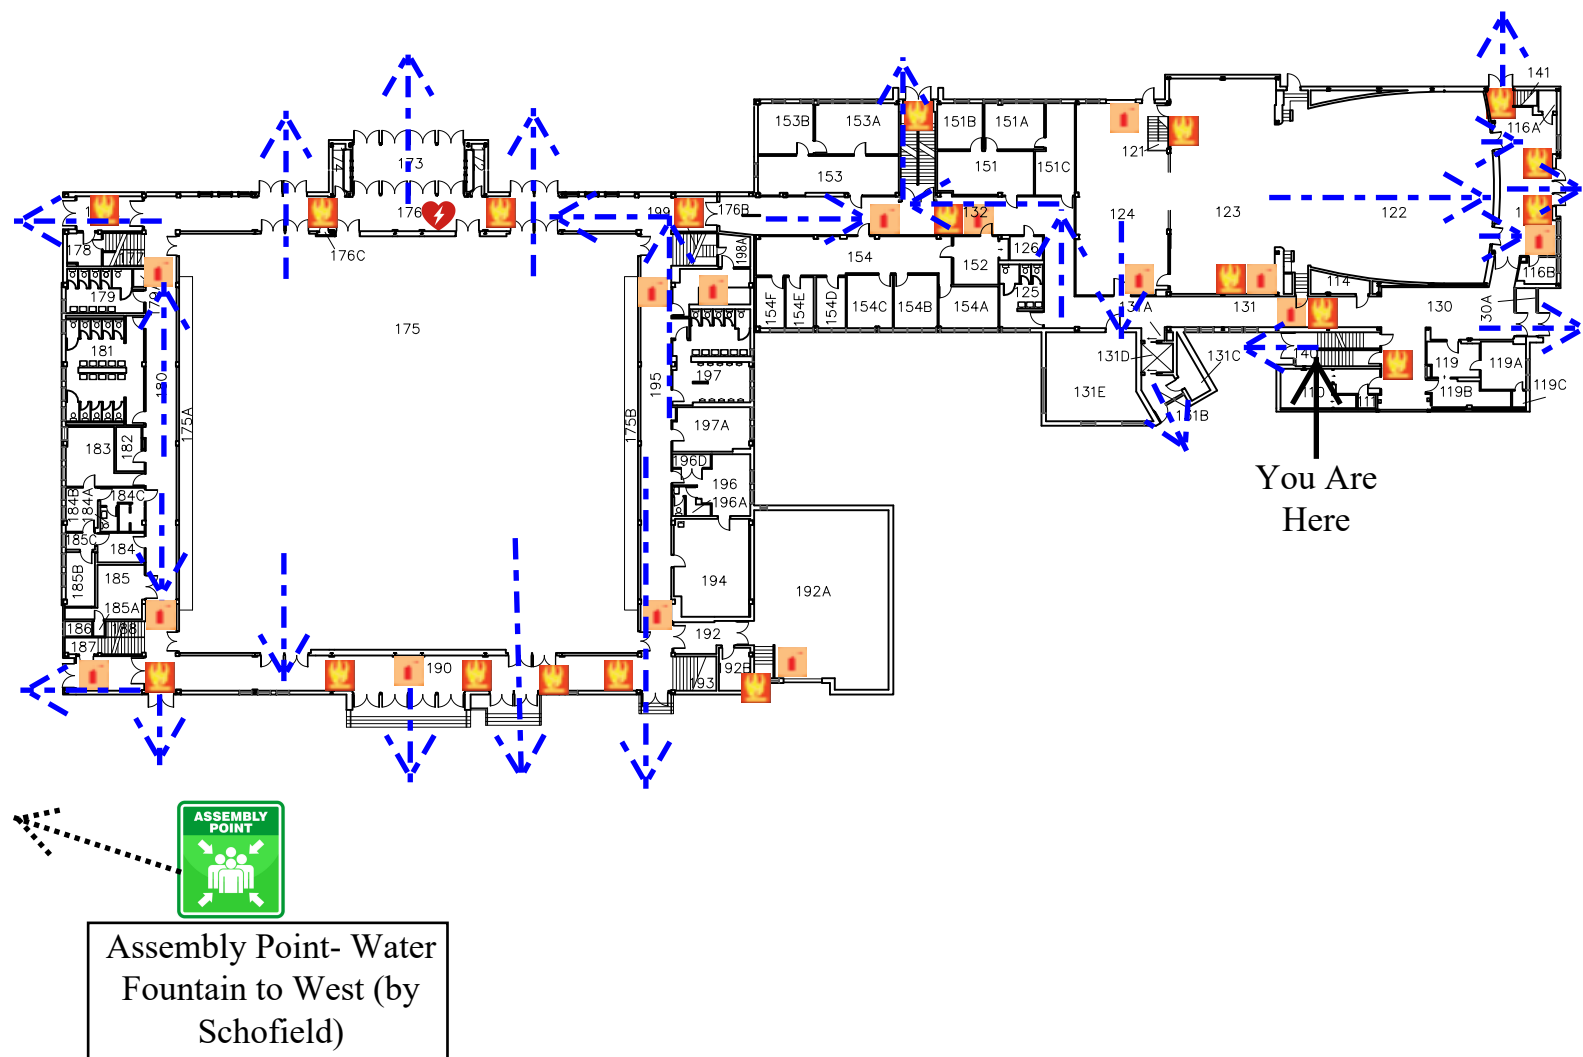

 Fire Alarm Pull
 Fire Extinguisher
 AED
 Evacuation Route

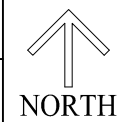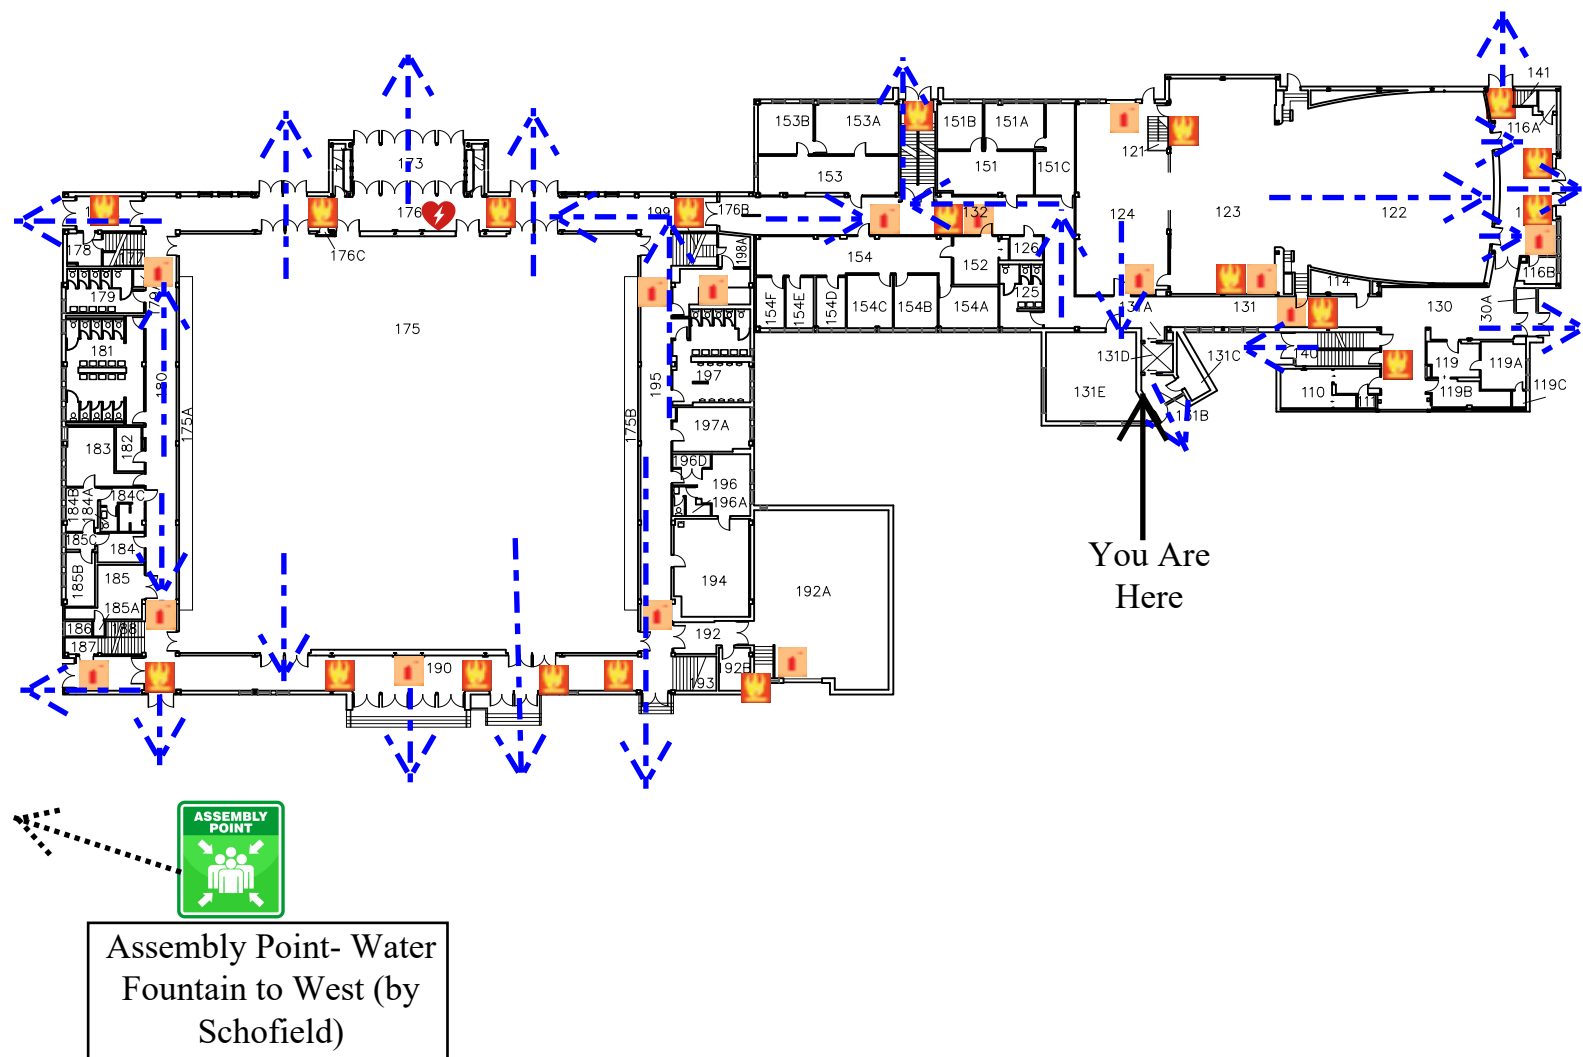



 Fire Alarm Pull
  Fire Extinguisher
  Evacuation Route

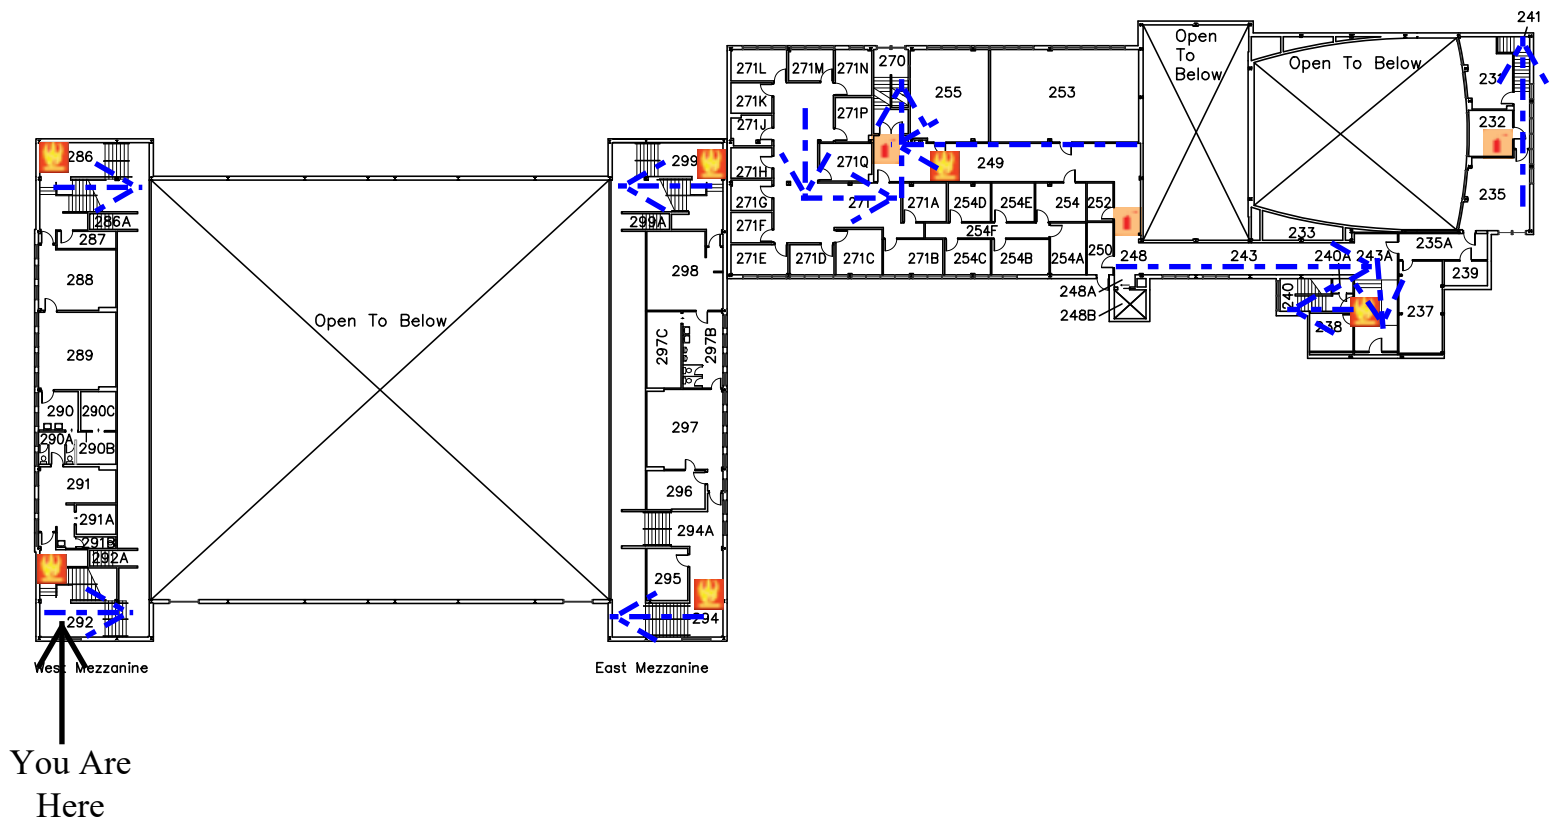

 Fire Alarm Pull
  Fire Extinguisher
  Evacuation Route


You Are Here

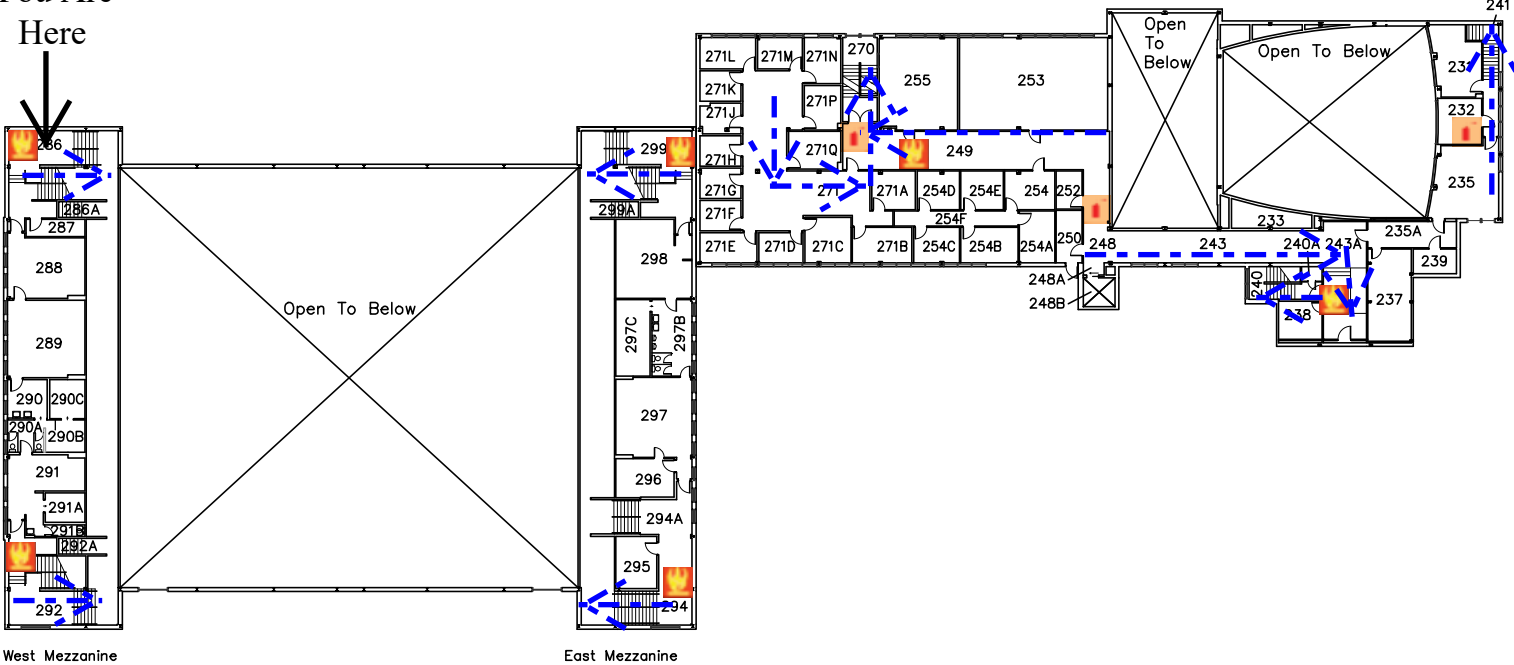

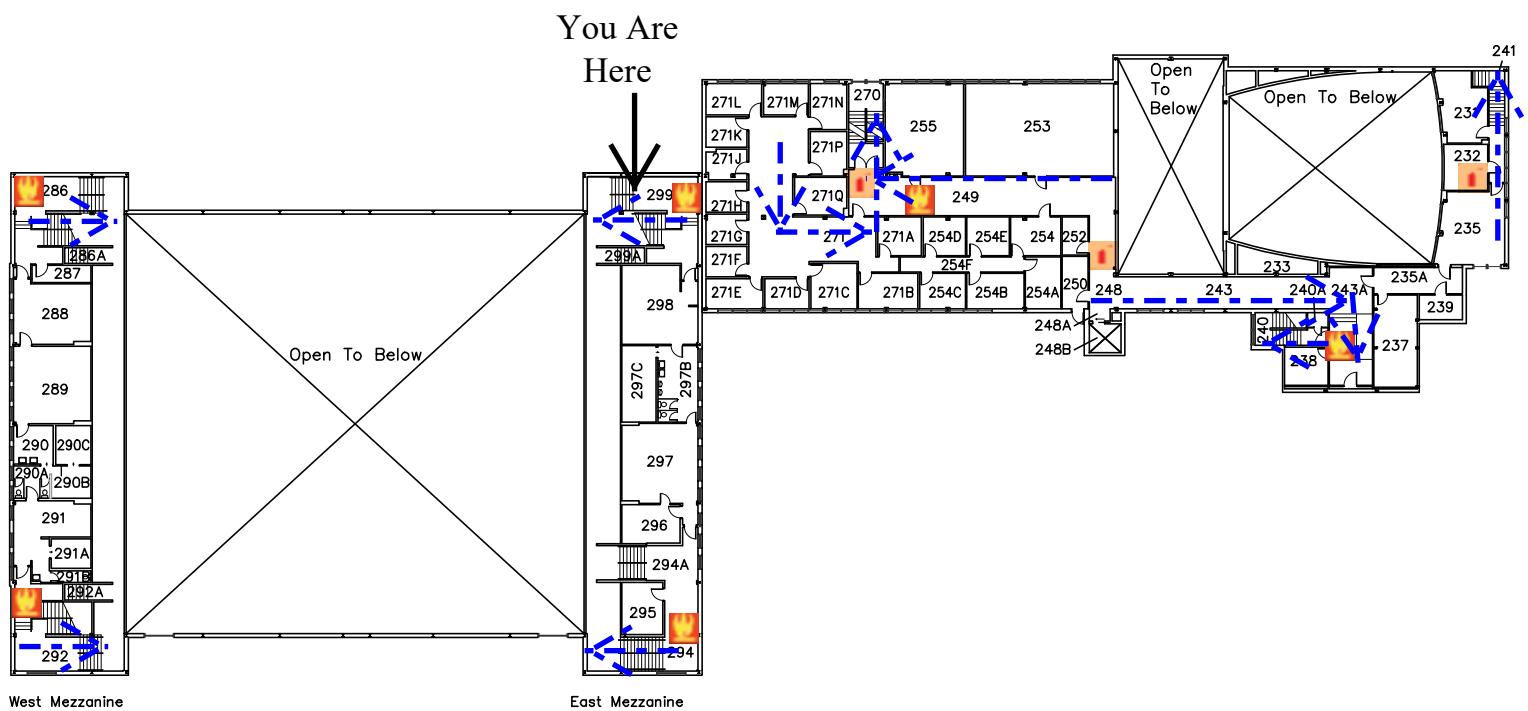


3




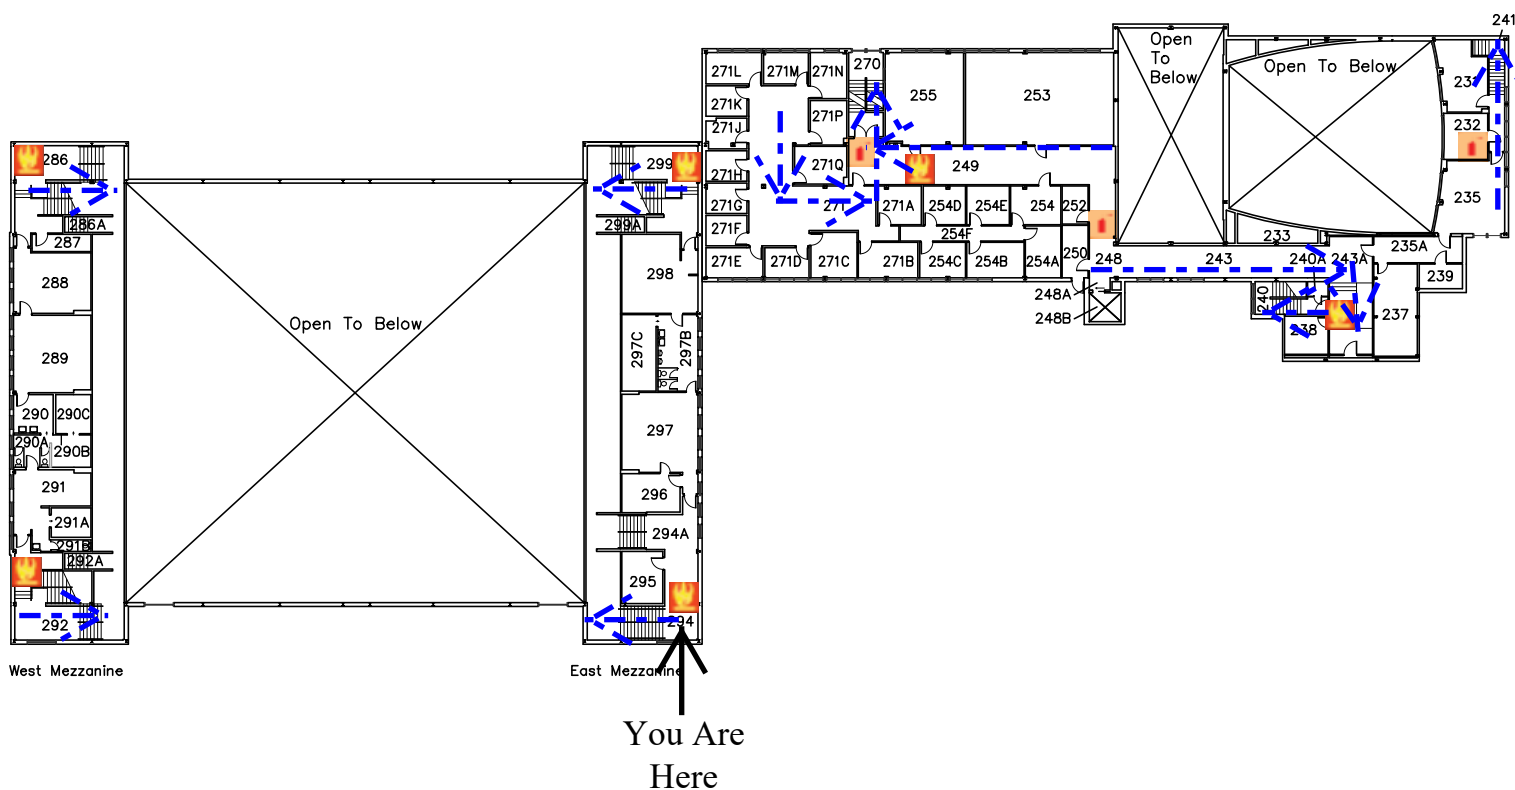

 Fire Alarm Pull
  Fire Extinguisher
  Evacuation Route

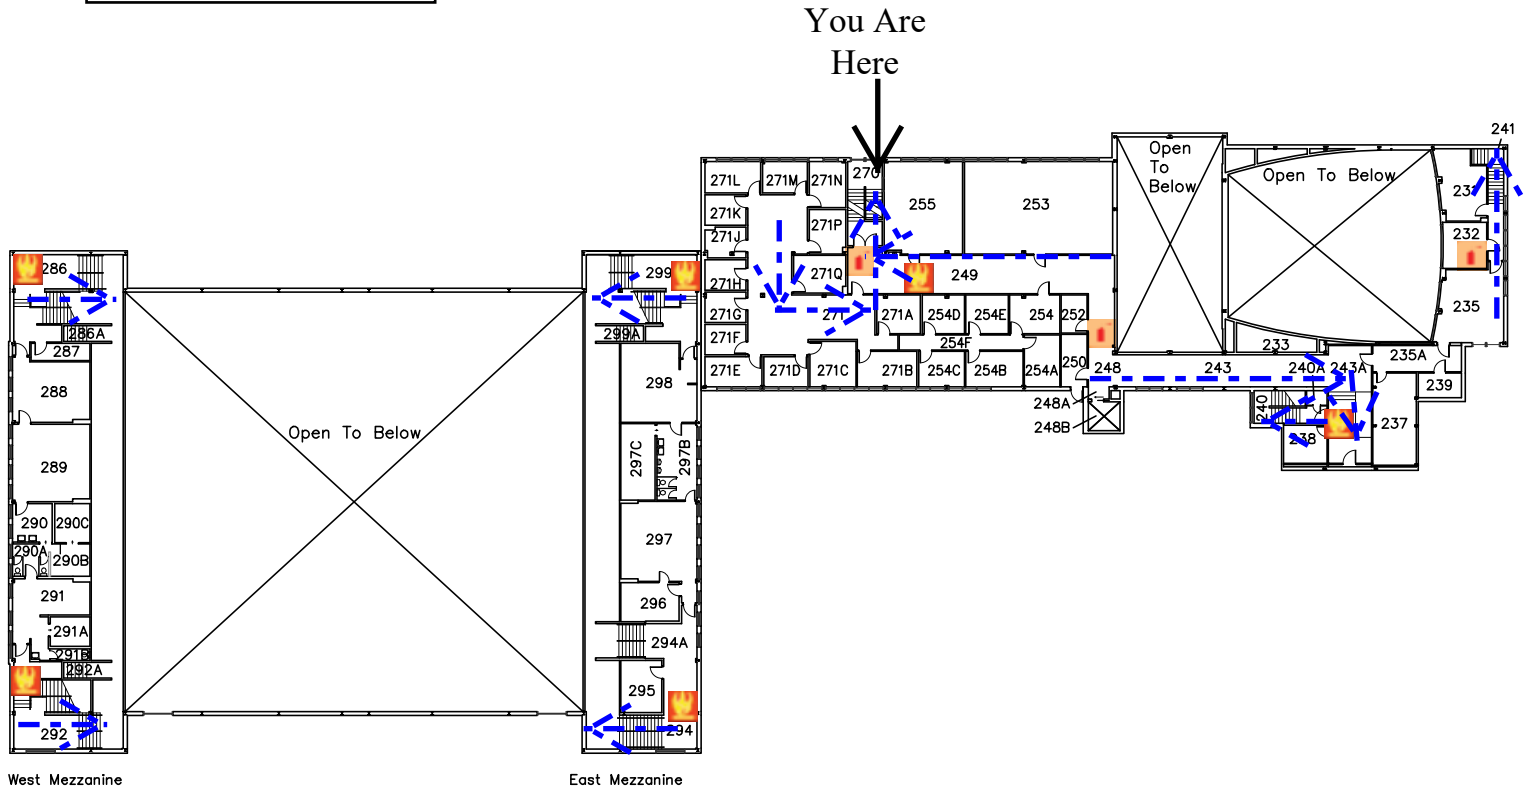


 Fire Alarm Pull
  Fire Extinguisher
  Evacuation Route

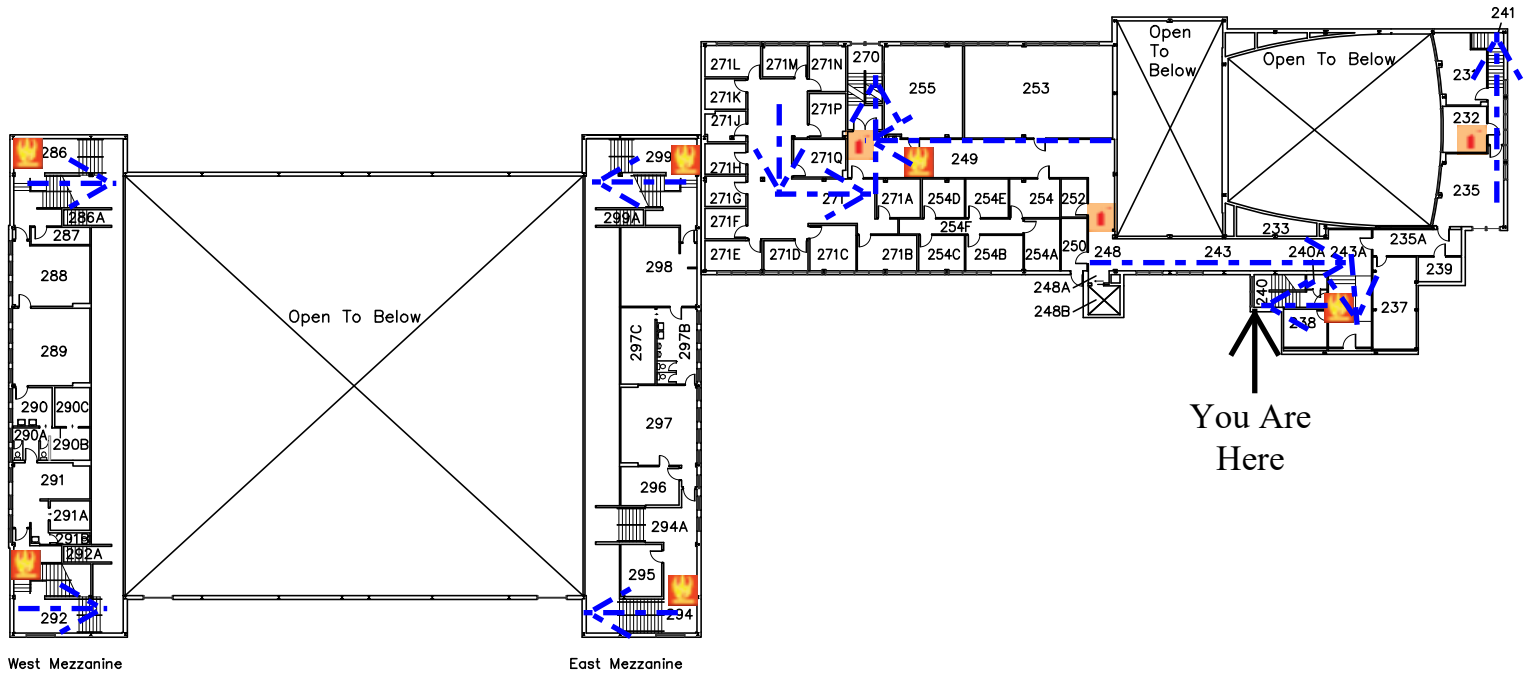



Fire Alarm Pull


Fire Extinguisher



Evacuation Route

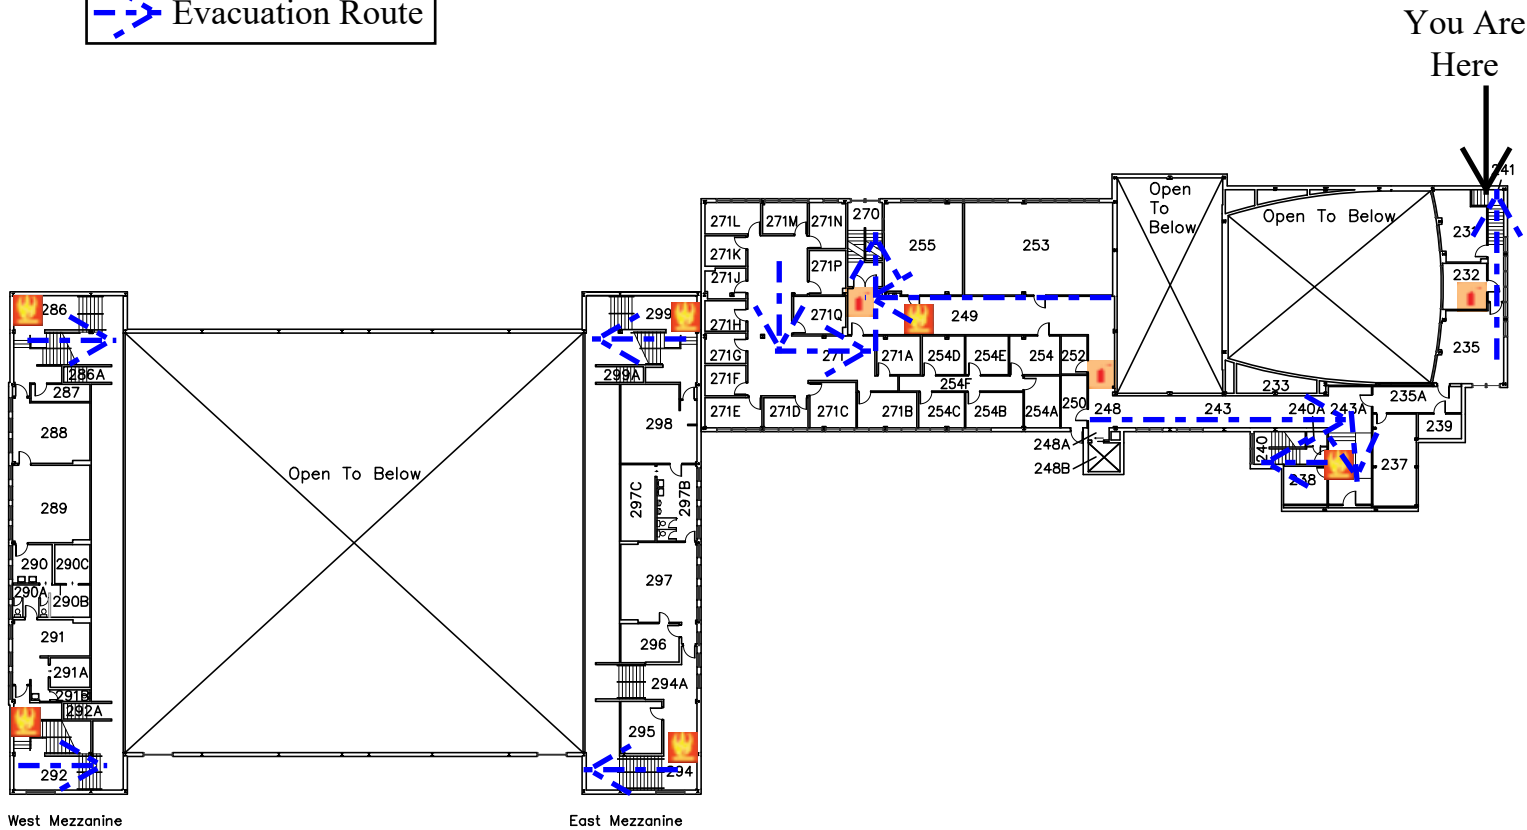


 Fire Alarm Pull
 Fire Extinguisher
 Evacuation Route

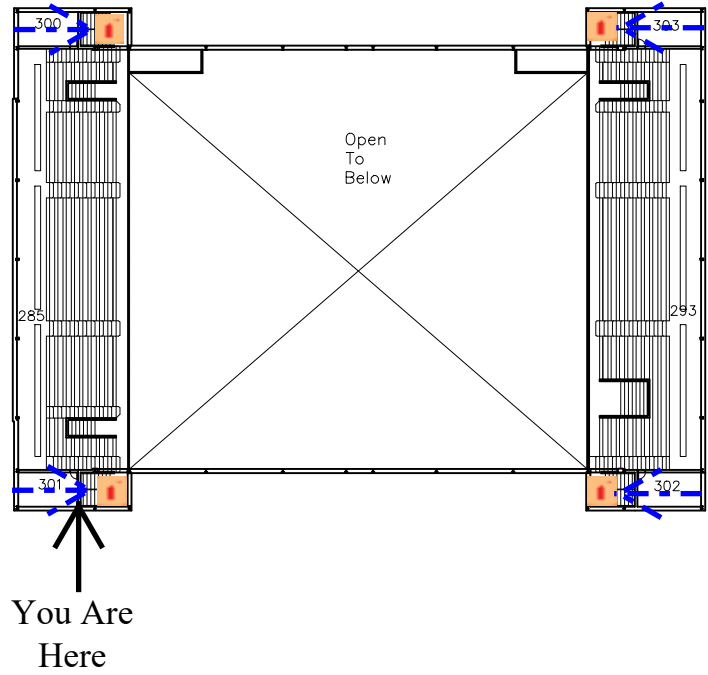

 Fire Alarm Pull
 Fire Extinguisher
 Evacuation Route

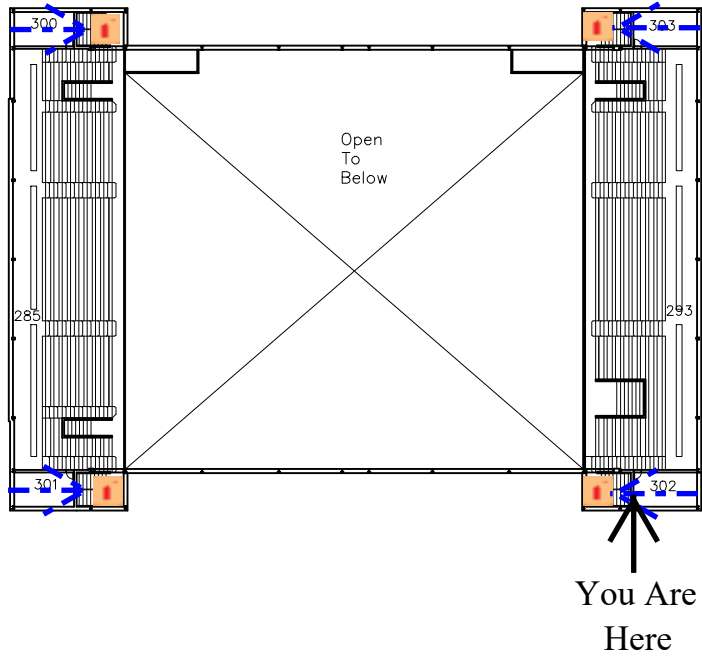

 Fire Alarm Pull
 Fire Extinguisher
 Evacuation Route

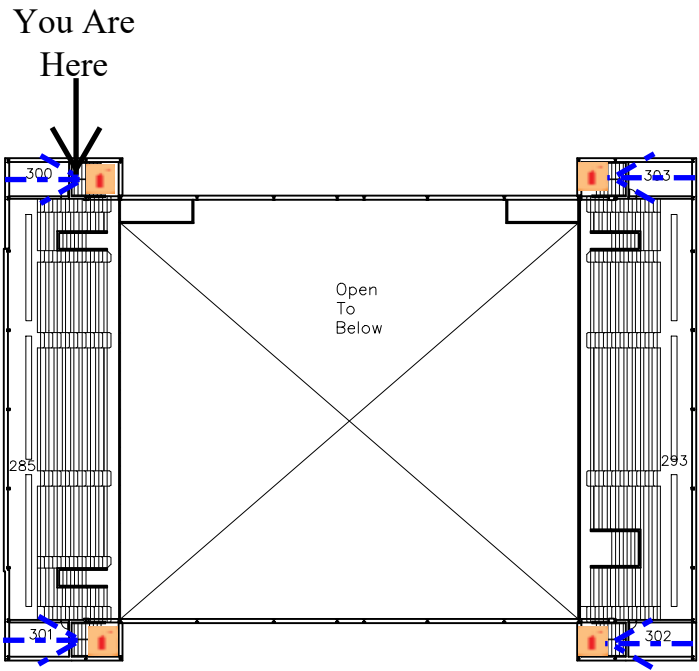

 Fire Alarm Pull
 Fire Extinguisher
 Evacuation Route

