






You Are Here

-  Fire Alarm Pull
-  Fire Extinguisher
-  AED
-  Evacuation Route
-  Shelter Areas (Severe Weather)



 
Assembly Point- Water Fountain towards walking Bridge




University of Wisconsin-Eau Claire Facilities Planning

# Centennial Hall First Floor Plan

DATE: Oct 2021
DWG NO: 1



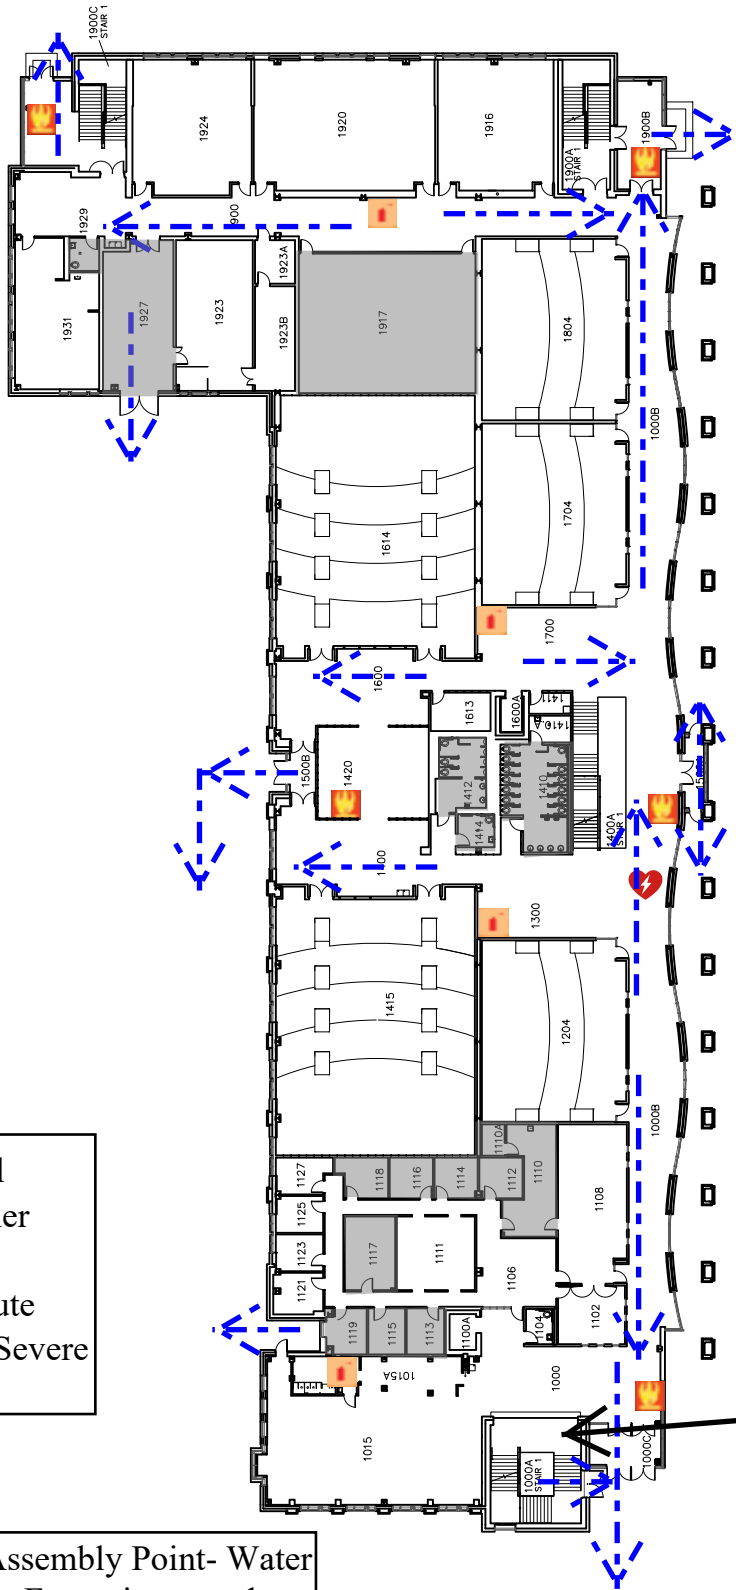

You Are Here

	Fire Alarm Pull
	Fire Extinguisher
	AED
	Evacuation Route
	Shelter Areas (Severe Weather)



Assembly Point- Water Fountain towards walking Bridge









University of Wisconsin-Eau Claire Facilities Planning

# Centennial Hall First Floor Plan

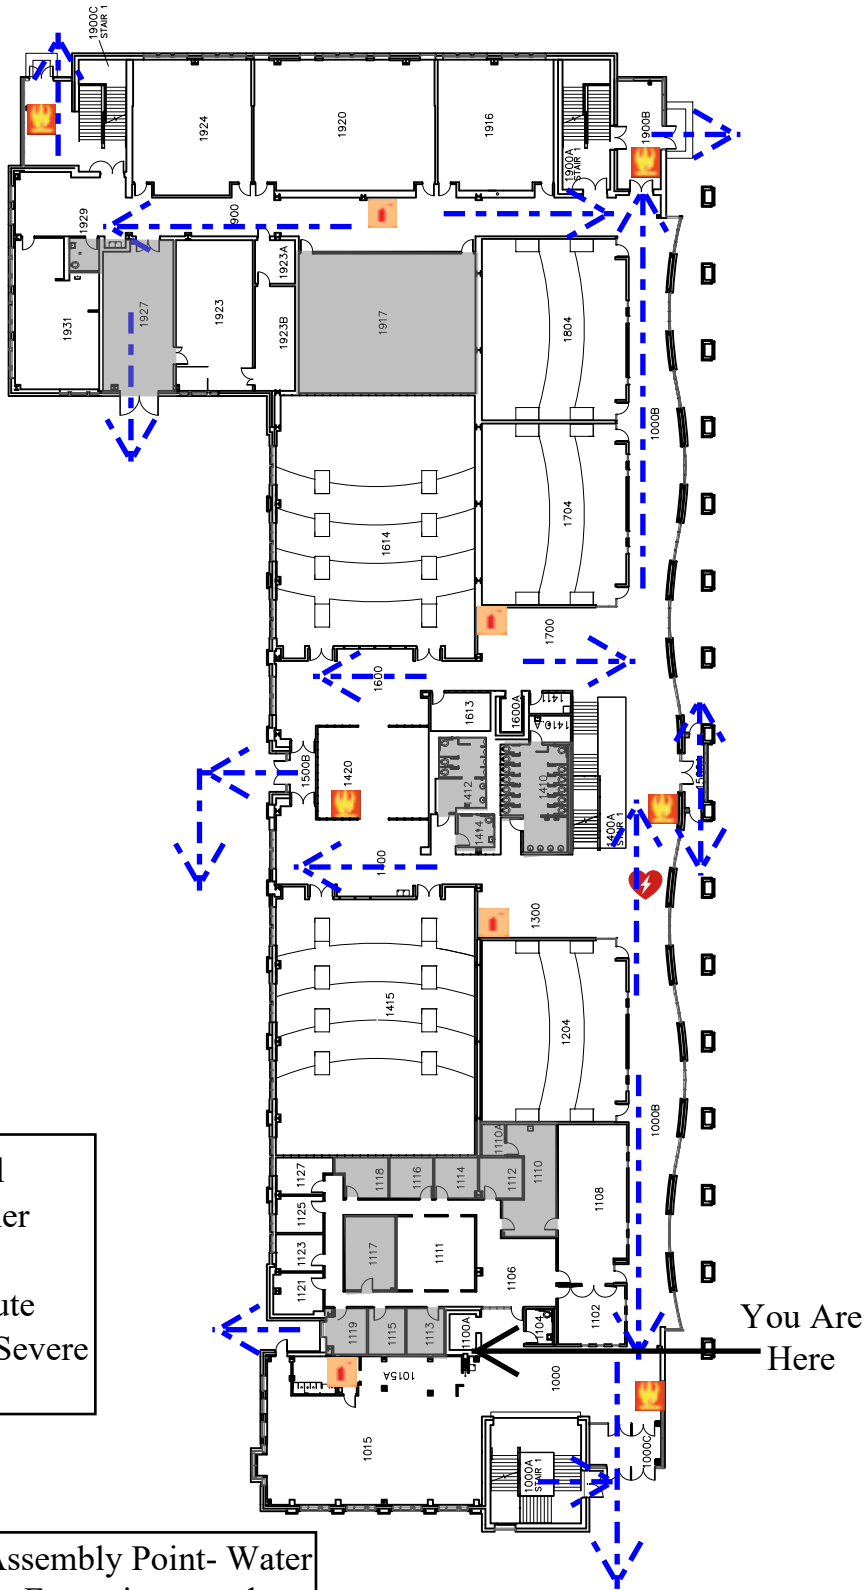DATE:	Oct 2021
DWG NO:	2





-  Fire Alarm Pull
-  Fire Extinguisher
-  AED
-  Evacuation Route
-  Shelter Areas (Severe Weather)



Assembly Point- Water Fountain towards walking Bridge




University of Wisconsin-Eau Claire Facilities Planning






# Centennial Hall First Floor Plan

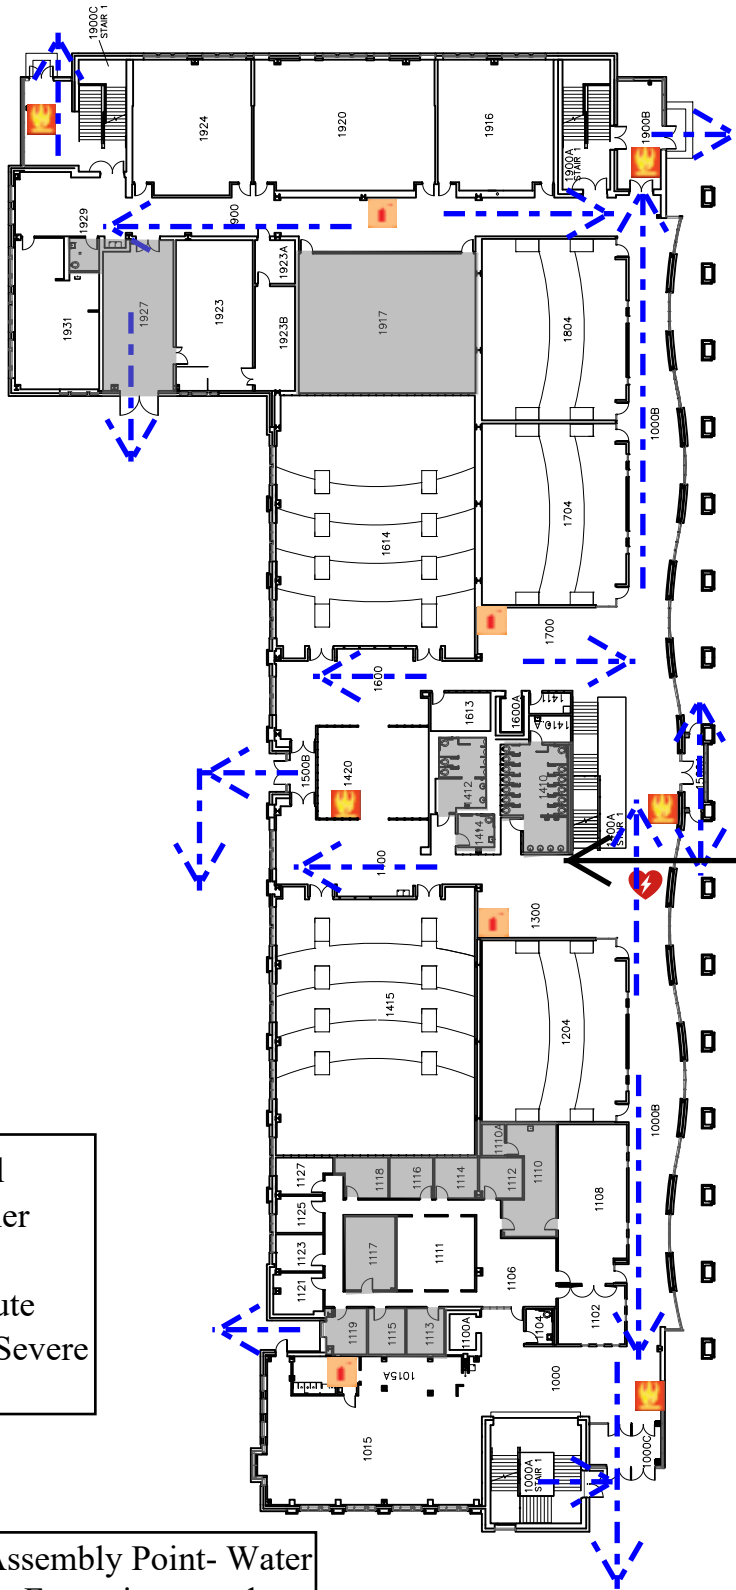DATE:	Oct 2021
DWG NO:	3





You Are Here

-  Fire Alarm Pull
-  Fire Extinguisher
-  AED
-  Evacuation Route
-  Shelter Areas (Severe Weather)



Assembly Point- Water Fountain towards walking Bridge




University of Wisconsin-Eau Claire Facilities Planning






# Centennial Hall First Floor Plan

DATE:	Oct 2021
DWG NO:	4

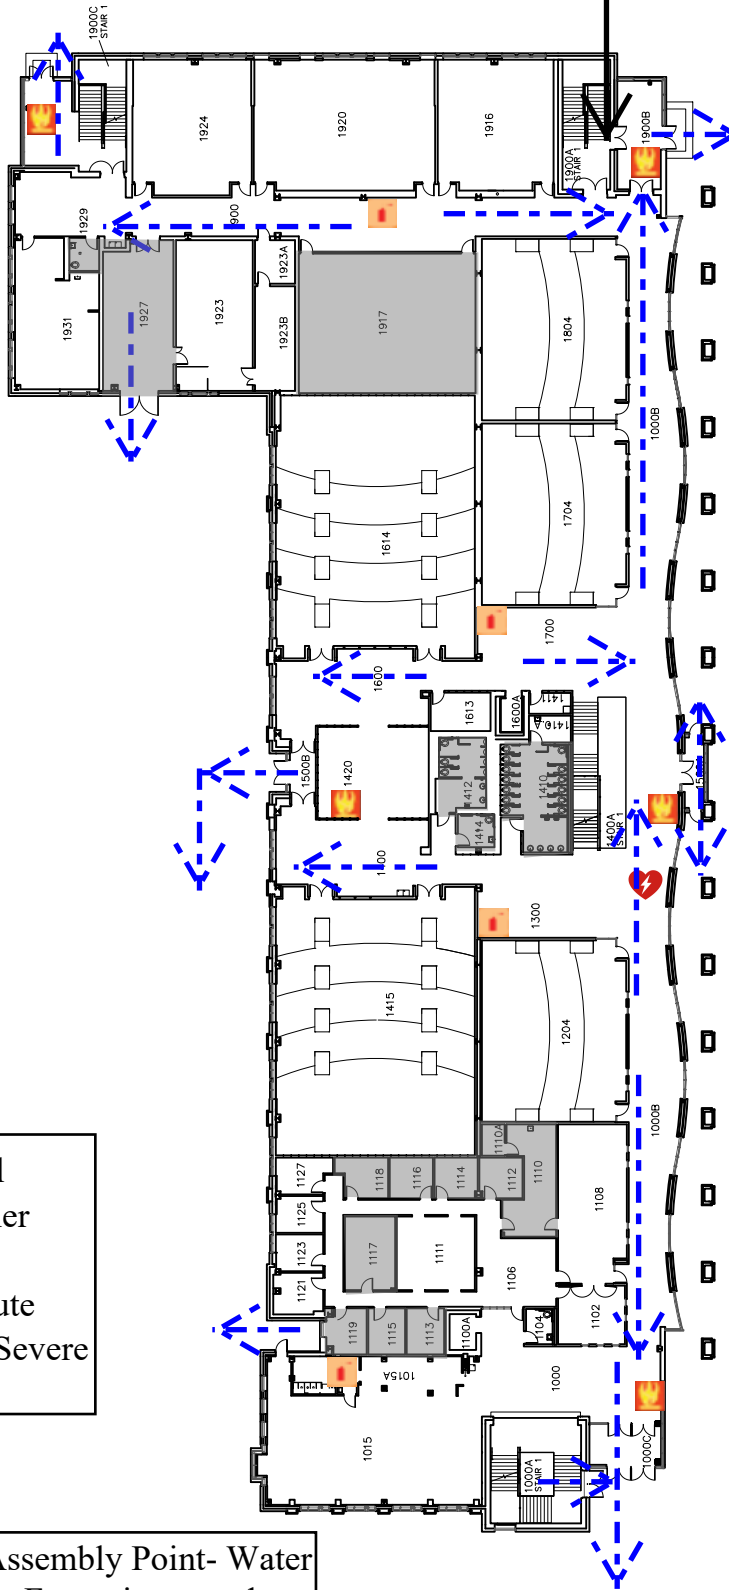

You Are Here



-  Fire Alarm Pull
-  Fire Extinguisher
-  AED
-  Evacuation Route
-  Shelter Areas (Severe Weather)



Assembly Point- Water Fountain towards walking Bridge




University of Wisconsin-Eau Claire Facilities Planning






# Centennial Hall First Floor Plan

DATE:  
Oct 2021  
DWG NO:  
5

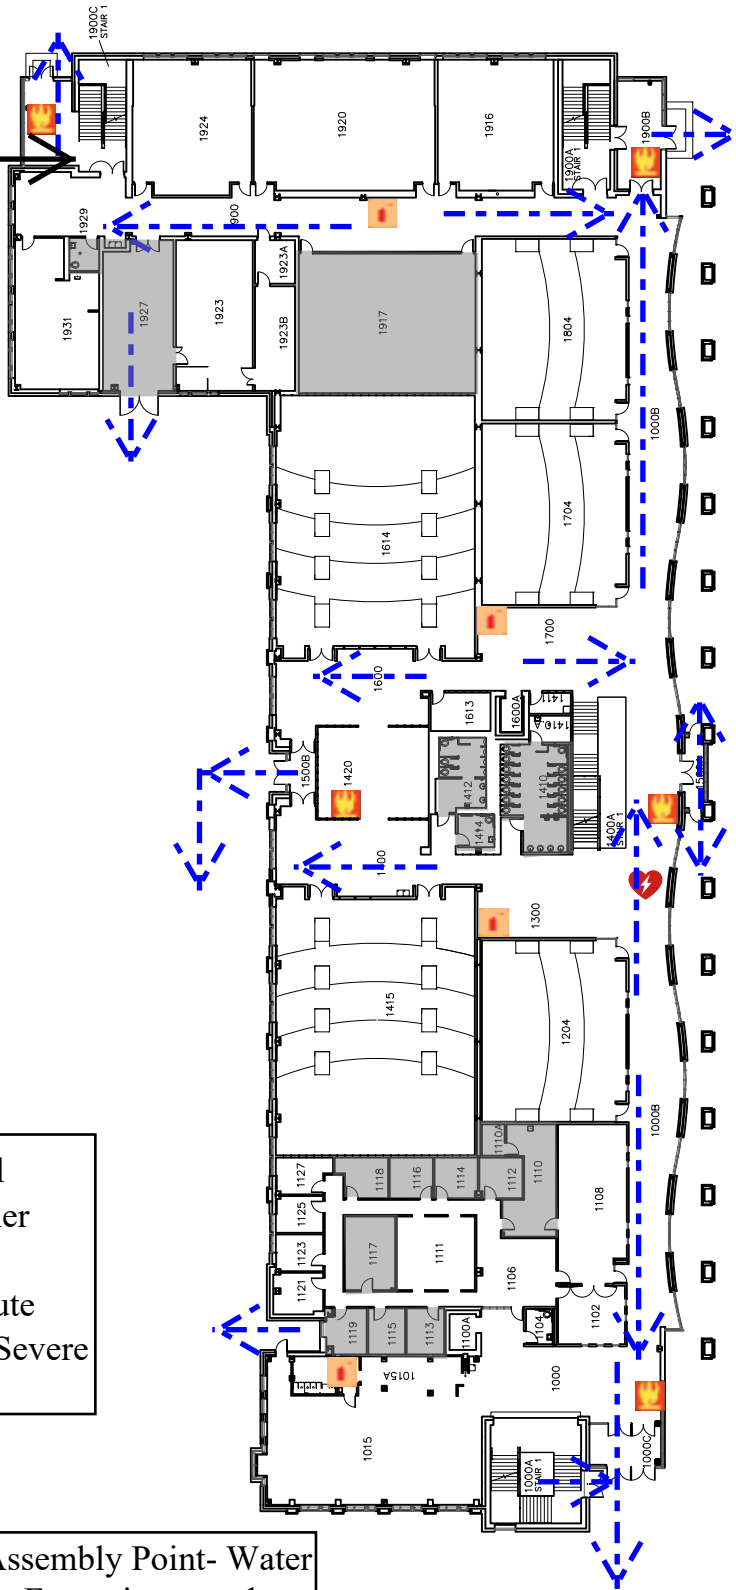

You Are Here



-  Fire Alarm Pull
-  Fire Extinguisher
-  AED
-  Evacuation Route
-  Shelter Areas (Severe Weather)



Assembly Point- Water Fountain towards walking Bridge









University of Wisconsin-Eau Claire Facilities Planning

# Centennial Hall First Floor Plan

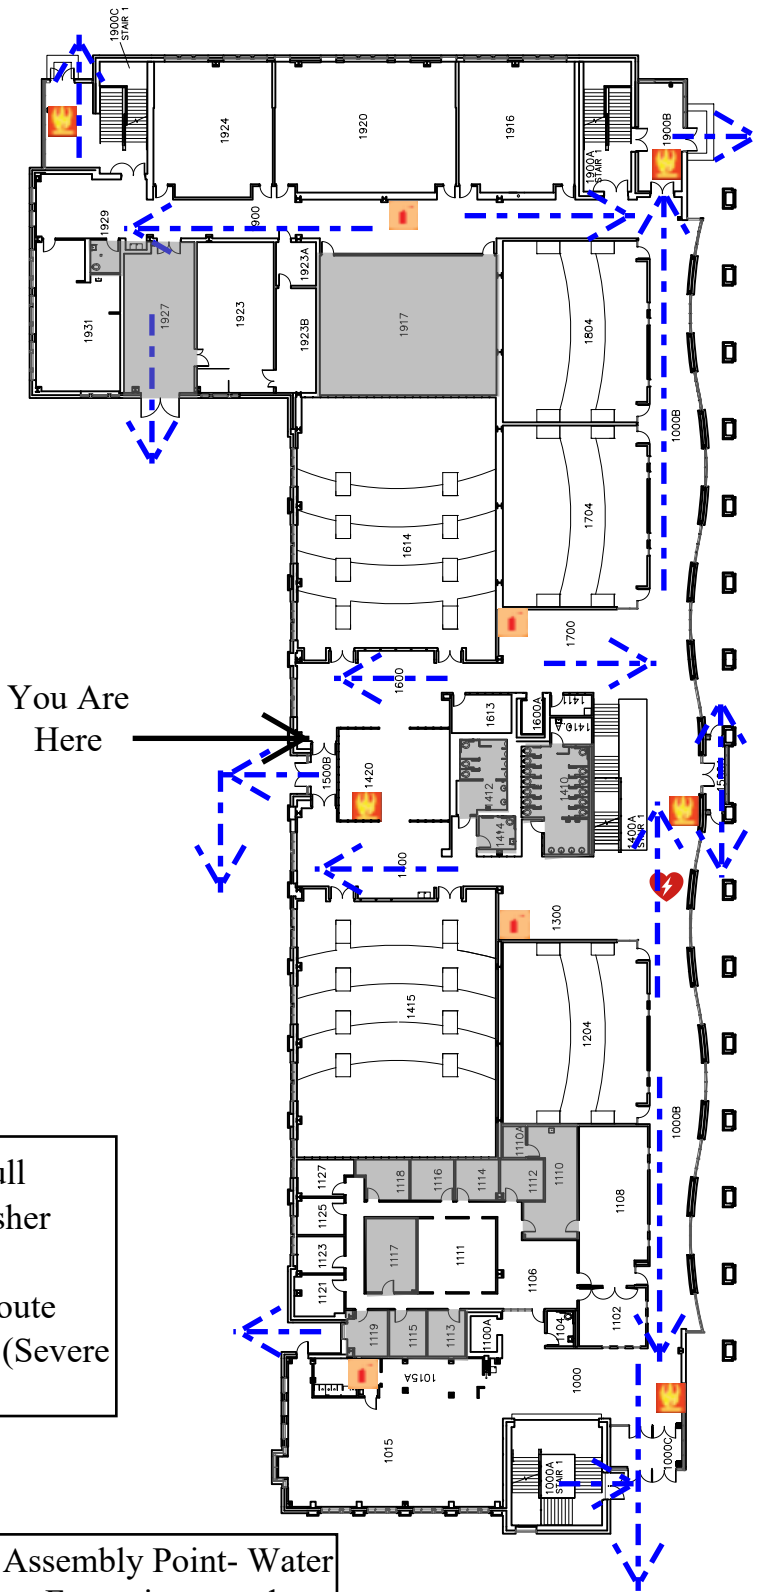DATE:  
Oct 2021  
DWG NO:  
6





-  Fire Alarm Pull
-  Fire Extinguisher
-  AED
-  Evacuation Route
-  Shelter Areas (Severe Weather)



Assembly Point- Water Fountain towards walking Bridge









University of Wisconsin-Eau Claire Facilities Planning

# Centennial Hall First Floor Plan

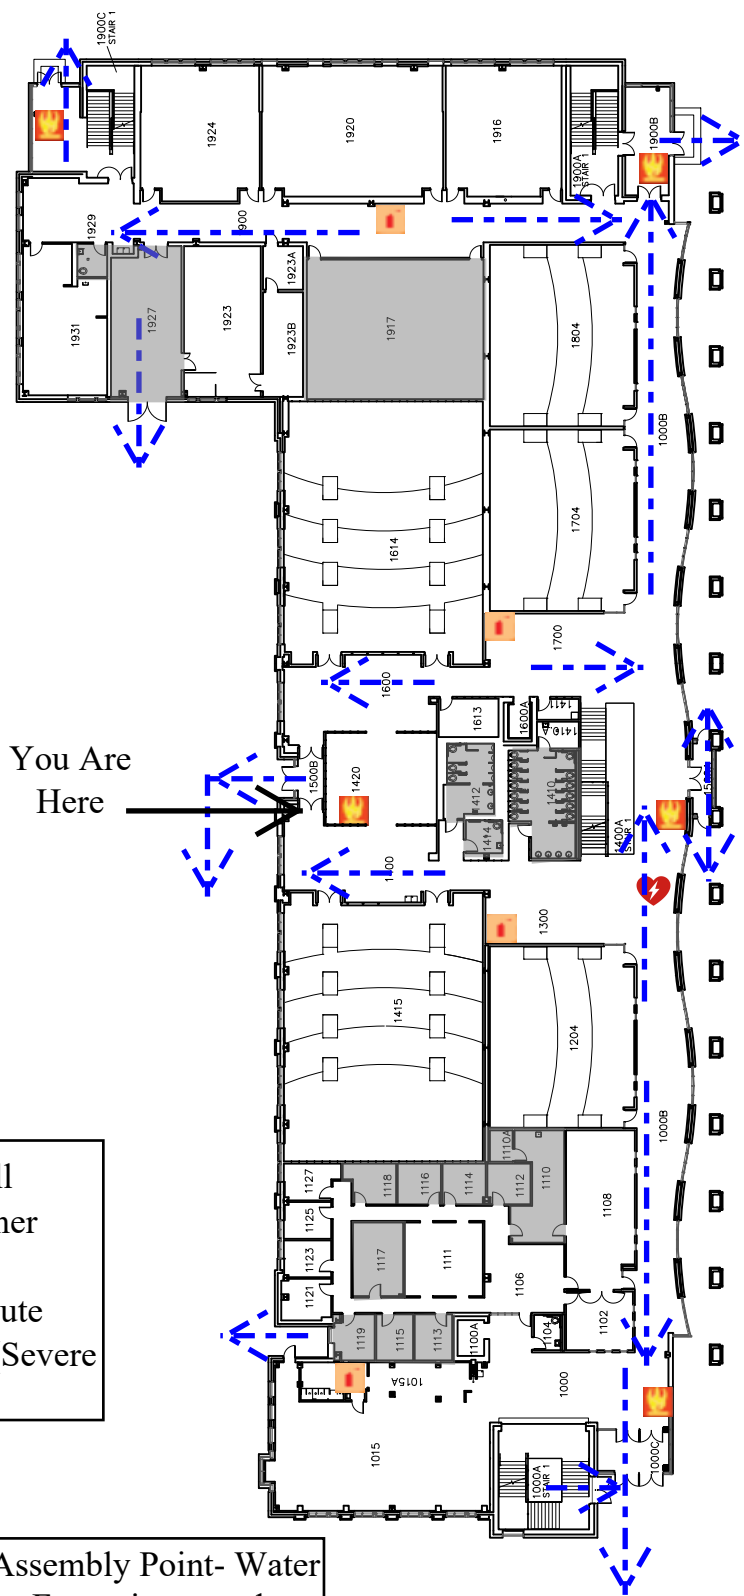DATE: Oct 2021
DWG NO: 7





-  Fire Alarm Pull
-  Fire Extinguisher
-  AED
-  Evacuation Route
-  Shelter Areas (Severe Weather)



Assembly Point- Water Fountain towards walking Bridge




University of Wisconsin-Eau Claire Facilities Planning






# Centennial Hall First Floor Plan

DATE: Oct 2021
DWG NO: 8

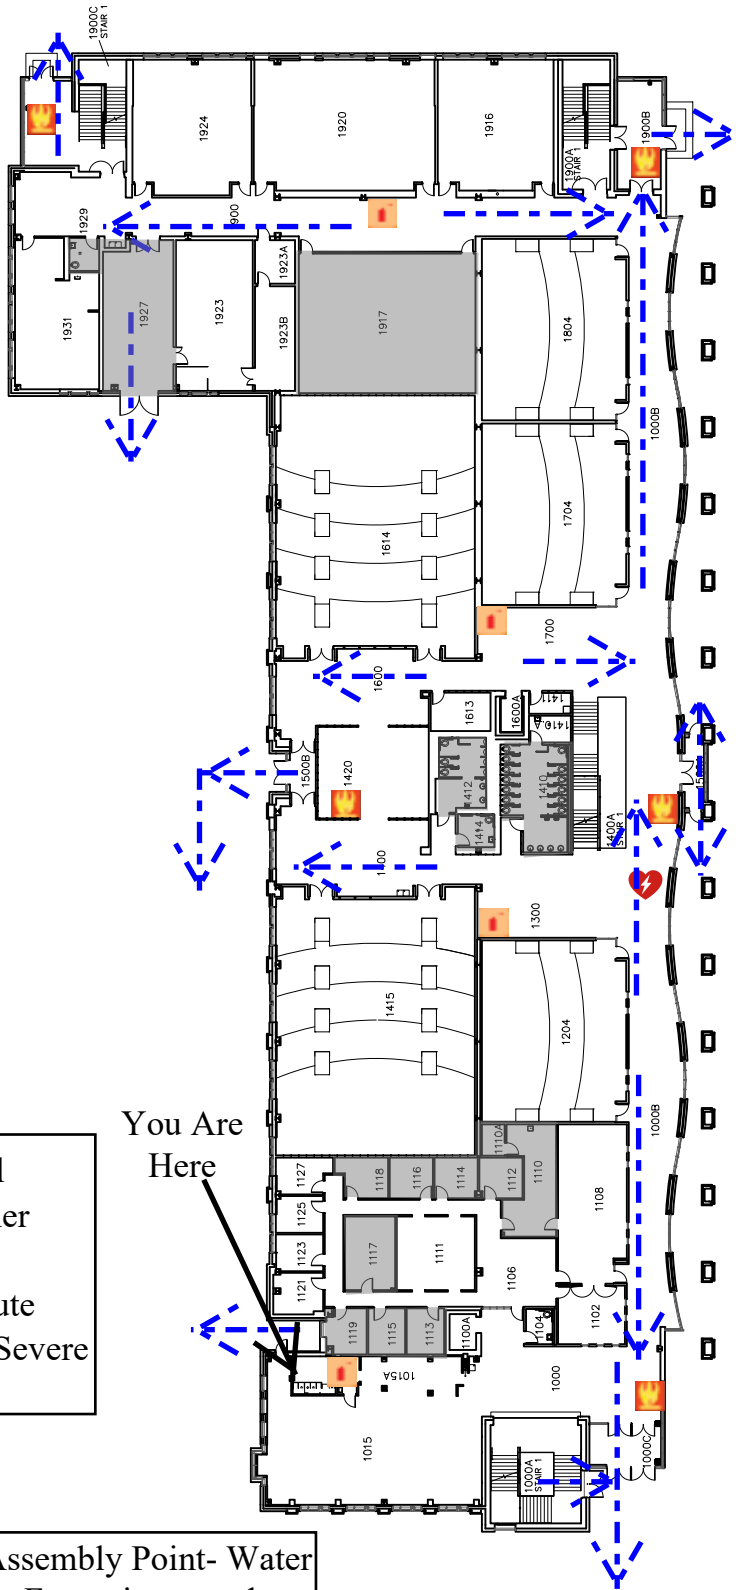





-  Fire Alarm Pull
-  Fire Extinguisher
-  AED
-  Evacuation Route
-  Shelter Areas (Severe Weather)

You Are Here



Assembly Point- Water Fountain towards walking Bridge







University of Wisconsin-Eau Claire Facilities Planning

# Centennial Hall First Floor Plan

DATE: Oct 2021
DWG NO: 9





-  Fire Alarm Pull
-  Fire Extinguisher
-  Evacuation Route
-  Shelter Areas (Severe Weather)

You Are Here








# Centennial Hall Second Floor Plan






You Are Here

-  Fire Alarm Pull
-  Fire Extinguisher
-  Evacuation Route
-  Shelter Areas (Severe Weather)

	University of Wisconsin-Eau Claire Facilities Planning	DATE: Oct. 2021
	<h1>Centennial Hall Second Floor Plan</h1>	
	DWG NO: 2	



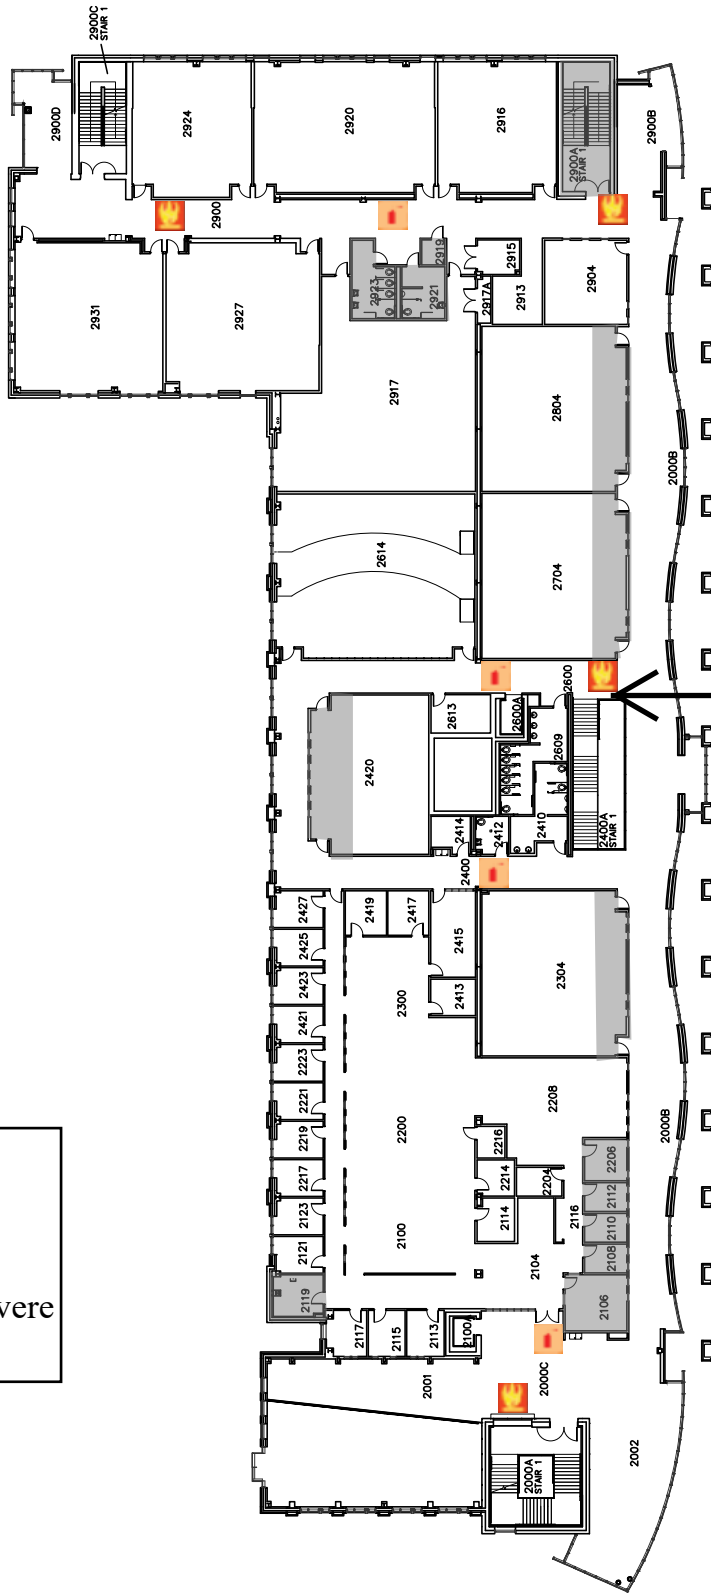






You Are Here

	Fire Alarm Pull
	Fire Extinguisher
	Evacuation Route
	Shelter Areas (Severe Weather)

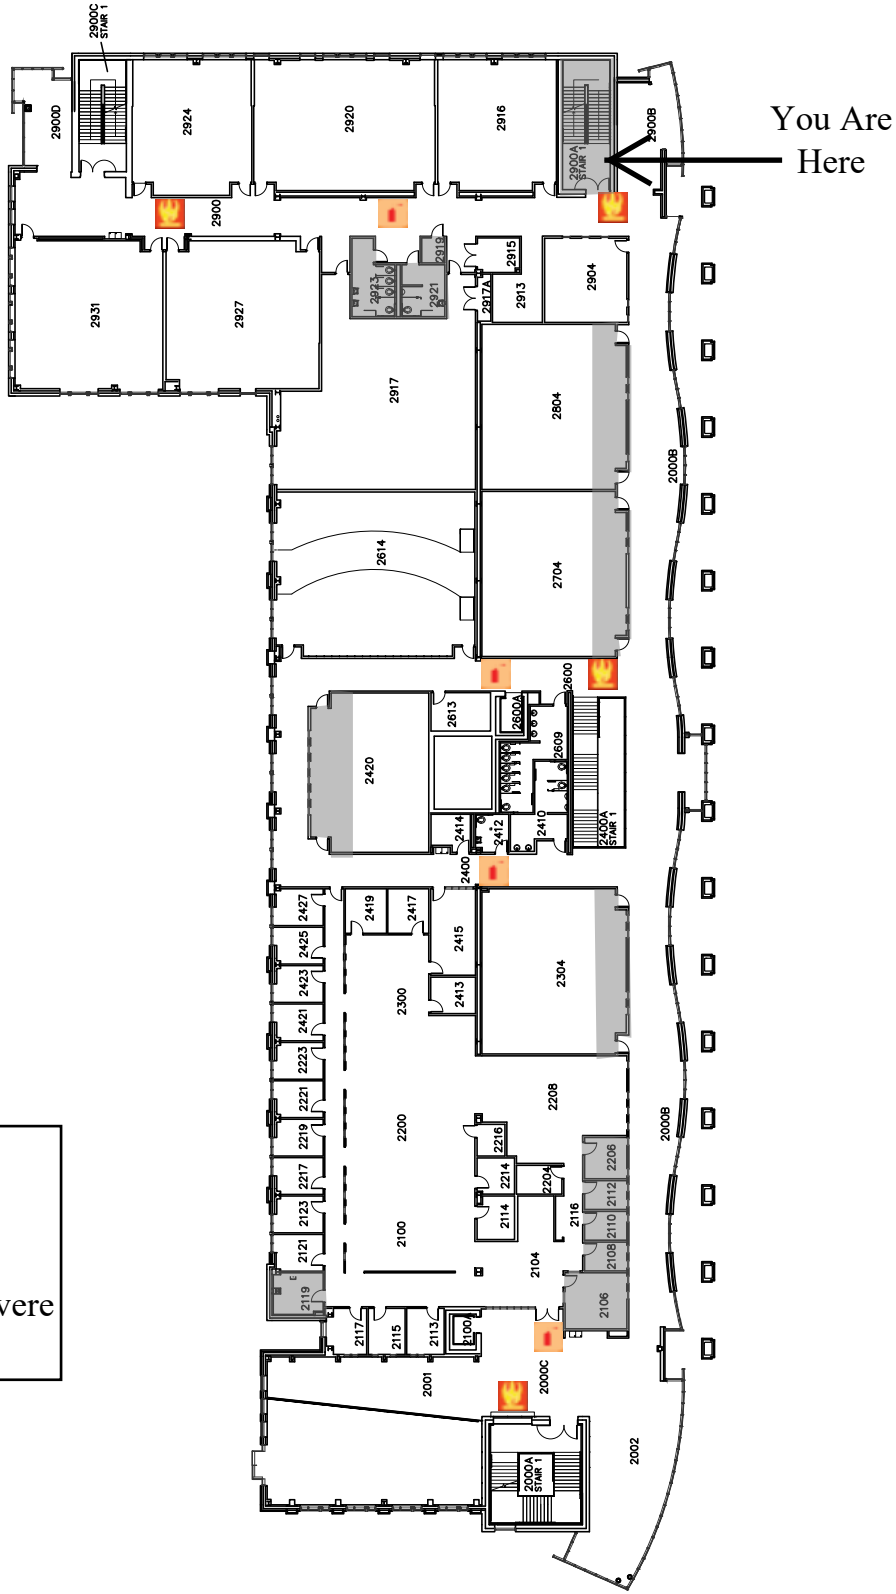	University of Wisconsin-Eau Claire Facilities Planning	DATE: Oct. 2021
	<h1>Centennial Hall</h1> <h2>Second Floor Plan</h2>	
		DWG NO: 3





-  Fire Alarm Pull
-  Fire Extinguisher
-  Evacuation Route
-  Shelter Areas (Severe Weather)



## Centennial Hall Second Floor Plan



You Are Here



	Fire Alarm Pull
	Fire Extinguisher
	Evacuation Route
	Shelter Areas (Severe Weather)








University of Wisconsin-Eau Claire Facilities Planning

# Centennial Hall Second Floor Plan

DATE:  
Oct. 2021

DWG NO:  
5



	Fire Alarm Pull
	Fire Extinguisher
	AED
	Evacuation Route
	Shelter Areas (Severe Weather)








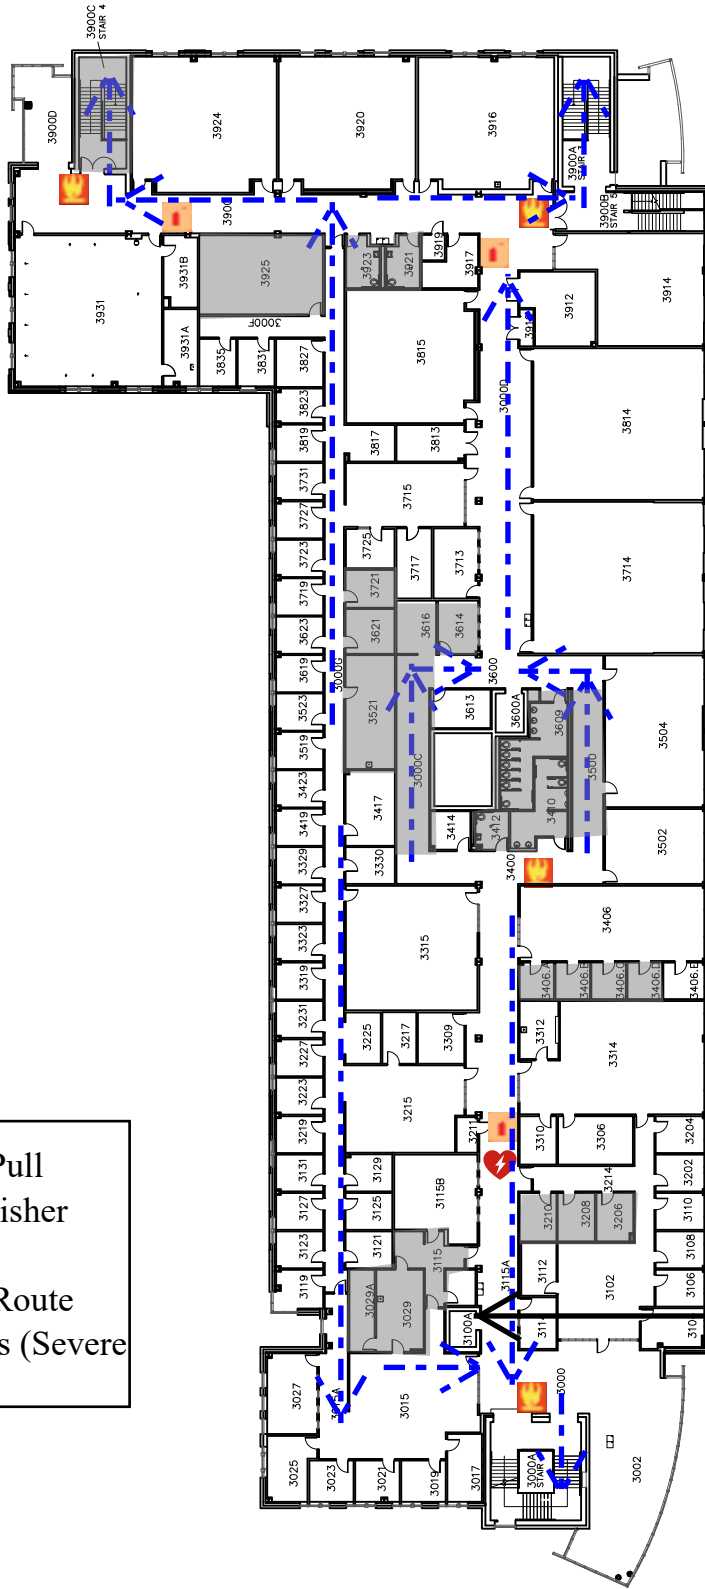
University of Wisconsin-Eau Claire Facilities Planning

# Centennial Hall Third Floor Plan

DATE:  
Oct 2021  
DWG NO:  
1



-  Fire Alarm Pull
-  Fire Extinguisher
-  AED
-  Evacuation Route
-  Shelter Areas (Severe Weather)



You Are Here




University of Wisconsin-Eau Claire Facilities Planning

# Centennial Hall Third Floor Plan






DATE:  
Oct 2021  
DWG NO:  
2

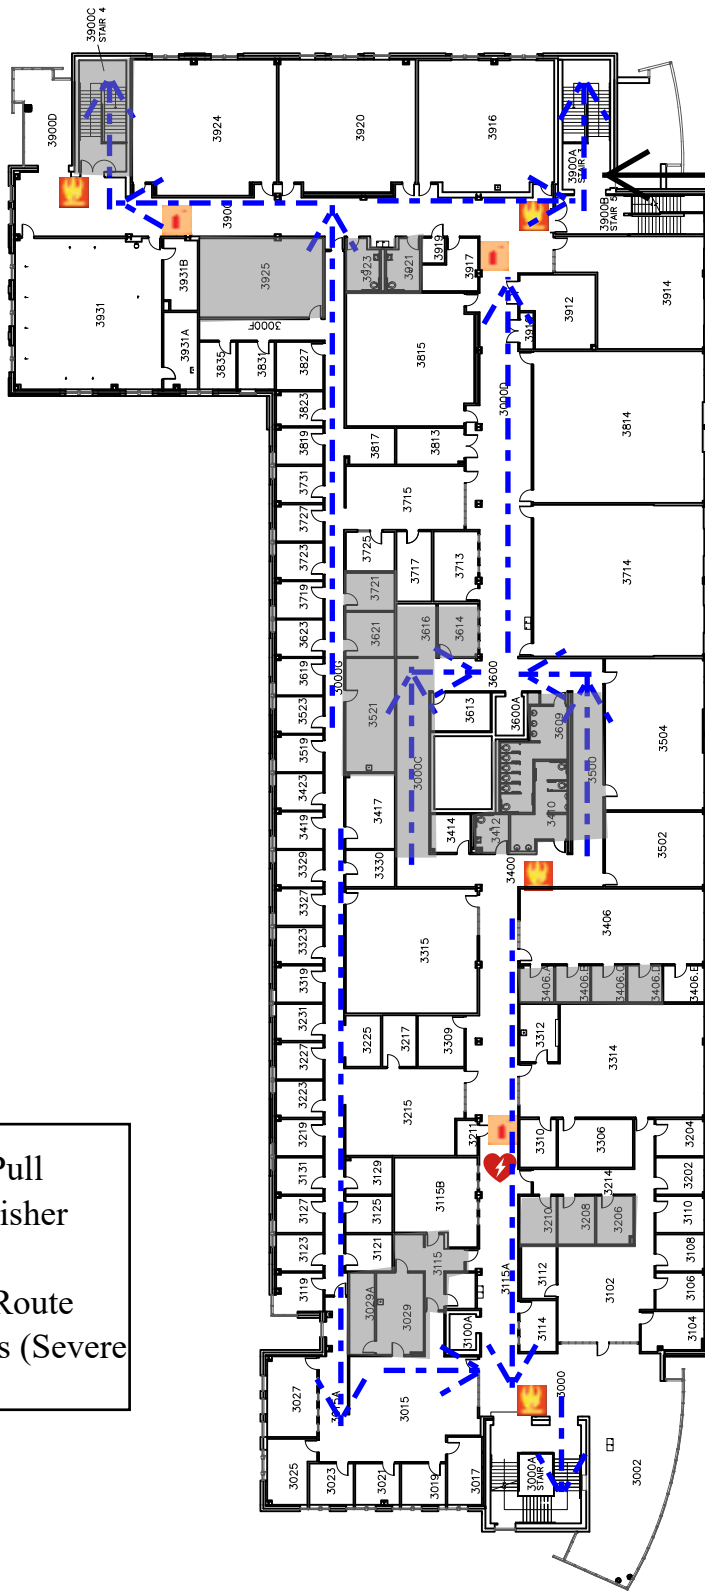





You Are Here

-  Fire Alarm Pull
-  Fire Extinguisher
-  AED
-  Evacuation Route
-  Shelter Areas (Severe Weather)



University of Wisconsin-Eau Claire Facilities Planning

# Centennial Hall Third Floor Plan

DATE:

Oct 2021

DWG NO:

3



You Are Here



 
	Fire Alarm Pull
	Fire Extinguisher
	AED
	Evacuation Route
	Shelter Areas (Severe Weather)







University of Wisconsin-Eau Claire Facilities Planning

# Centennial Hall Third Floor Plan

DATE:  
Oct 2021  
DWG NO:  
4





-  Fire Alarm Pull
-  Fire Extinguisher
-  Evacuation Route
-  Shelter Areas (Severe Weather)

You Are Here







University of Wisconsin-Eau Claire Facilities Planning

# Centennial Hall Four Floor Plan

DATE:	Oct 2021
DWG NO:	1





-  Fire Alarm Pull
-  Fire Extinguisher
-  Evacuation Route
-  Shelter Areas (Severe Weather)

 
You Are Here



University of Wisconsin-Eau Claire Facilities Planning





# Centennial Hall Four Floor Plan

DATE: Oct 2021
DWG NO: 2





You Are Here

-  Fire Alarm Pull
-  Fire Extinguisher
-  Evacuation Route
-  Shelter Areas (Severe Weather)




University of Wisconsin-Eau Claire Facilities Planning





# Centennial Hall Four Floor Plan

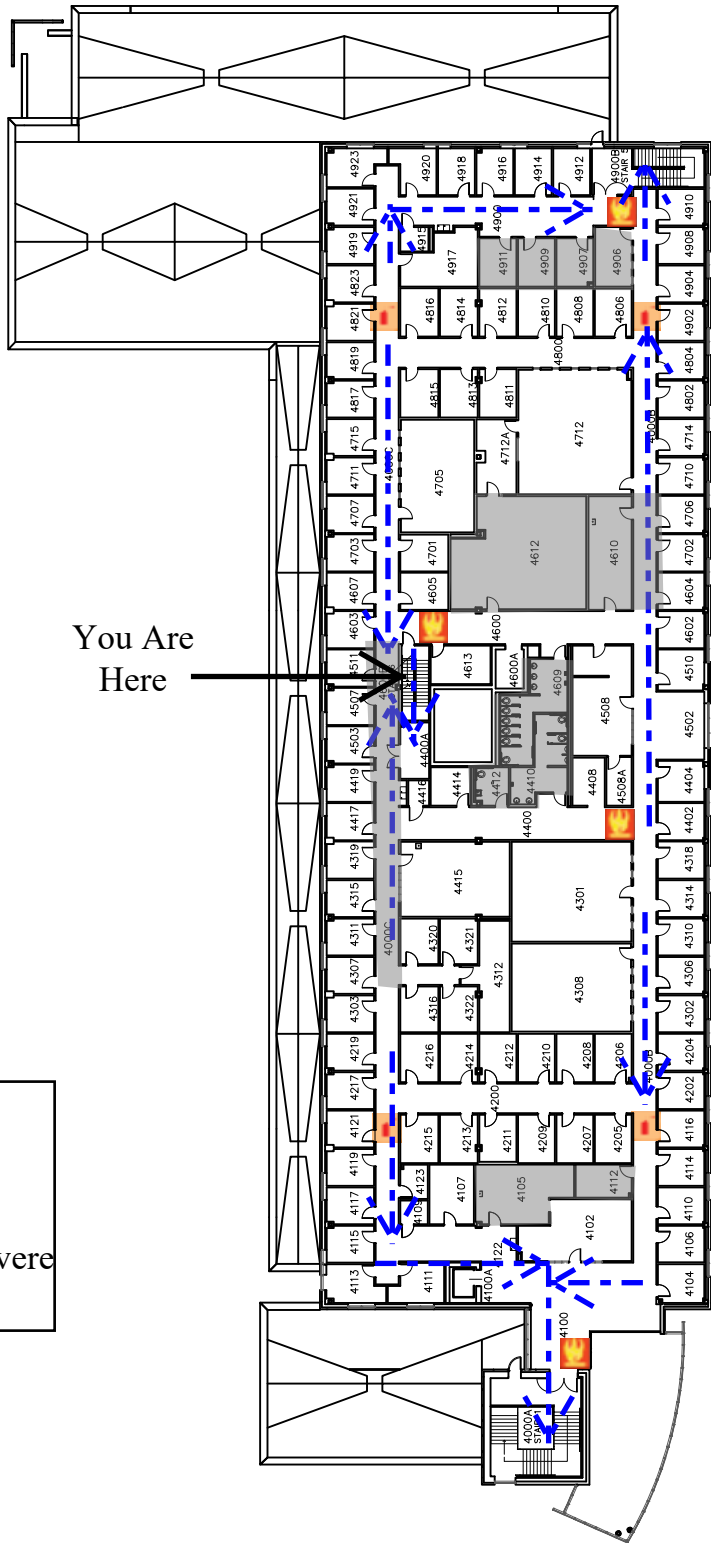DATE:	Oct 2021
DWG NO:	3





You Are Here

 
-  Fire Alarm Pull
-  Fire Extinguisher
-  Evacuation Route
-  Shelter Areas (Severe Weather)




University of Wisconsin-Eau Claire Facilities Planning




# Centennial Hall Four Floor Plan


DATE:  
Oct 2021  
DWG NO:  
4

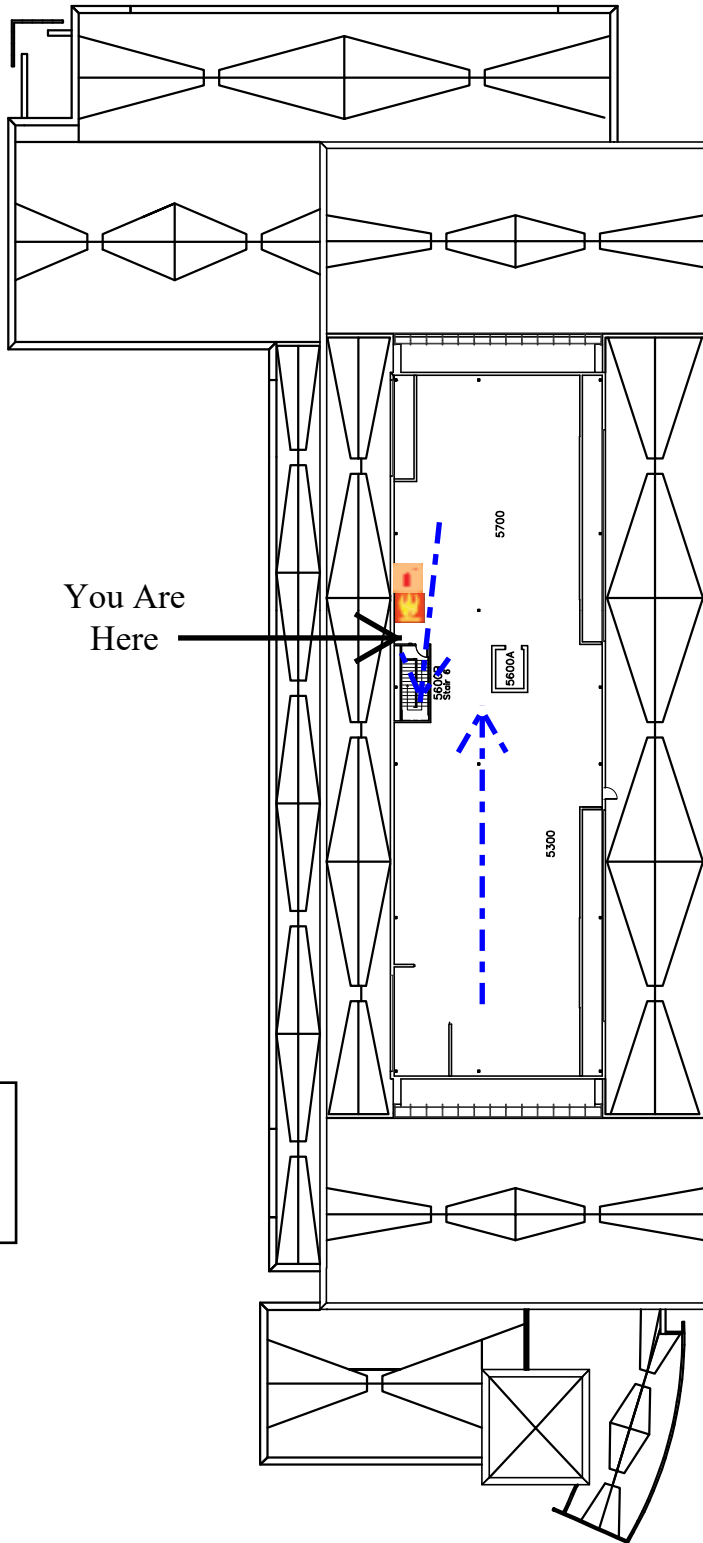



You Are Here

	Fire Alarm Pull
	Fire Extinguisher
	Evacuation Route

	University of Wisconsin-Eau Claire Facilities Planning	DATE: Oct 2021
	<b>Centennial Hall Fifth Floor Plan</b>	
		DWG NO: 1

