


 Fire Alarm Pull
 Fire Extinguisher
 Evacuation Route
 Shelter Areas (Severe Weather)

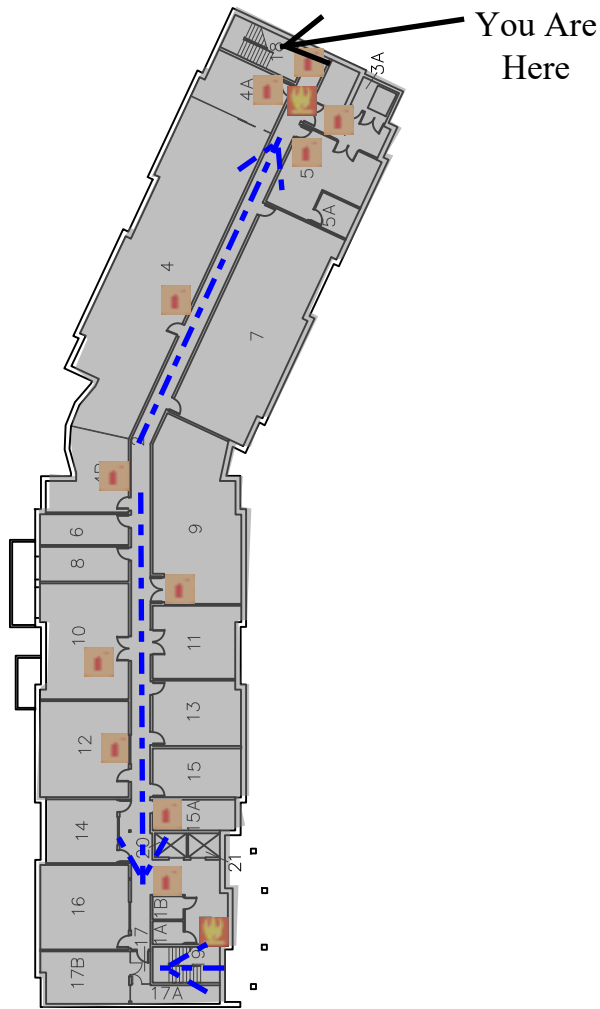

Assembly Point- Chancellors
Parking Lot



University of Wisconsin-Eau Claire


Facilities Planning

Chancellors Hall
Basement Floor Plan

DATE:
Aug. 2021
DWG NO:
1



 Fire Alarm Pull
 Fire Extinguisher
 Evacuation Route
 Shelter Areas (Severe Weather)

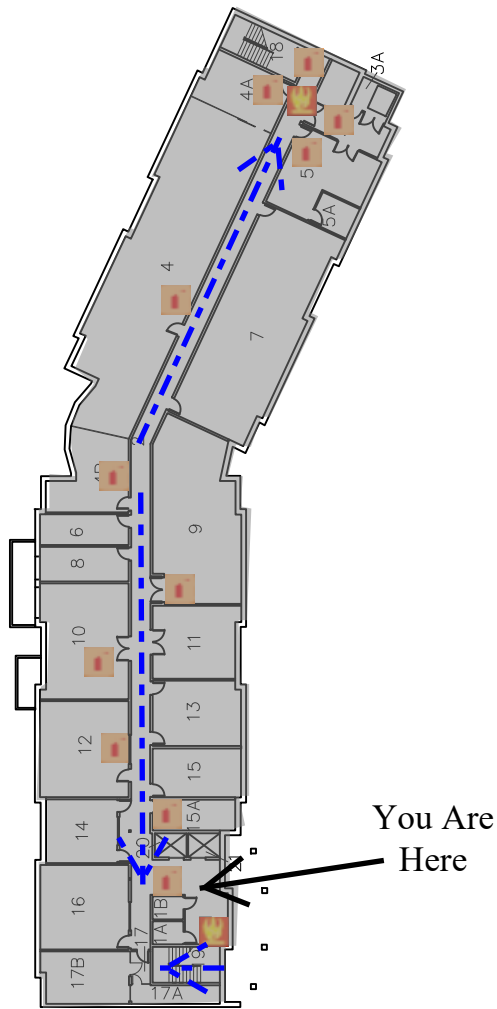

Assembly Point- Chancellors
Parking Lot



University of Wisconsin-Eau Claire


Facilities Planning

Chancellors Hall Basement Floor Plan

DATE:
Aug. 2021
DWG NO:
2



 Fire Alarm Pull
 Fire Extinguisher
 AED
 Evacuation Route

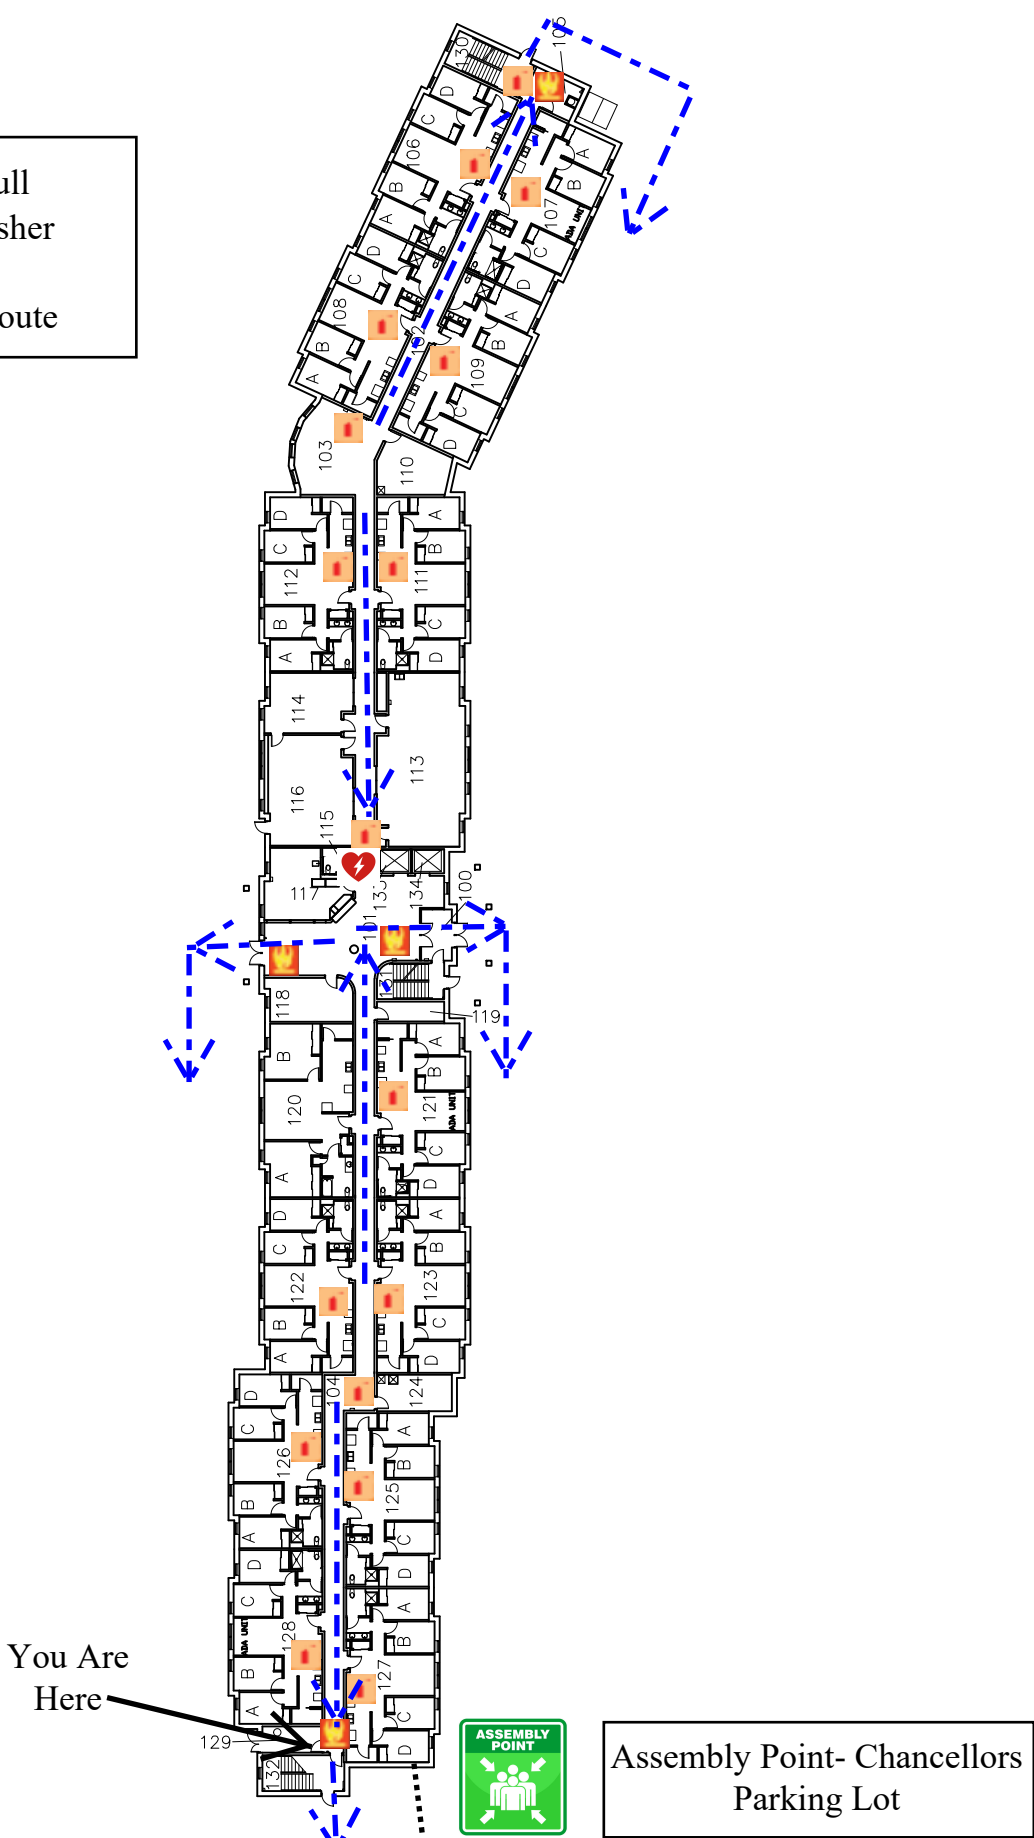

University of Wisconsin-Eau Claire

Facilities Planning

DATE:
Aug. 2021
DWG NO:
1

Chancellors Hall First Floor Plan



 Fire Alarm Pull
 Fire Extinguisher
 AED
 Evacuation Route



Assembly Point- Chancellors
Parking Lot



University of Wisconsin-Eau Claire


Facilities Planning

Chancellors Hall First Floor Plan

DATE:
Aug. 2021
DWG NO:
2



 Fire Alarm Pull
  Fire Extinguisher
  Evacuation Route

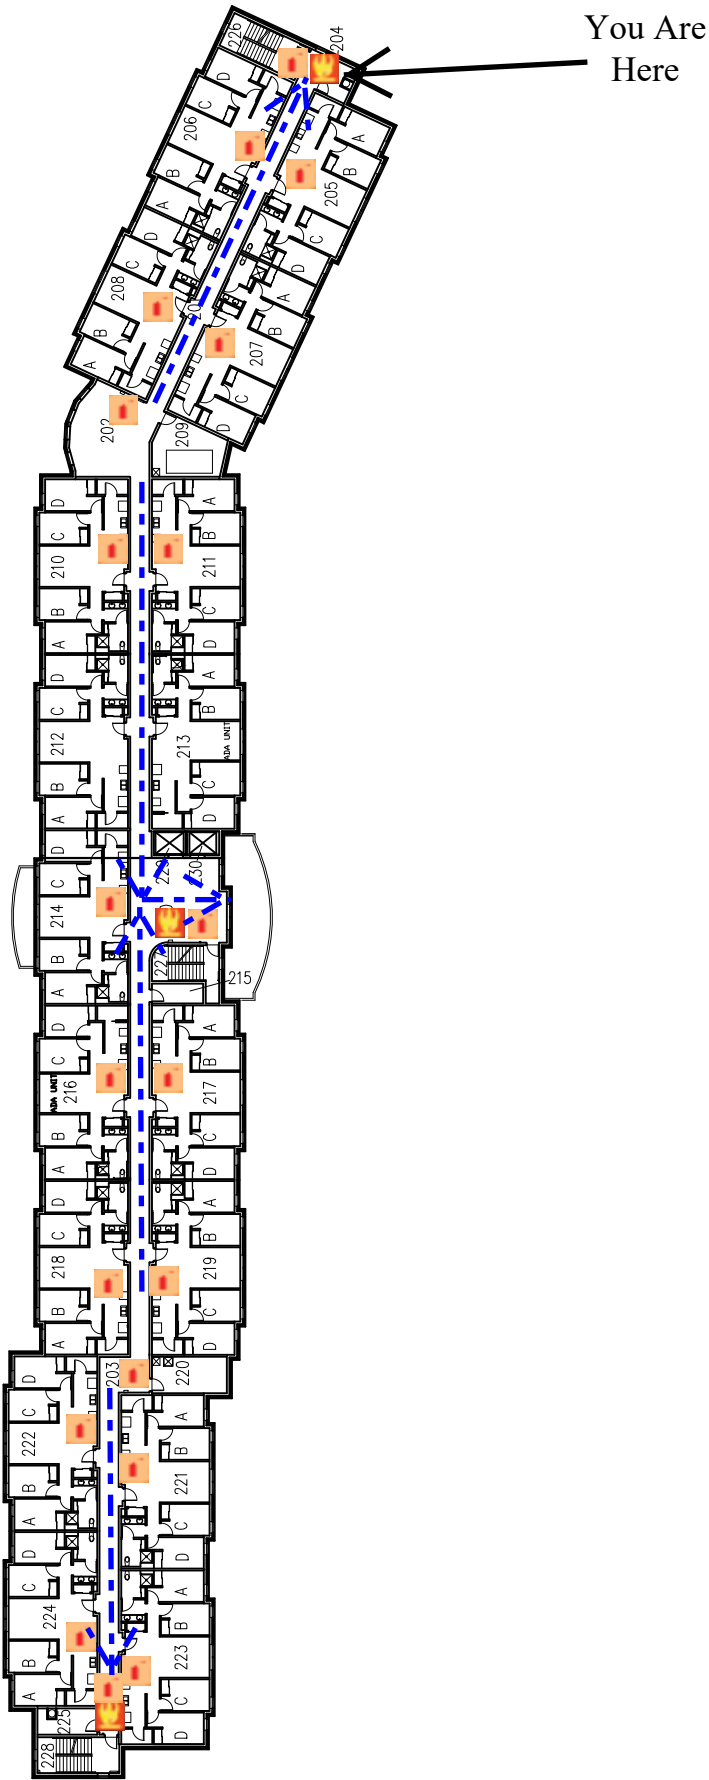

University of Wisconsin-Eau Claire

Facilities Planning

Chancellors Hall Second Floor Plan

DATE:


Aug. 2021

DWG NO:

1



 Fire Alarm Pull
  Fire Extinguisher
  Evacuation Route

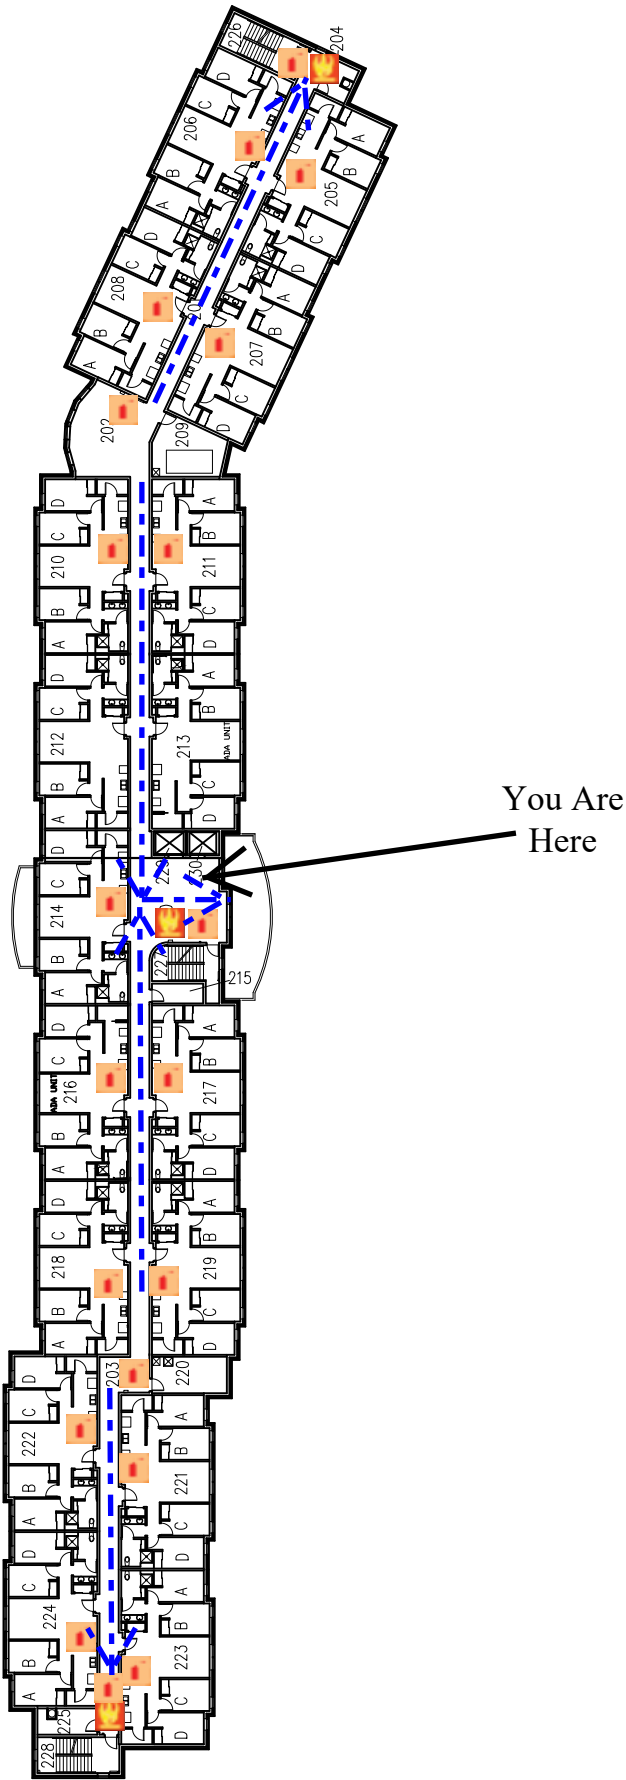

University of Wisconsin-Eau Claire

Facilities Planning

Chancellors Hall Second Floor Plan

DATE:


Aug. 2021

DWG NO:


2




 Fire Alarm Pull
 Fire Extinguisher
 Evacuation Route

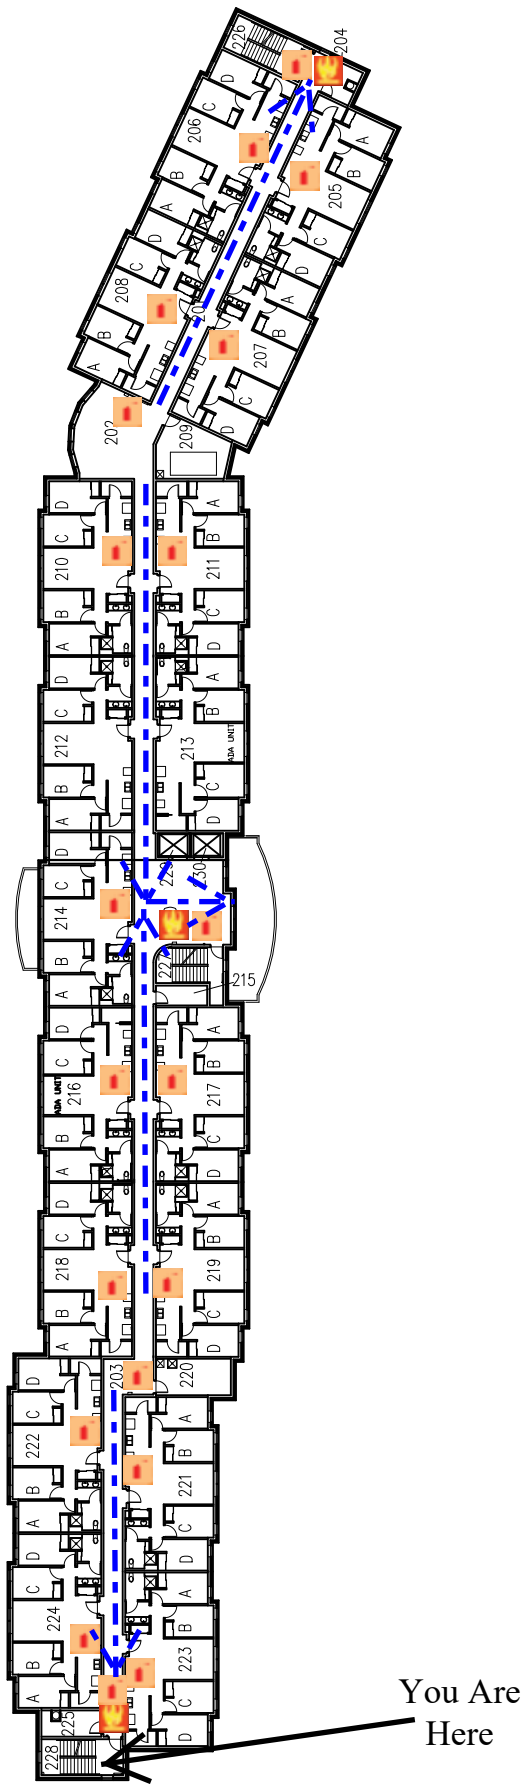


 Fire Alarm Pull
  Fire Extinguisher
  Evacuation Route

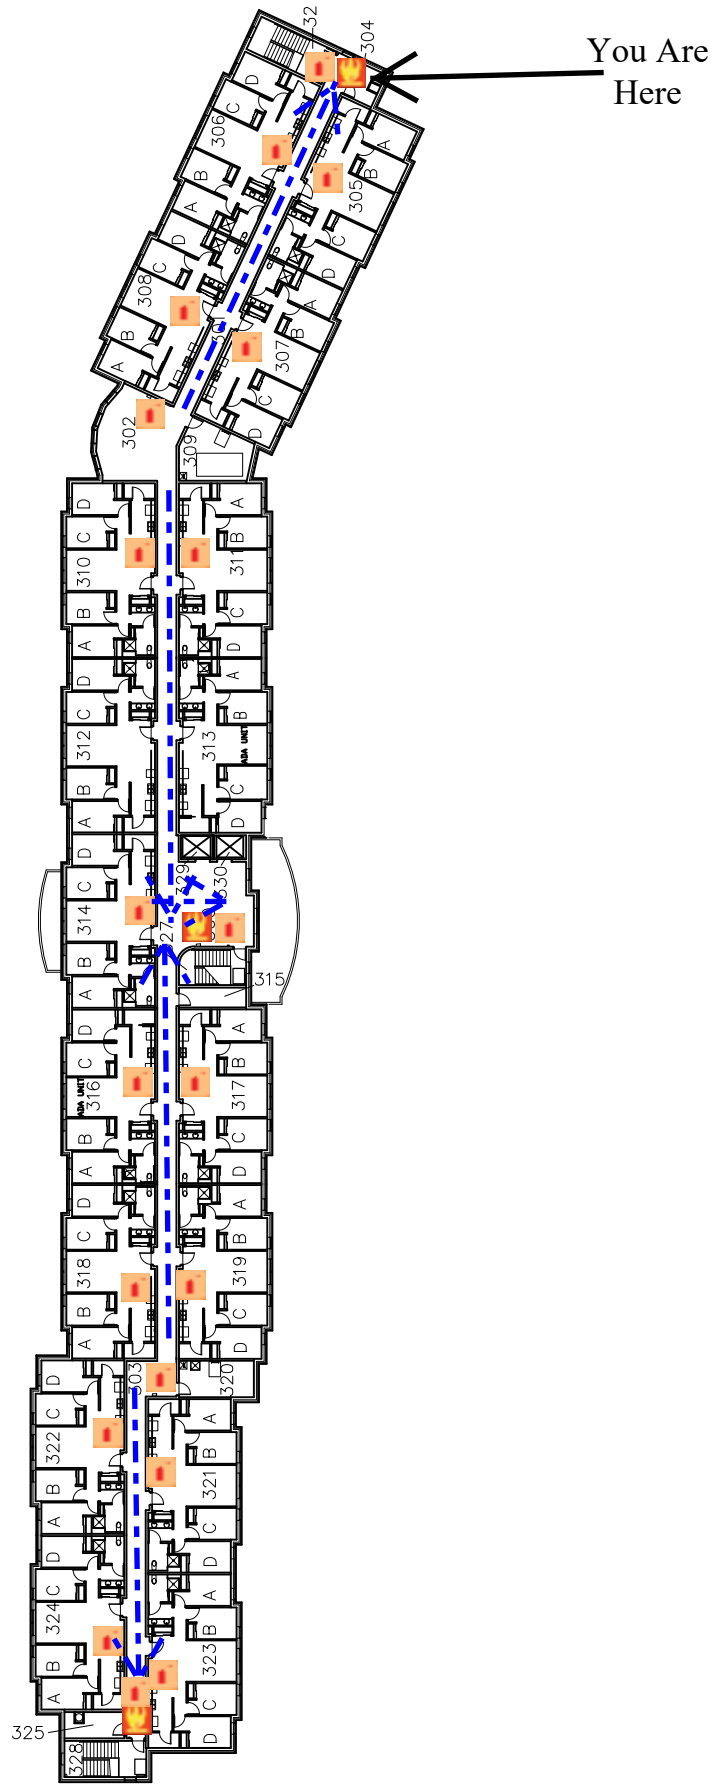


 Fire Alarm Pull
 Fire Extinguisher
 Evacuation Route

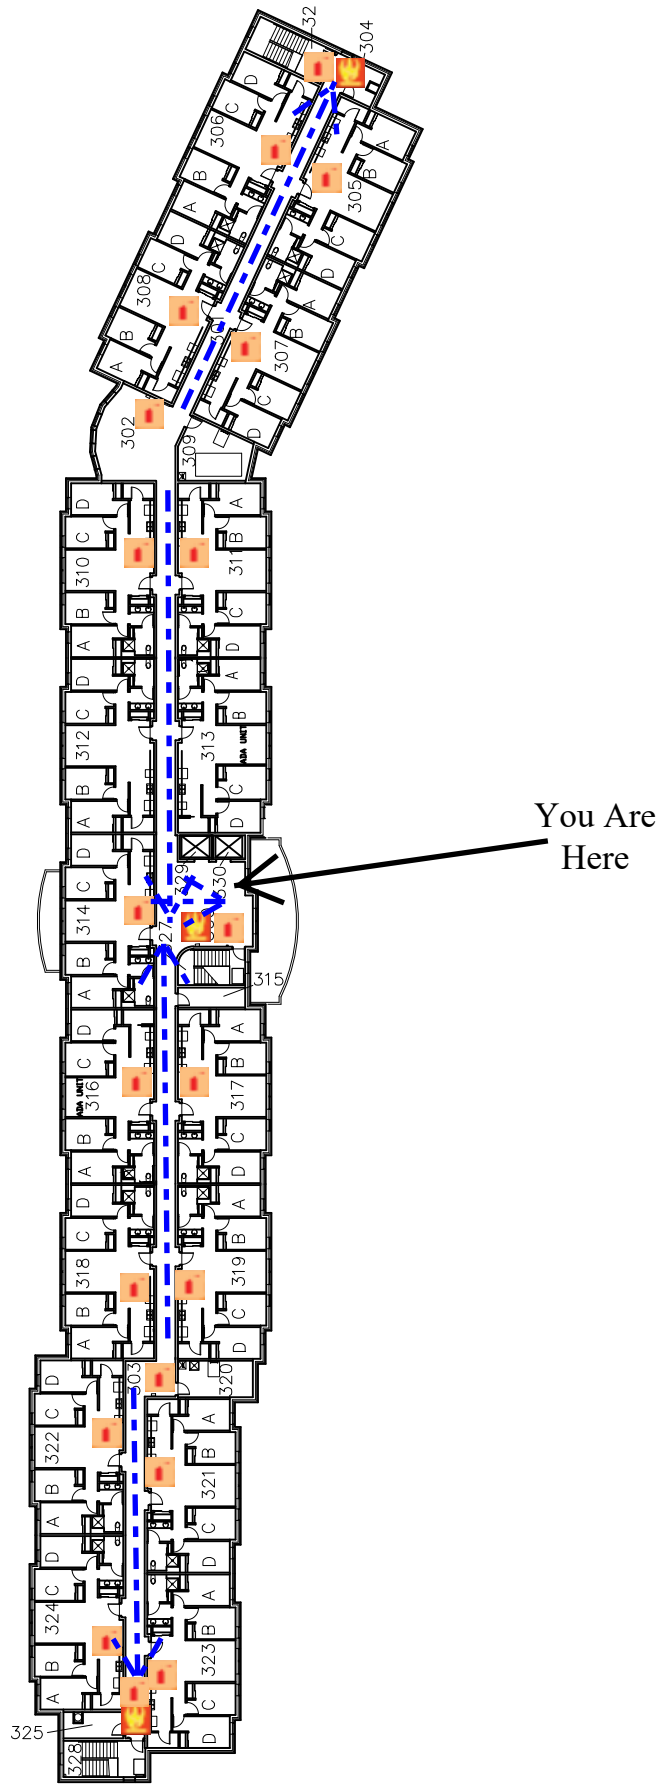

 Fire Alarm Pull
  Fire Extinguisher
  Evacuation Route

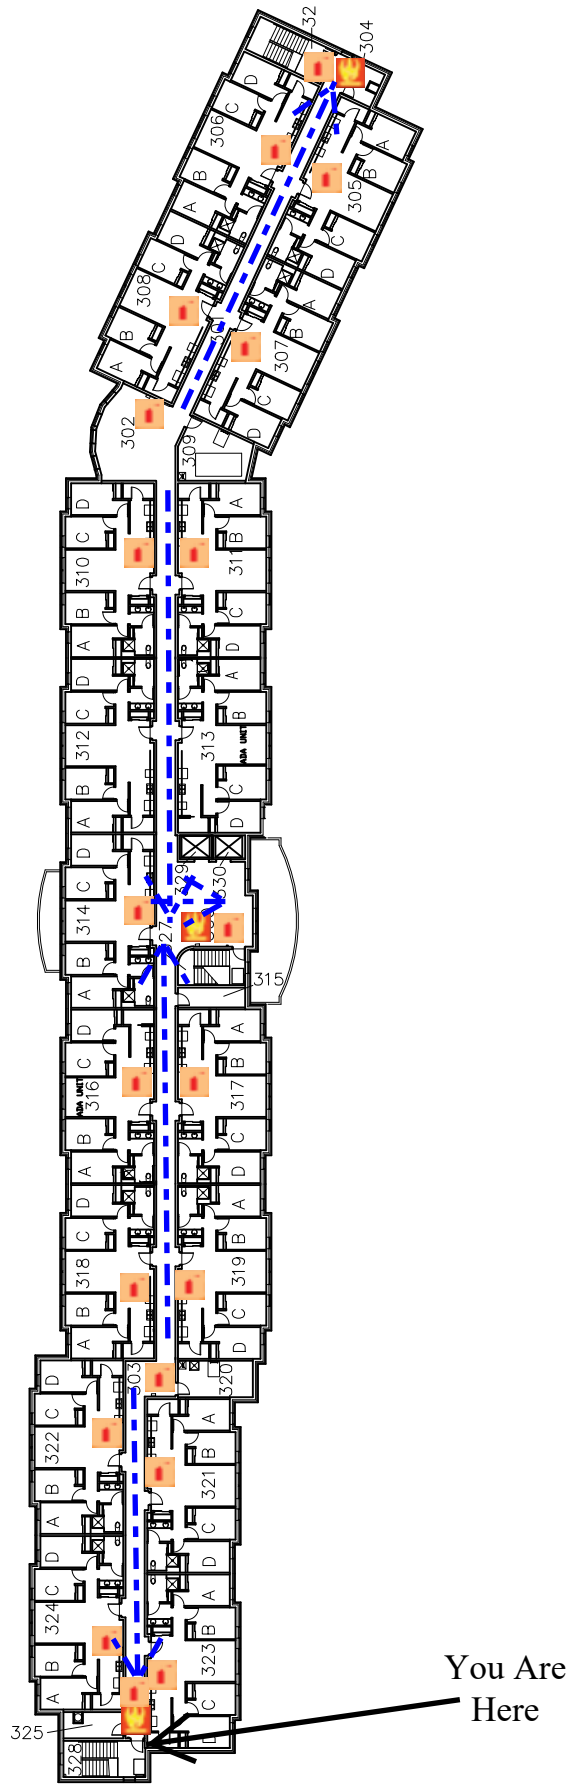

 Fire Alarm Pull
  Fire Extinguisher
  Evacuation Route

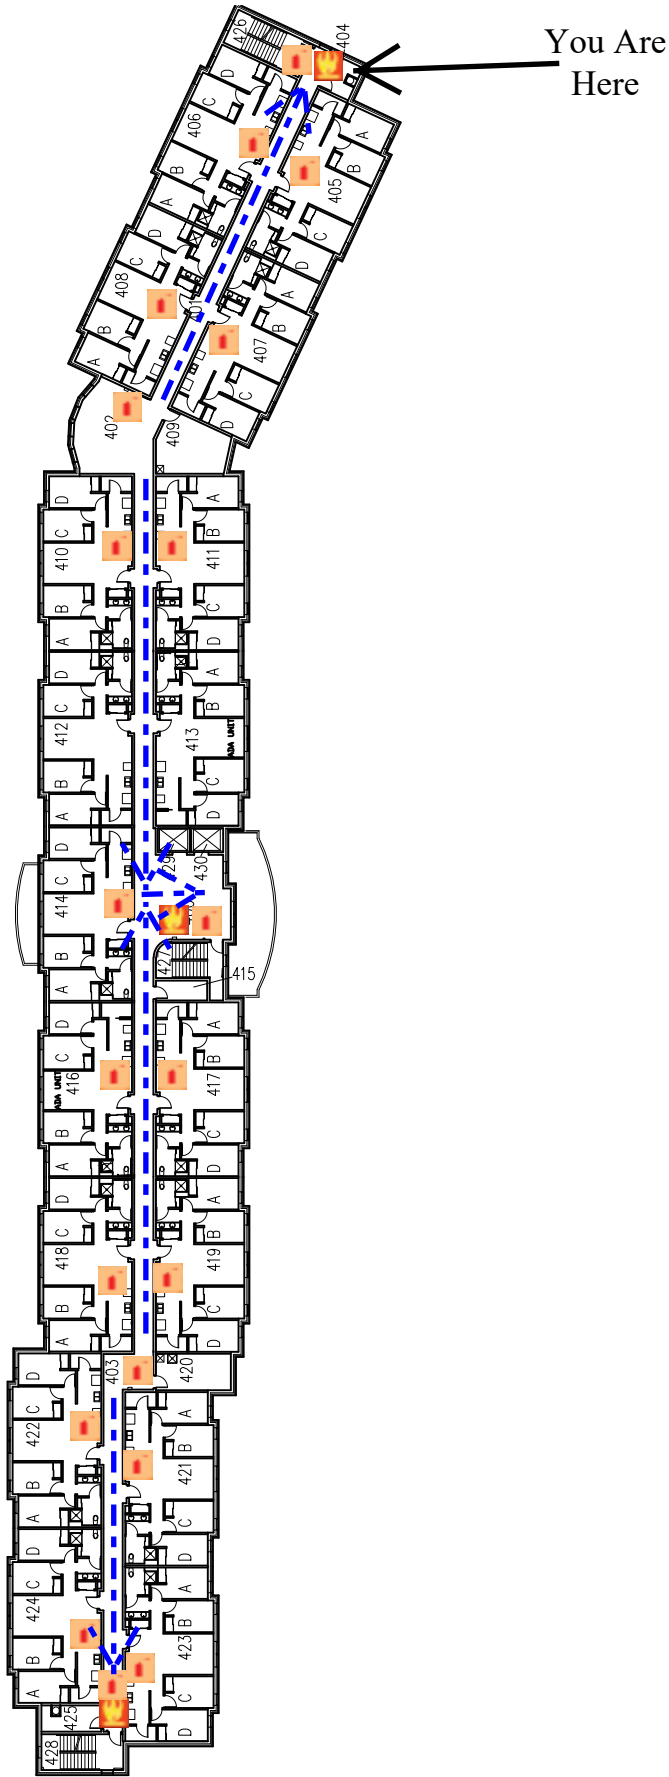

University of Wisconsin-Eau Claire

Facilities Planning


Chancellors Hall Fourth Floor Plan

DATE:
Aug. 2021

DWG NO:
1



 Fire Alarm Pull
 Fire Extinguisher
 Evacuation Route

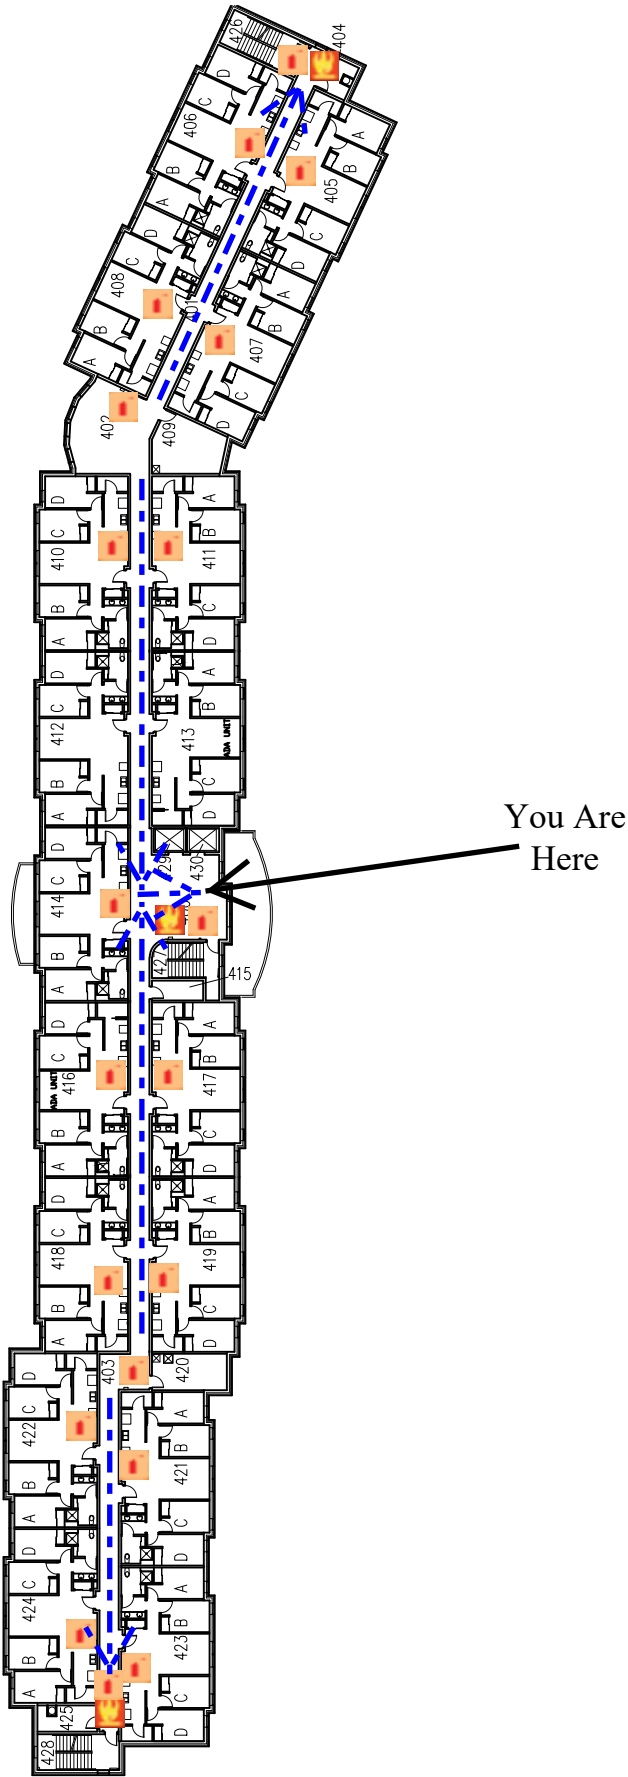

University of Wisconsin-Eau Claire

Facilities Planning


Chancellors Hall Fourth Floor Plan

DATE:
Aug. 2021

DWG NO:
2



 Fire Alarm Pull
 Fire Extinguisher
 Evacuation Route

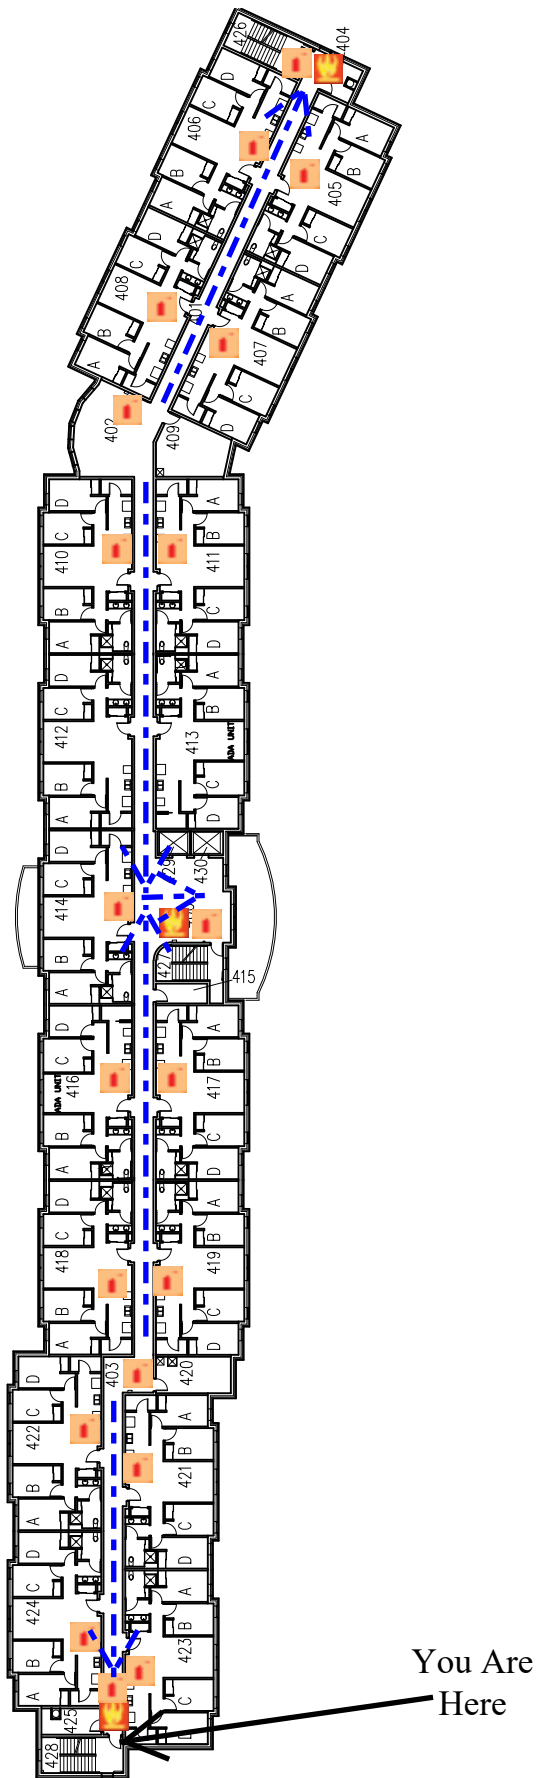

University of Wisconsin-Eau Claire

Facilities Planning


Chancellors Hall Fourth Floor Plan

DATE:
Aug. 2021

DWG NO:
3



 Fire Alarm Pull
 Fire Extinguisher
 Evacuation Route

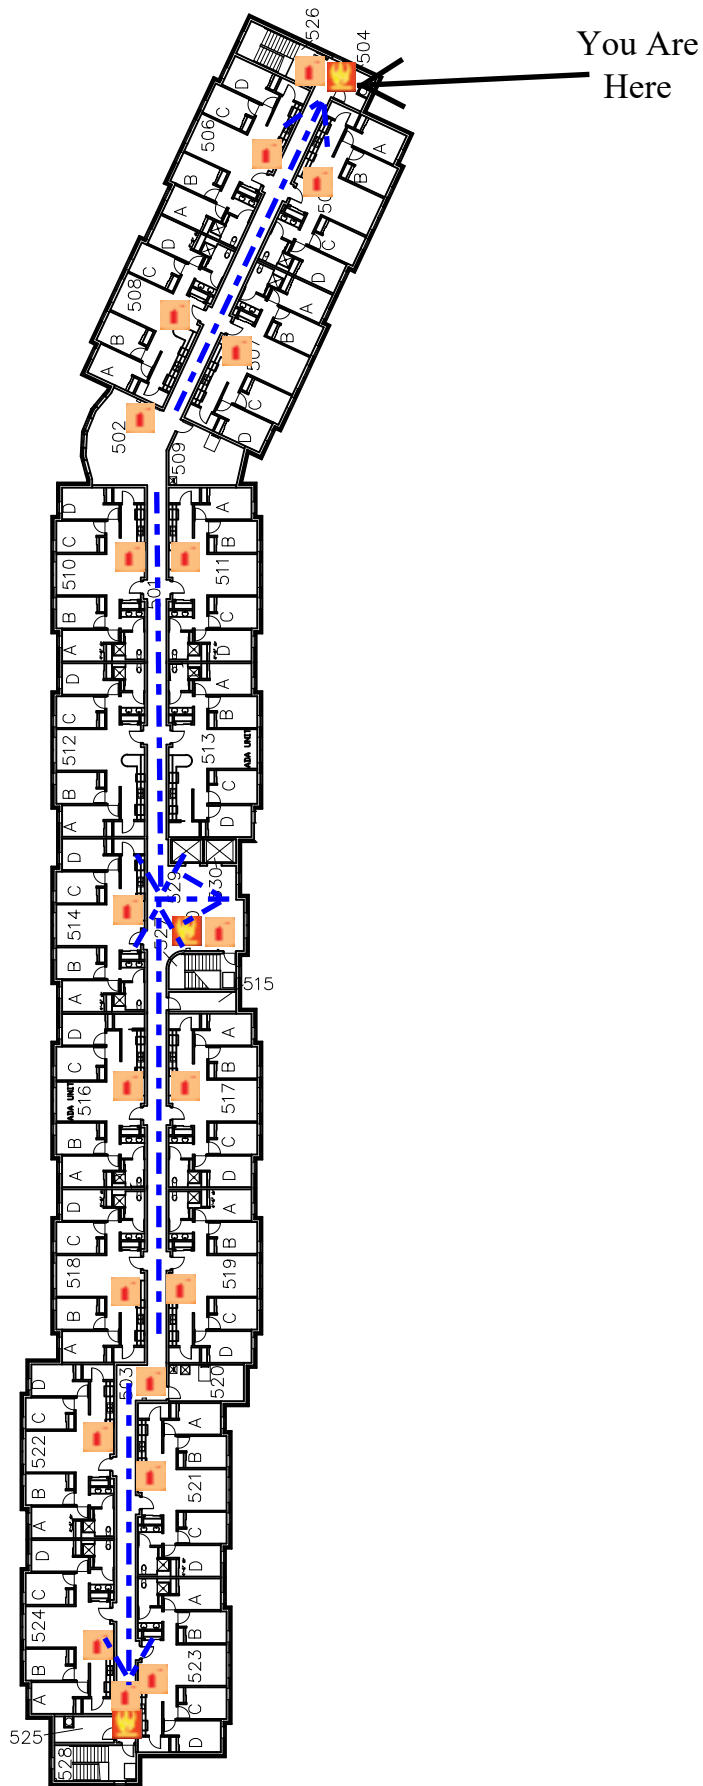

University of Wisconsin-Eau Claire

Facilities Planning

Chancellors Hall Fifth Floor Plan

DATE:


Aug. 2021

DWG NO:

1



 Fire Alarm Pull
  Fire Extinguisher
  Evacuation Route

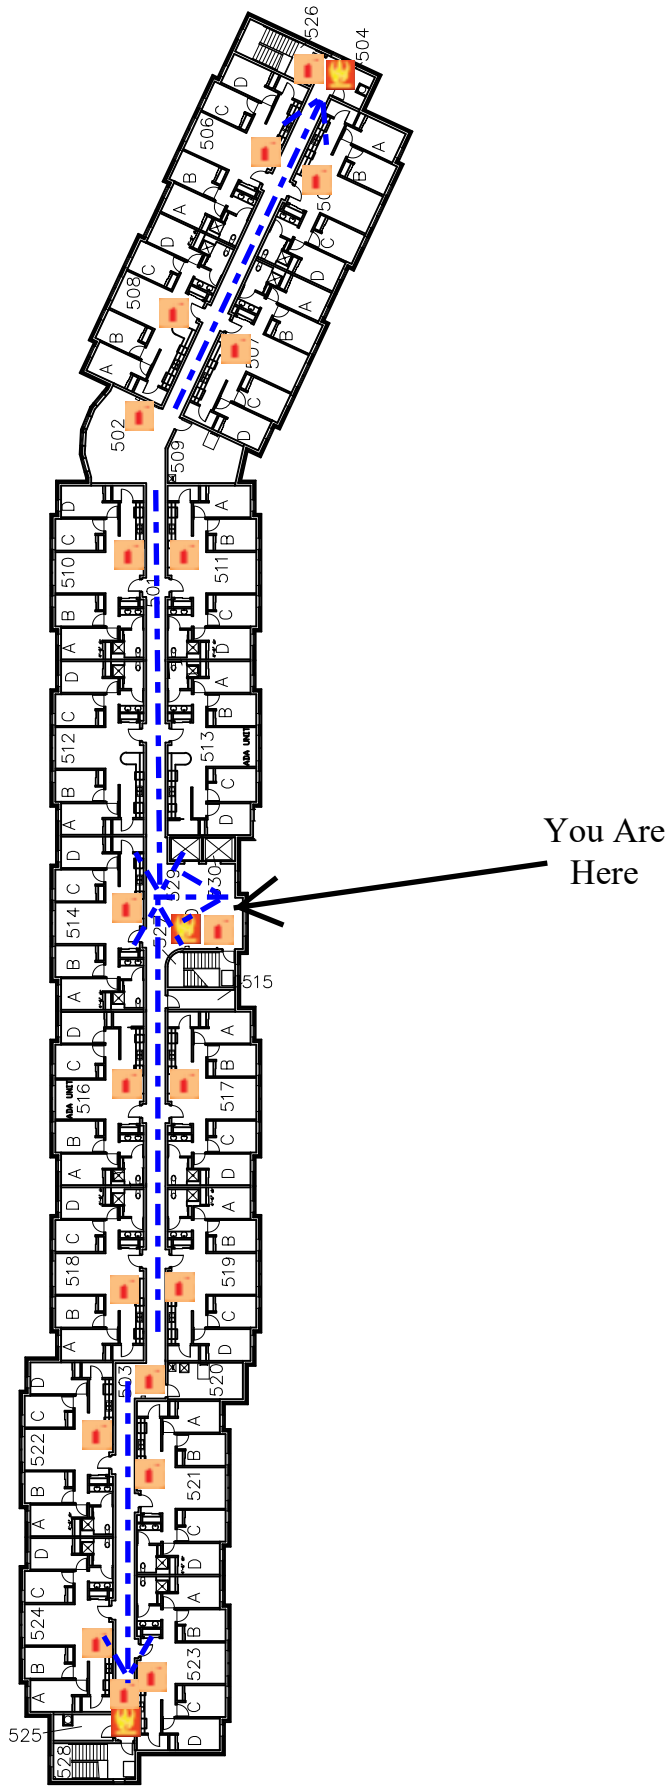

University of Wisconsin-Eau Claire


Facilities Planning

Chancellors Hall Fifth Floor Plan

DATE:
Aug. 2021
DWG NO:
2



 Fire Alarm Pull
 Fire Extinguisher
 Evacuation Route

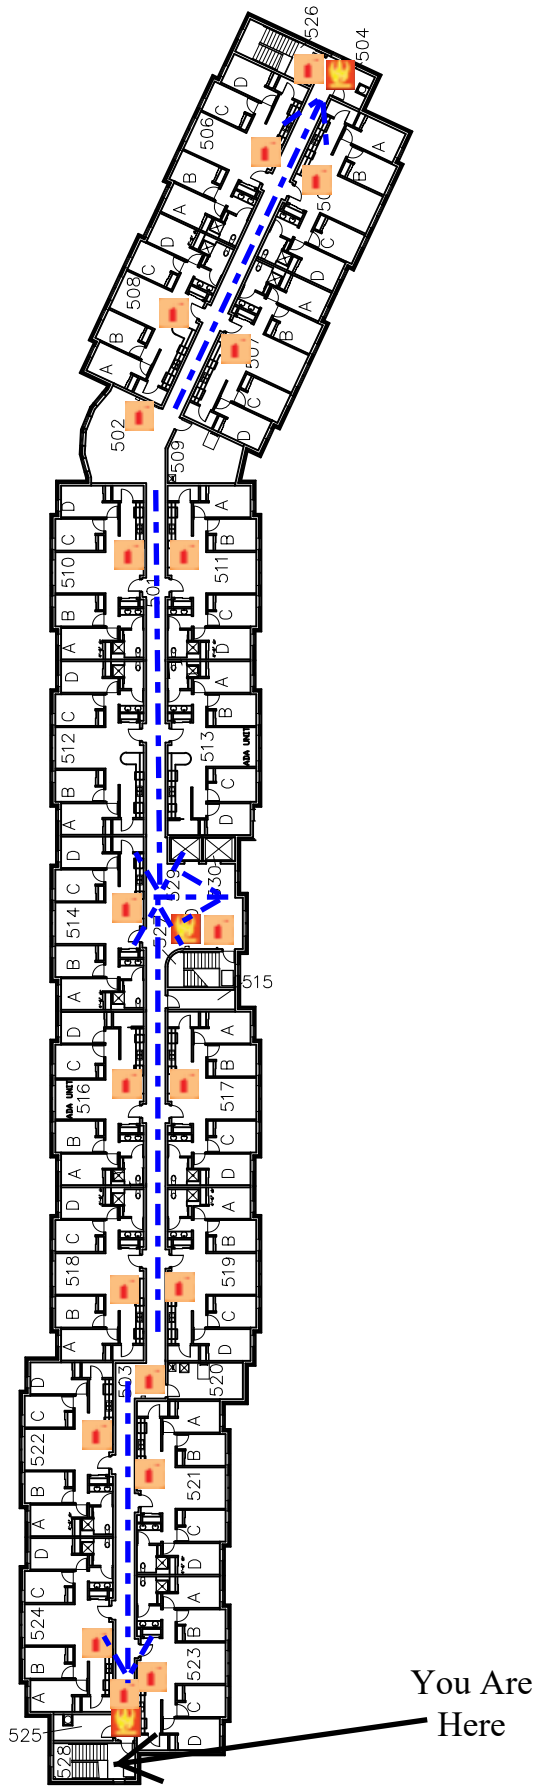

University of Wisconsin-Eau Claire

Facilities Planning

Chancellors Hall
Fifth Floor Plan

DATE:

Aug. 2021

DWG NO:

3

