




 Fire Alarm Pull
 Fire Extinguisher
 Evacuation Route
 Shelter Areas (Severe Weather)

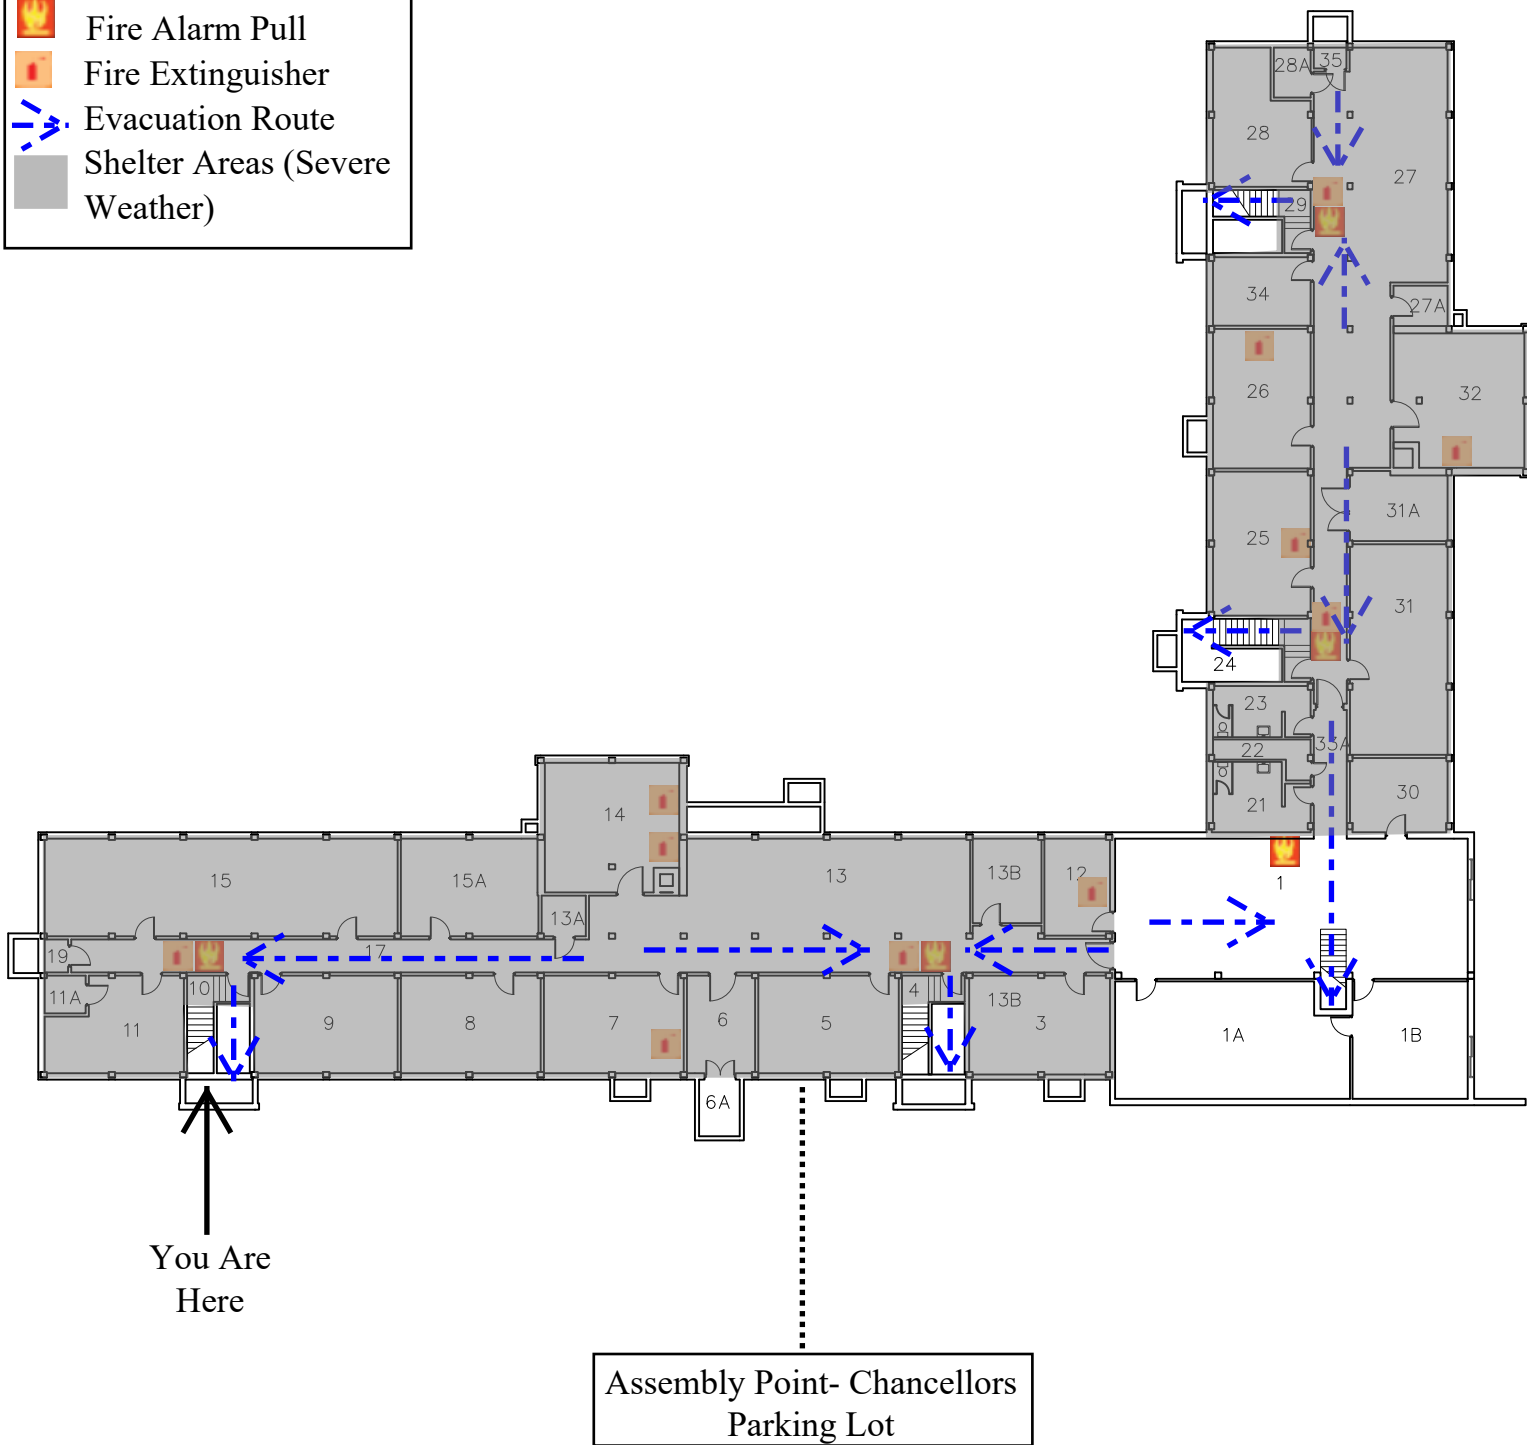

 Fire Alarm Pull
 Fire Extinguisher
 Evacuation Route
 Shelter Areas (Severe Weather)

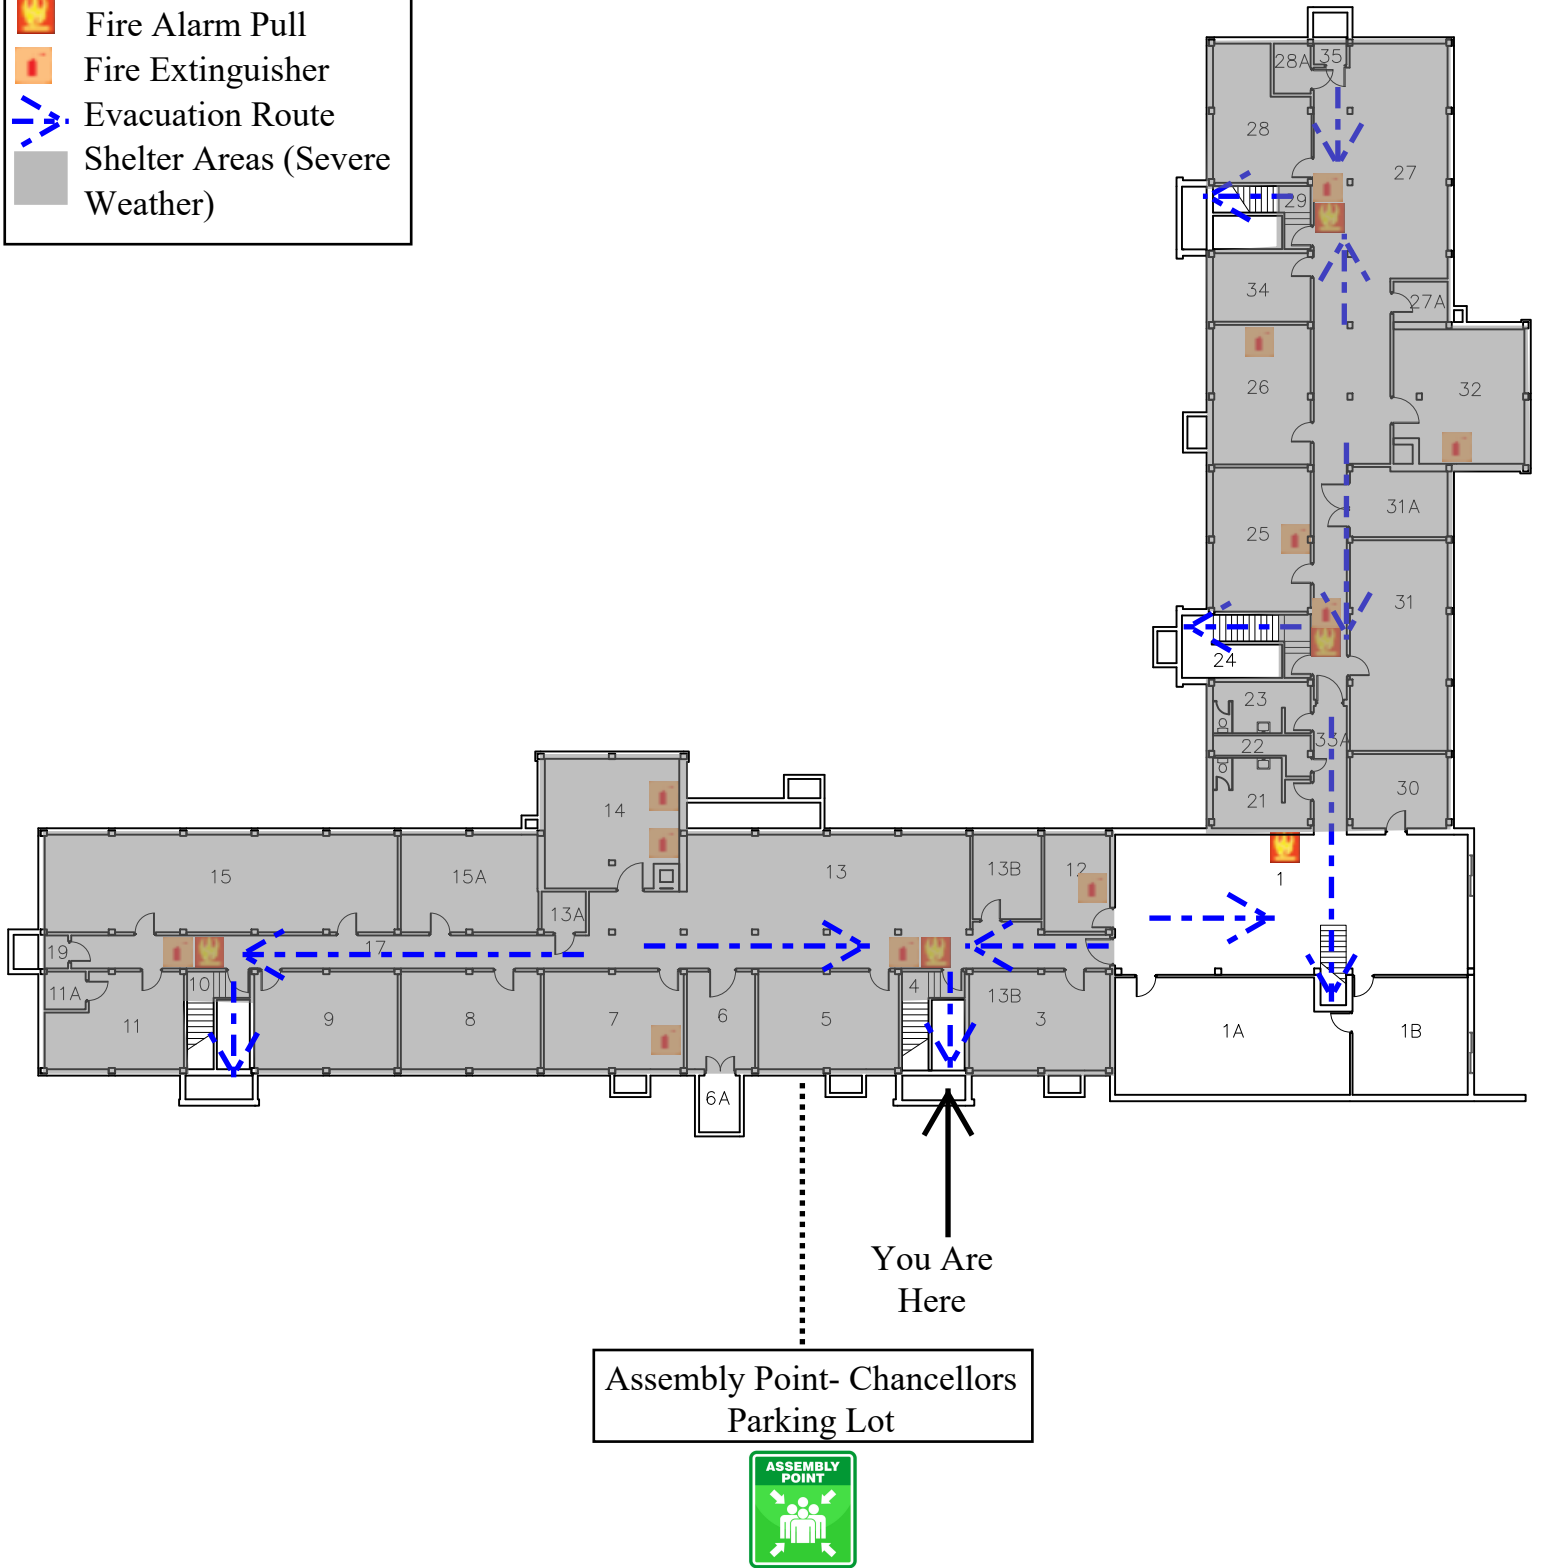

 Fire Alarm Pull
 Fire Extinguisher
 Evacuation Route
 Shelter Areas (Severe Weather)

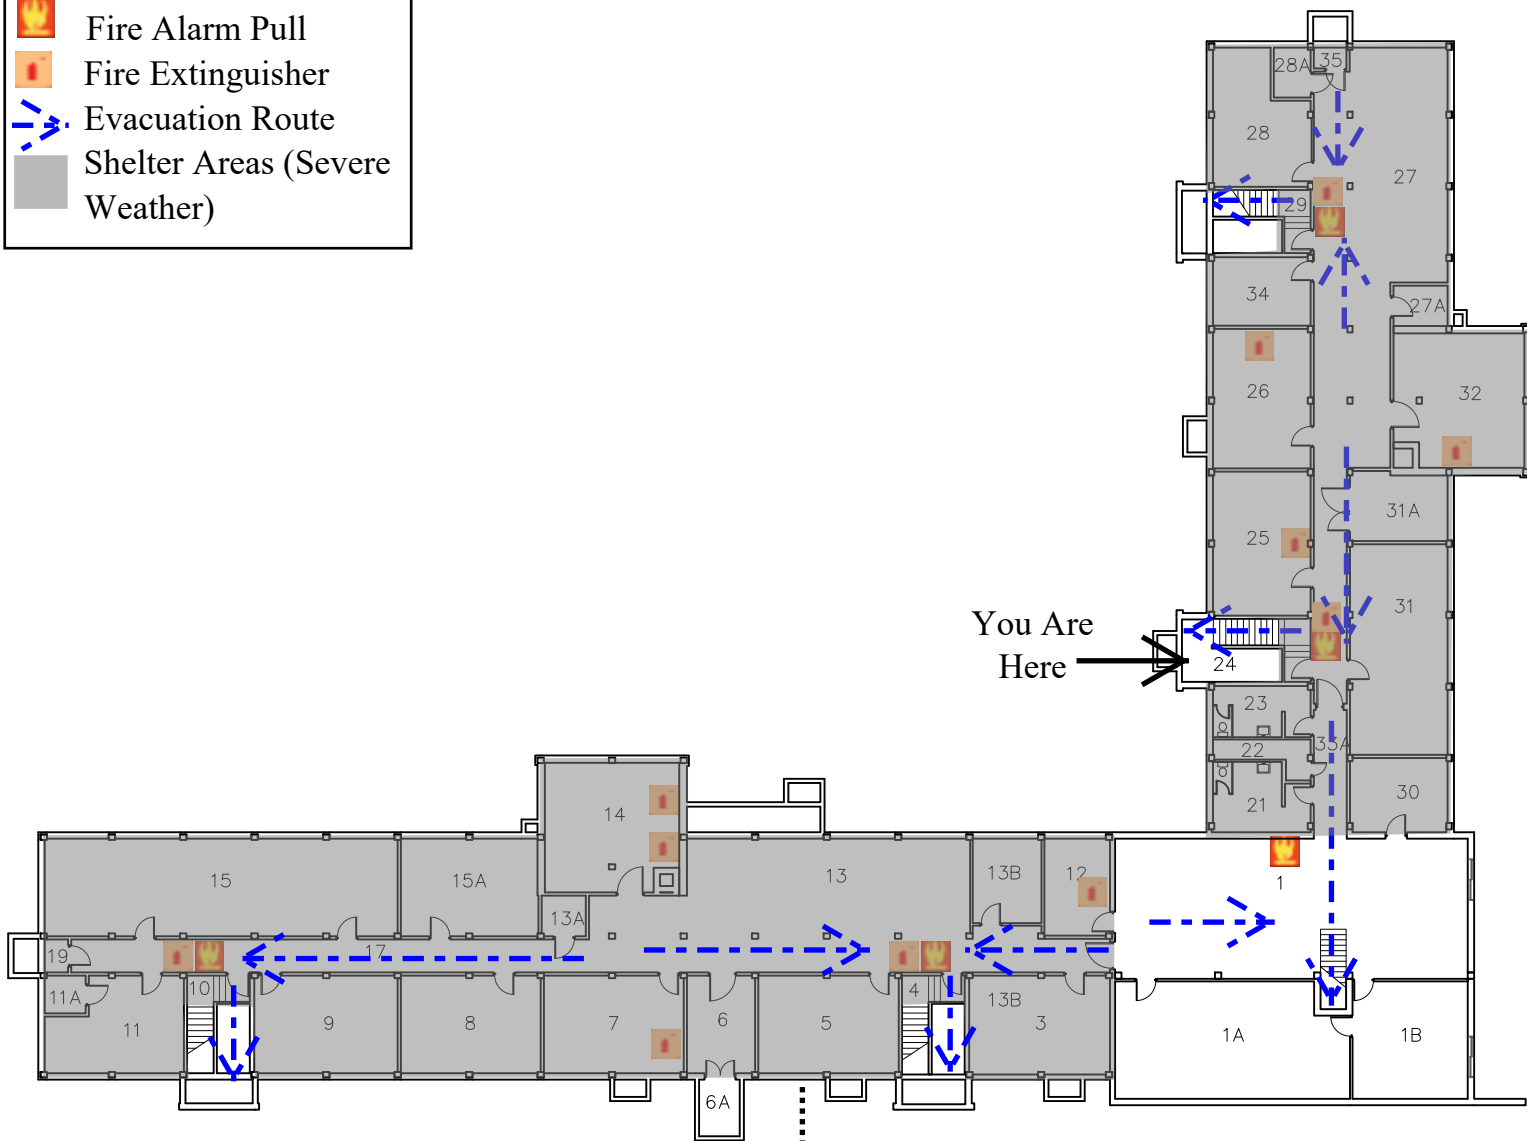


Assembly Point- Chancellors
Parking Lot



University of Wisconsin-Eau Claire	Facilities Planning	DATE: Aug. 2021
Governors Hall Basement Floor Plan		DWG NO: 3



 Fire Alarm Pull
 Fire Extinguisher
 Evacuation Route
 Shelter Areas (Severe Weather)

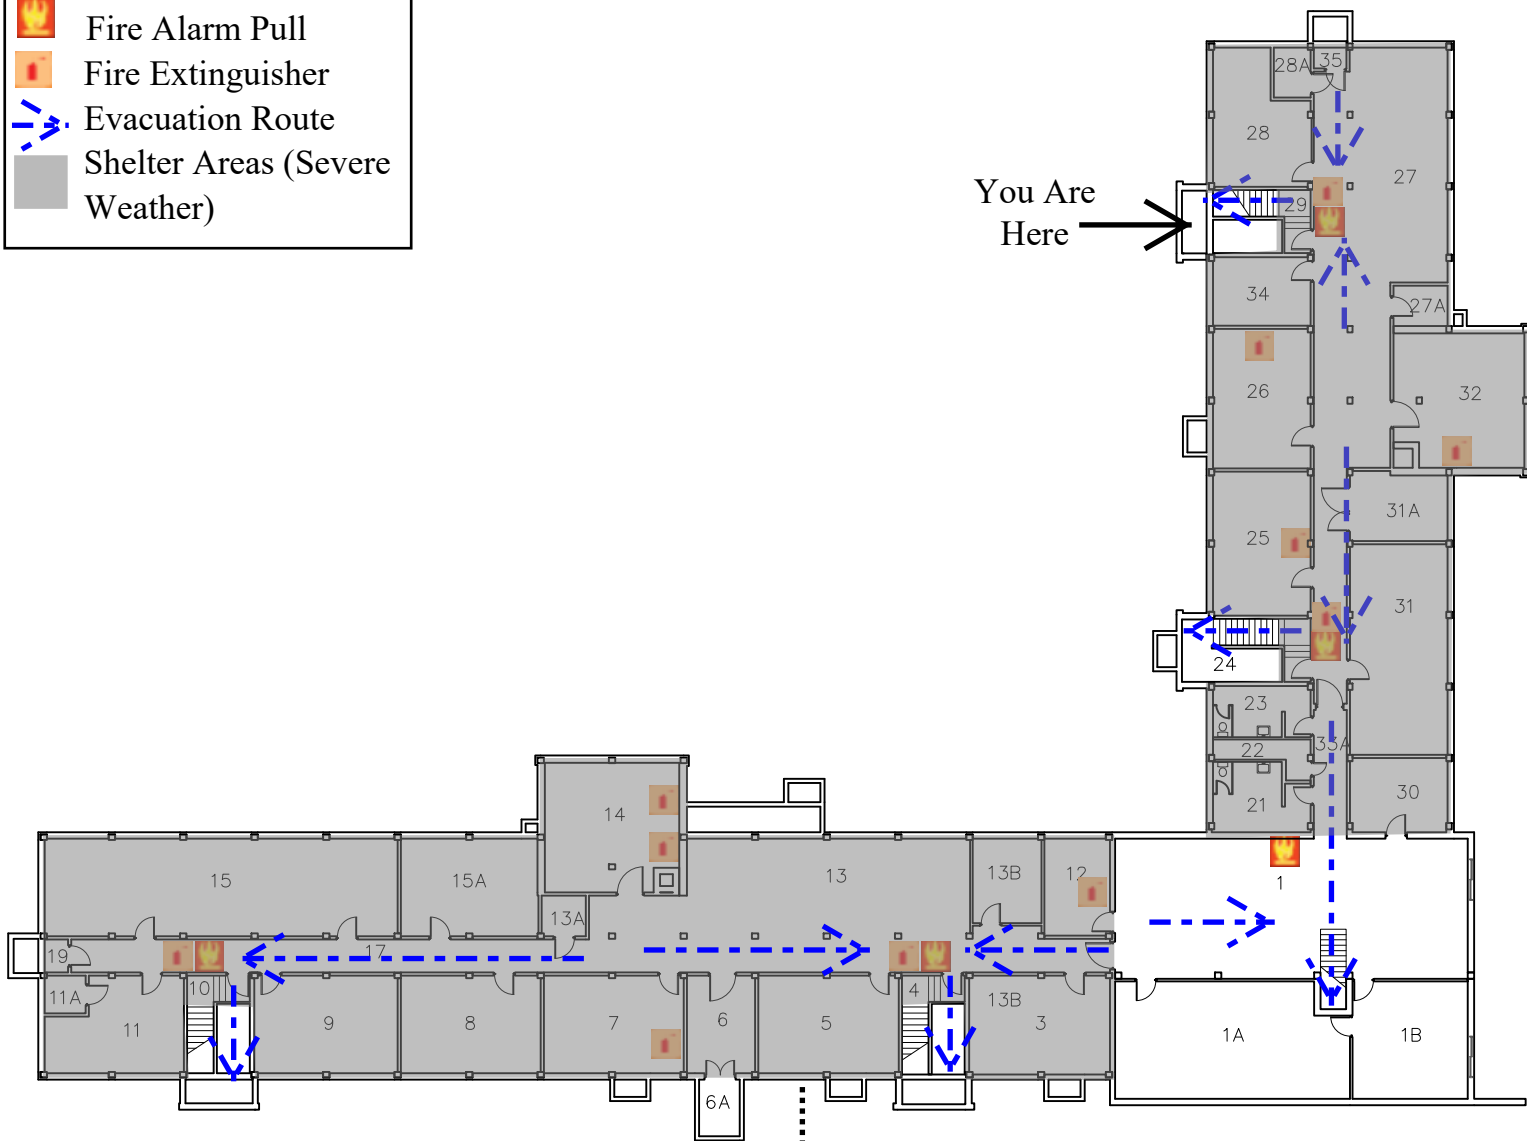

Assembly Point- Chancellors
Parking Lot



University of Wisconsin-Eau Claire

Facilities Planning


Governors Hall
Basement Floor Plan

DATE:
Aug. 2021


DWG NO:
4



 Fire Alarm Pull
 Fire Extinguisher
 Evacuation Route
 Shelter Areas (Severe Weather)

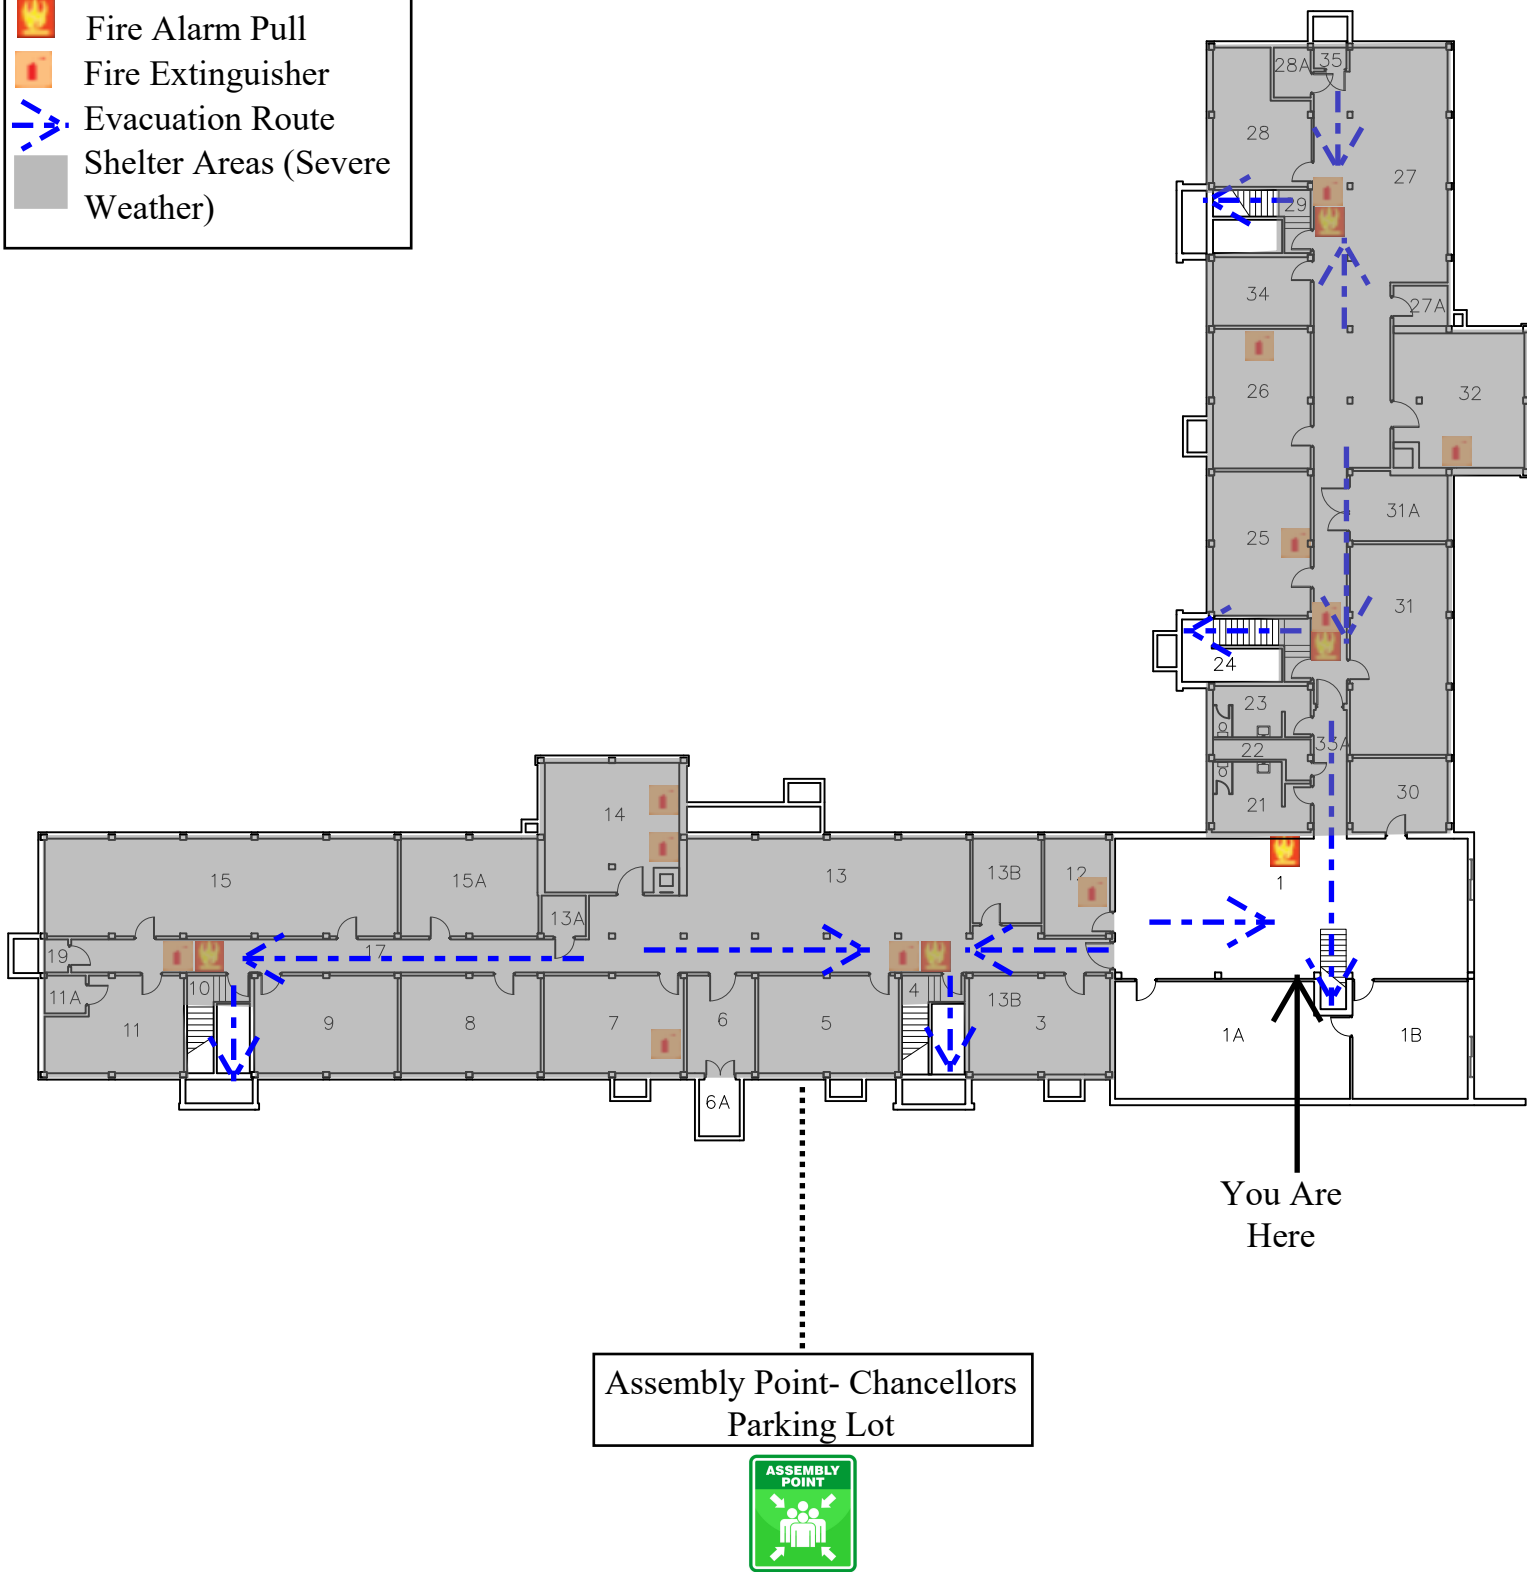

 Fire Alarm Pull
 Fire Extinguisher
 AED
 Evacuation Route

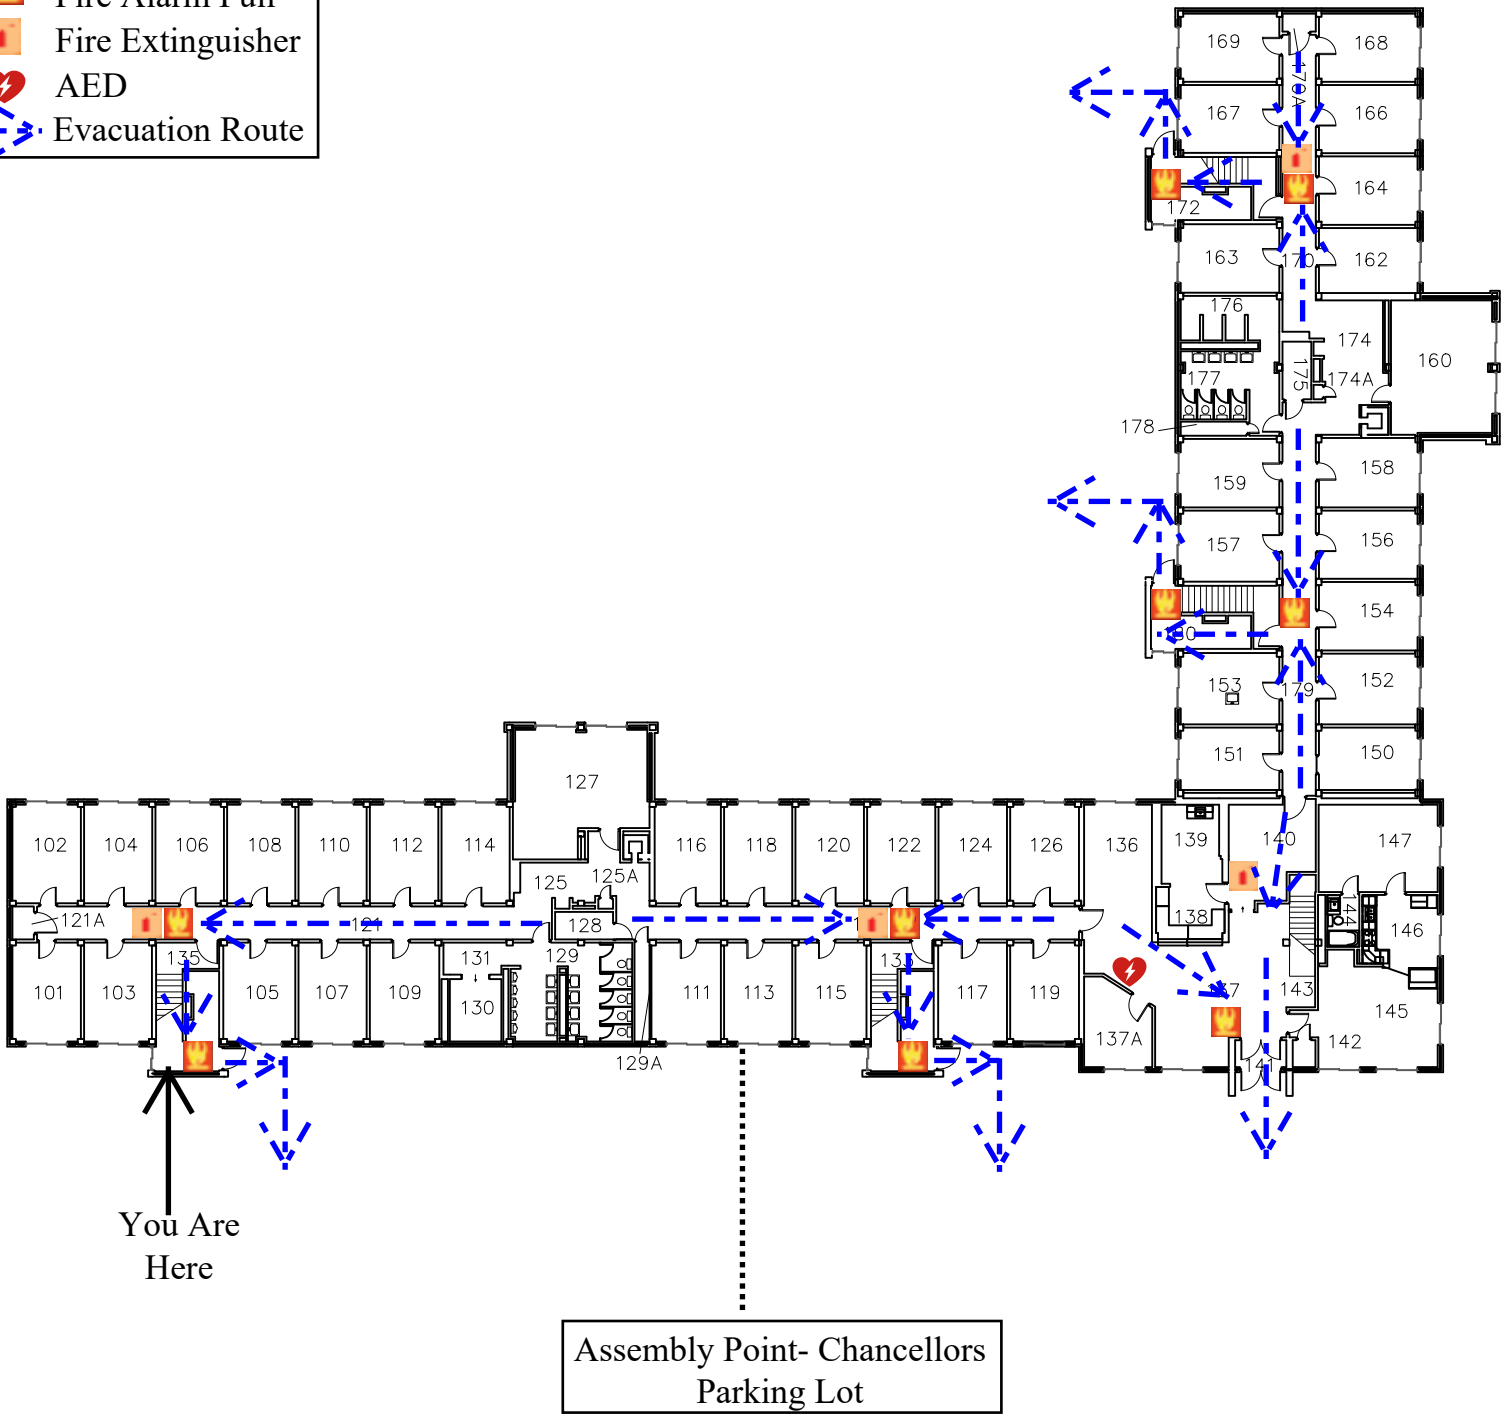

University of Wisconsin-Eau Claire


Facilities Planning

Governors Hall First Floor Plan

DATE:
Aug. 2021
DWG NO:
1



 Fire Alarm Pull
  Fire Extinguisher
  AED
  Evacuation Route

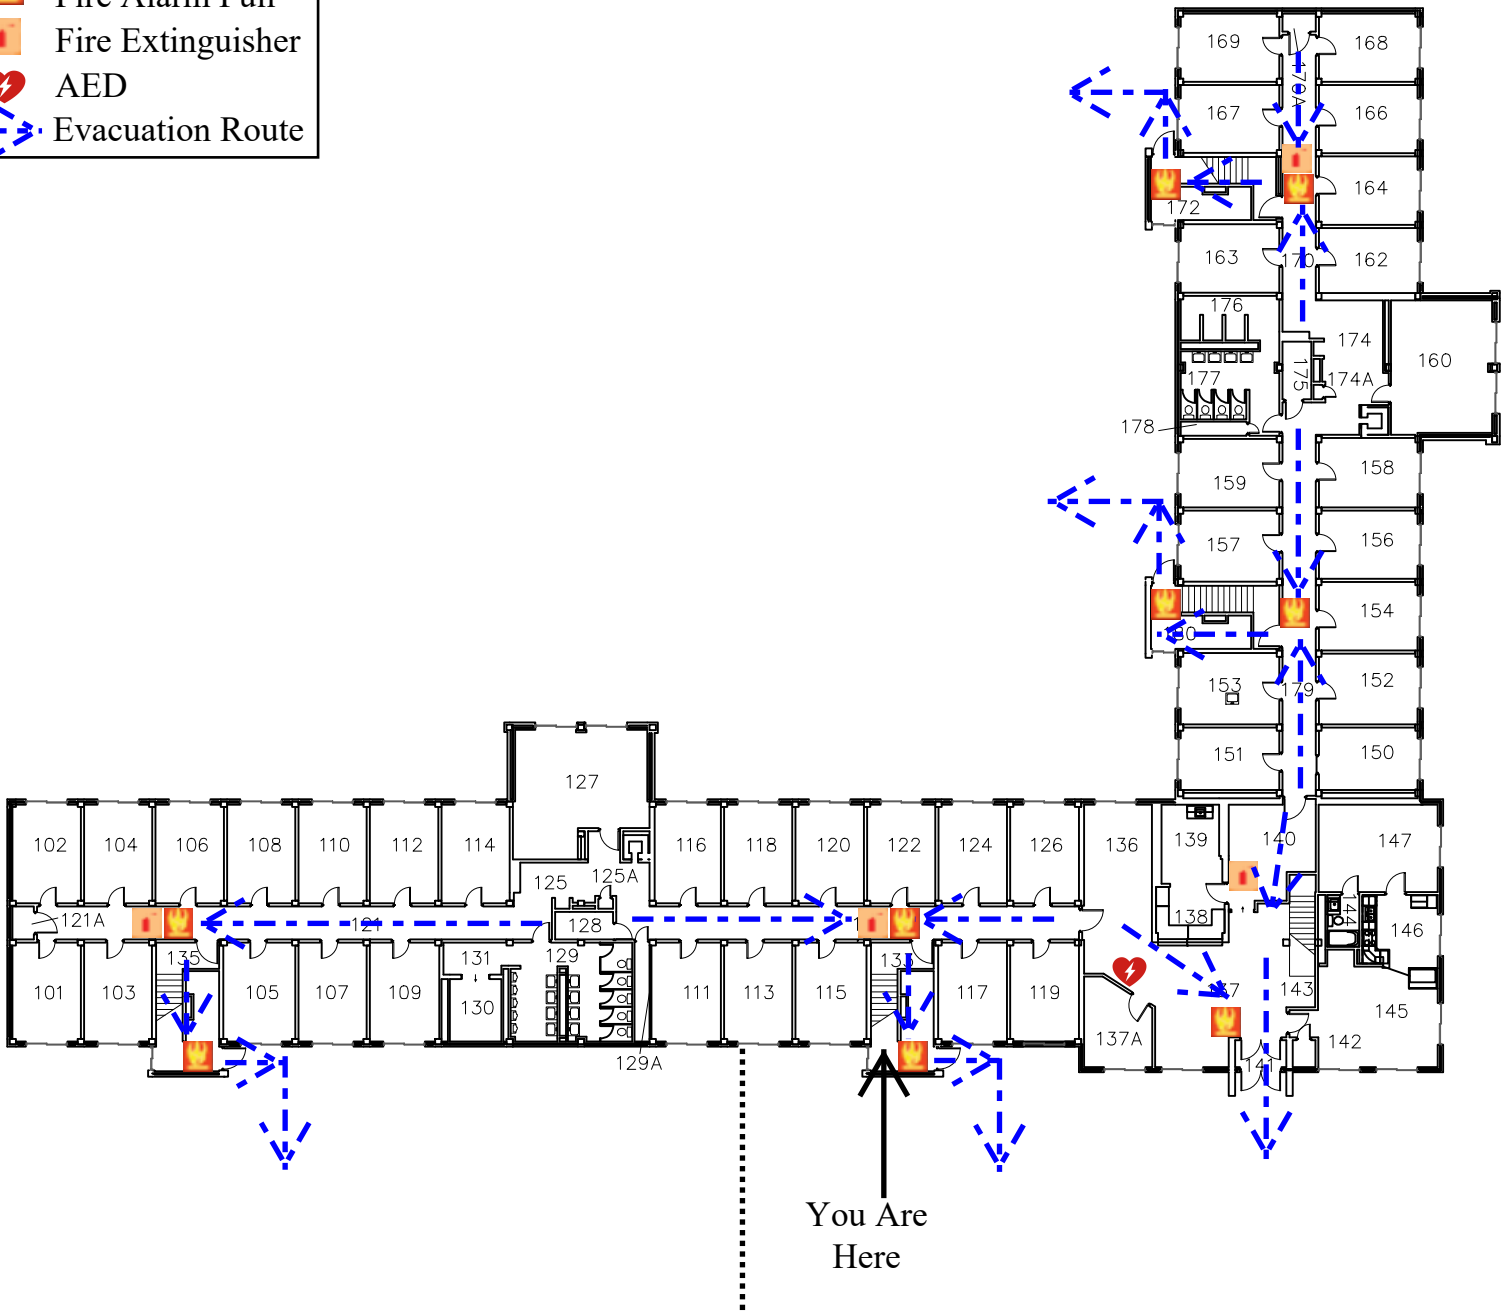

Assembly Point- Chancellors
Parking Lot



University of Wisconsin-Eau Claire


Facilities Planning

Governors Hall
First Floor Plan

DATE:
Aug. 2021
DWG NO:
2



 Fire Alarm Pull
 Fire Extinguisher
 AED
 Evacuation Route

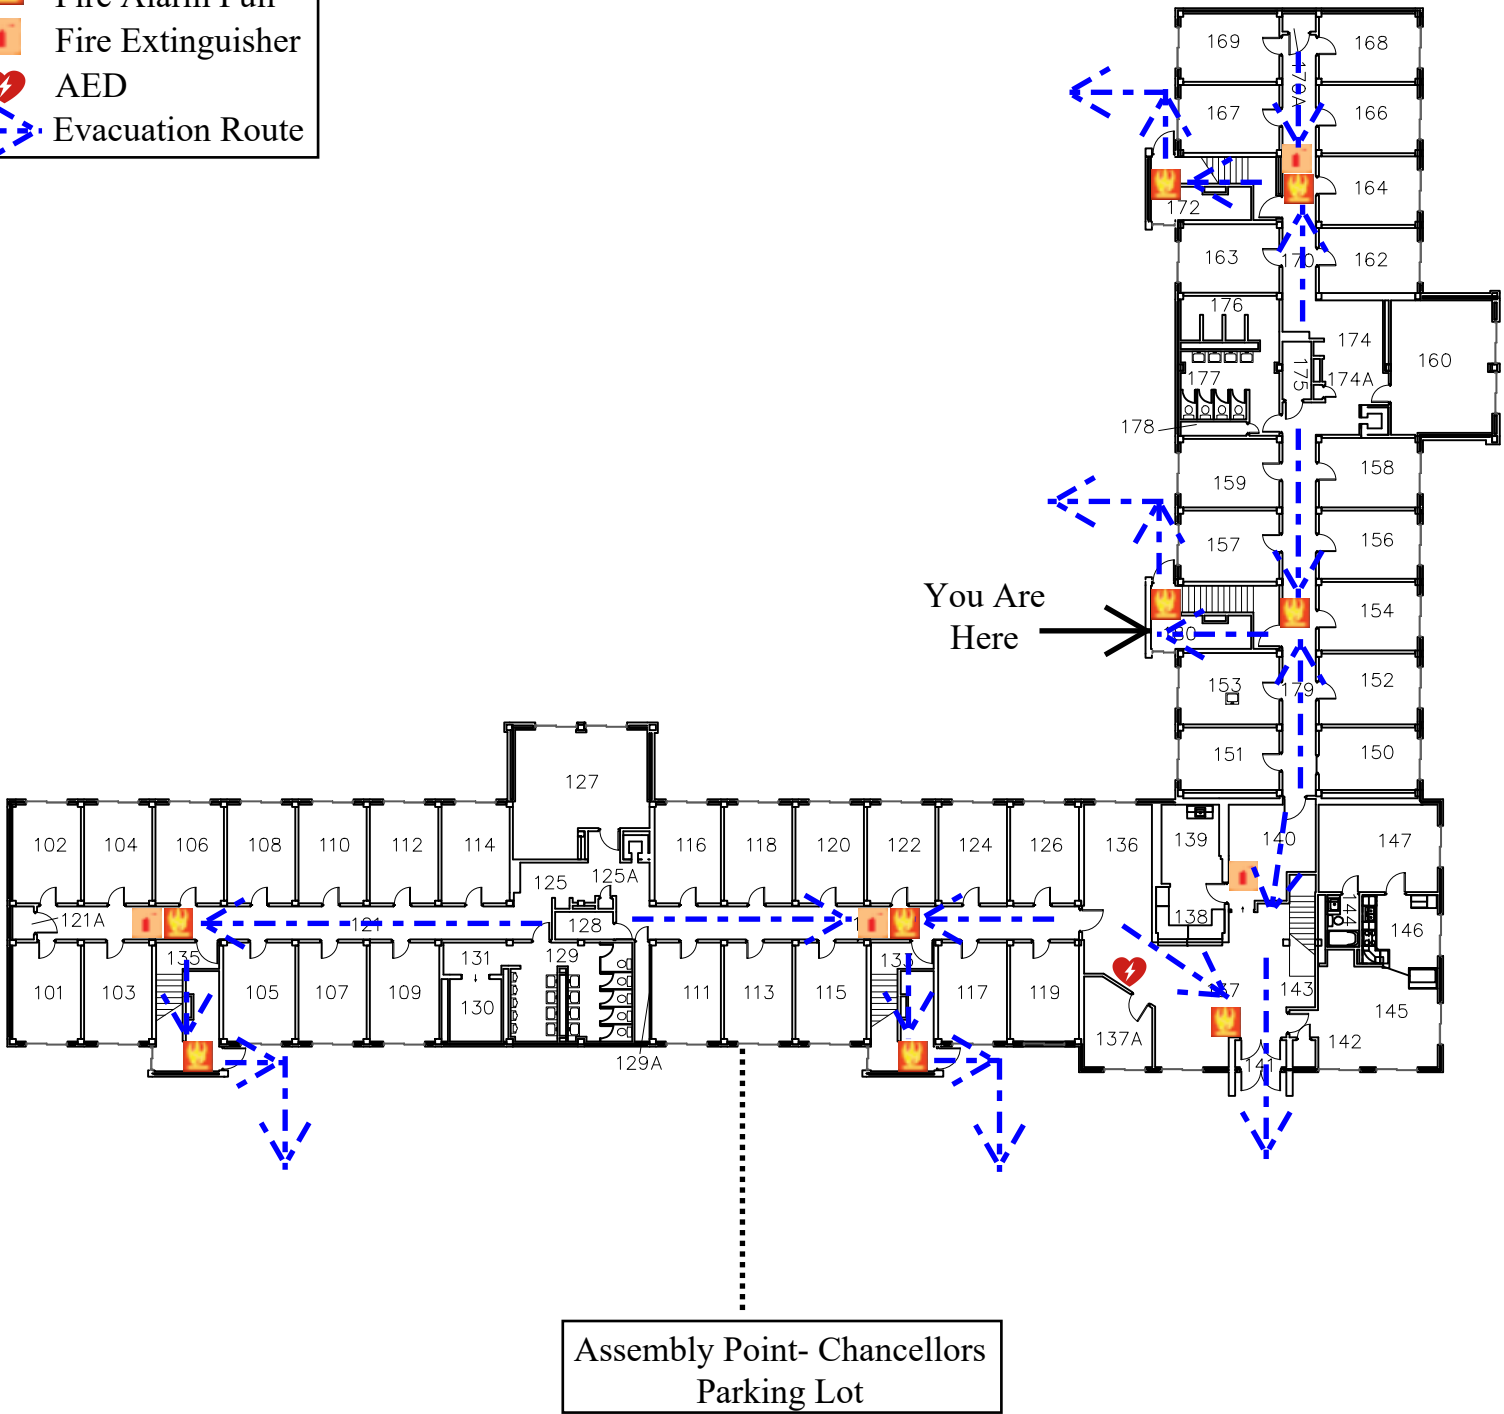

University of Wisconsin-Eau Claire


Facilities Planning

Governors Hall
First Floor Plan

DATE:
Aug. 2021
DWG NO:
3



 Fire Alarm Pull
 Fire Extinguisher
 AED
 Evacuation Route

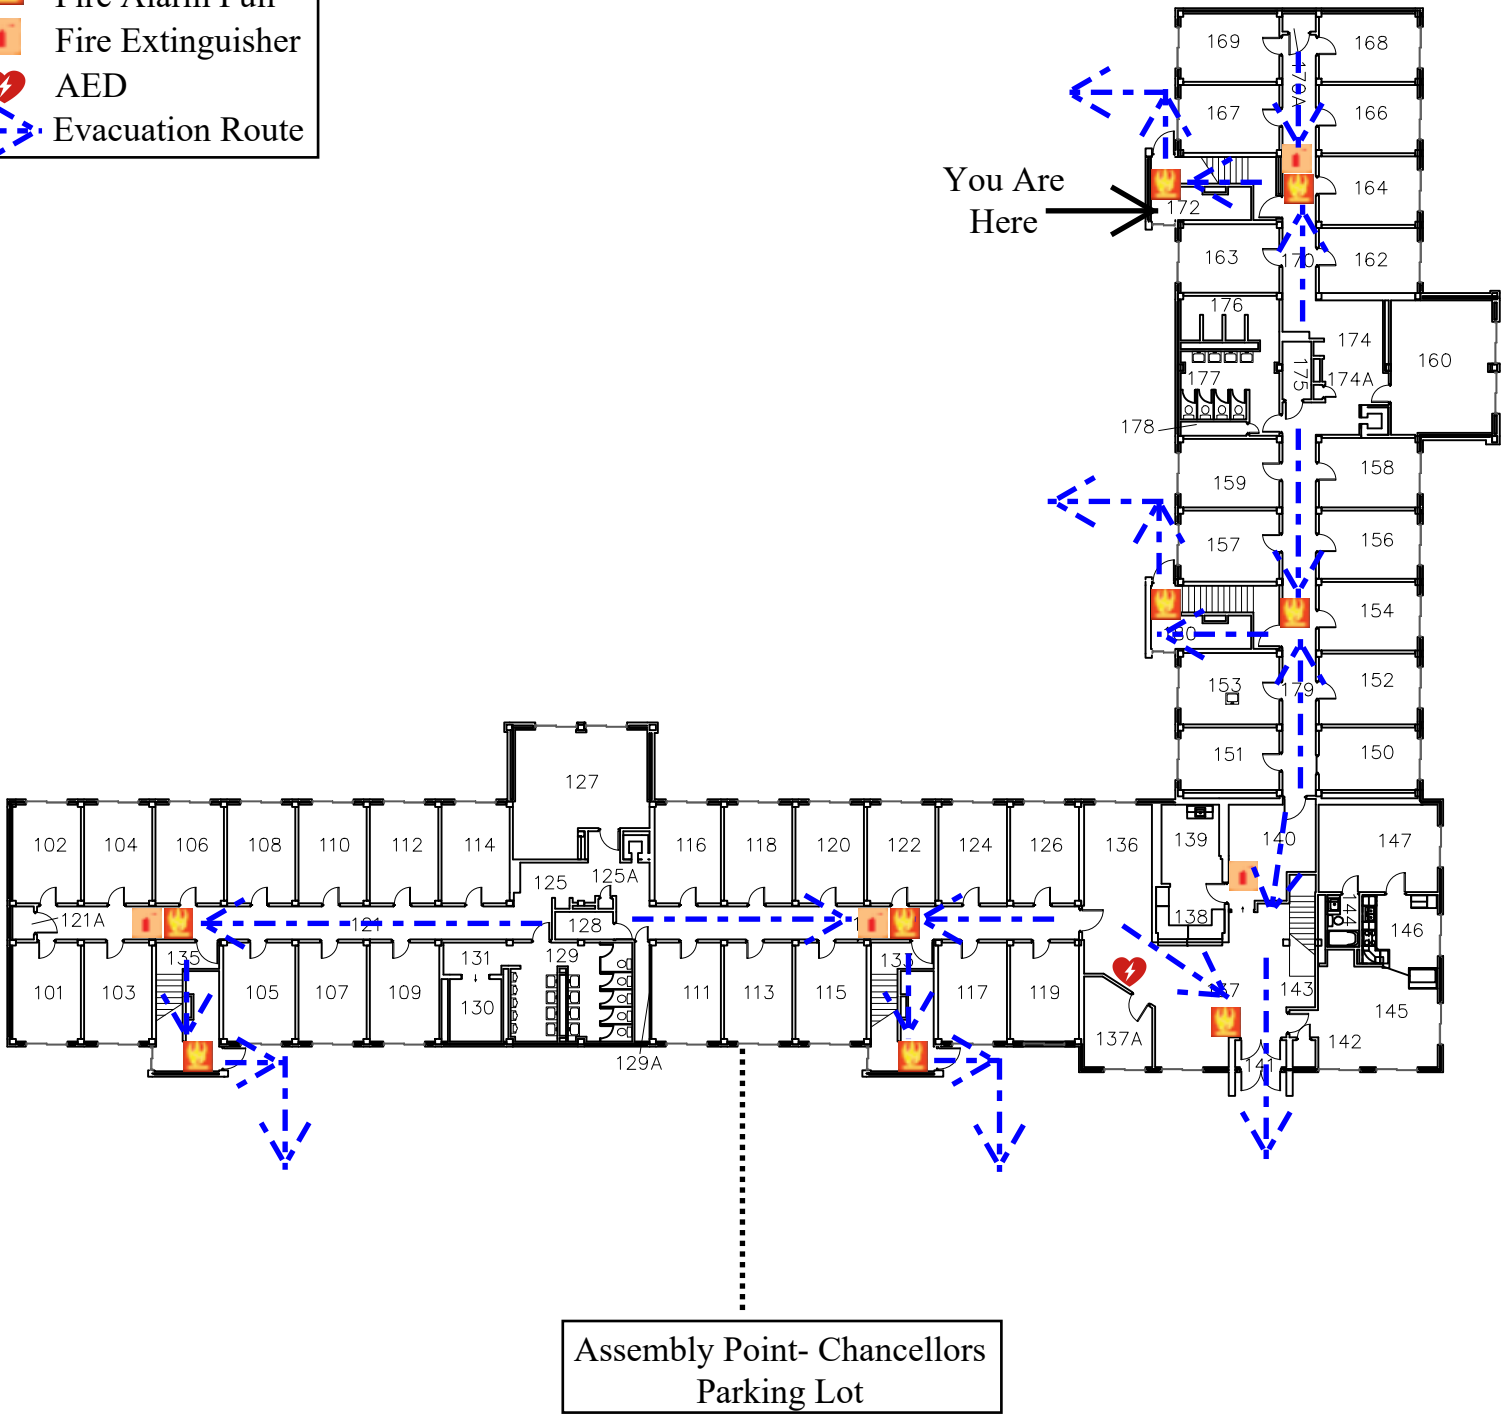

University of Wisconsin-Eau Claire


Facilities Planning

Governors Hall
First Floor Plan

DATE:
Aug. 2021
DWG NO:
4



 Fire Alarm Pull
 Fire Extinguisher
 AED
 Evacuation Route

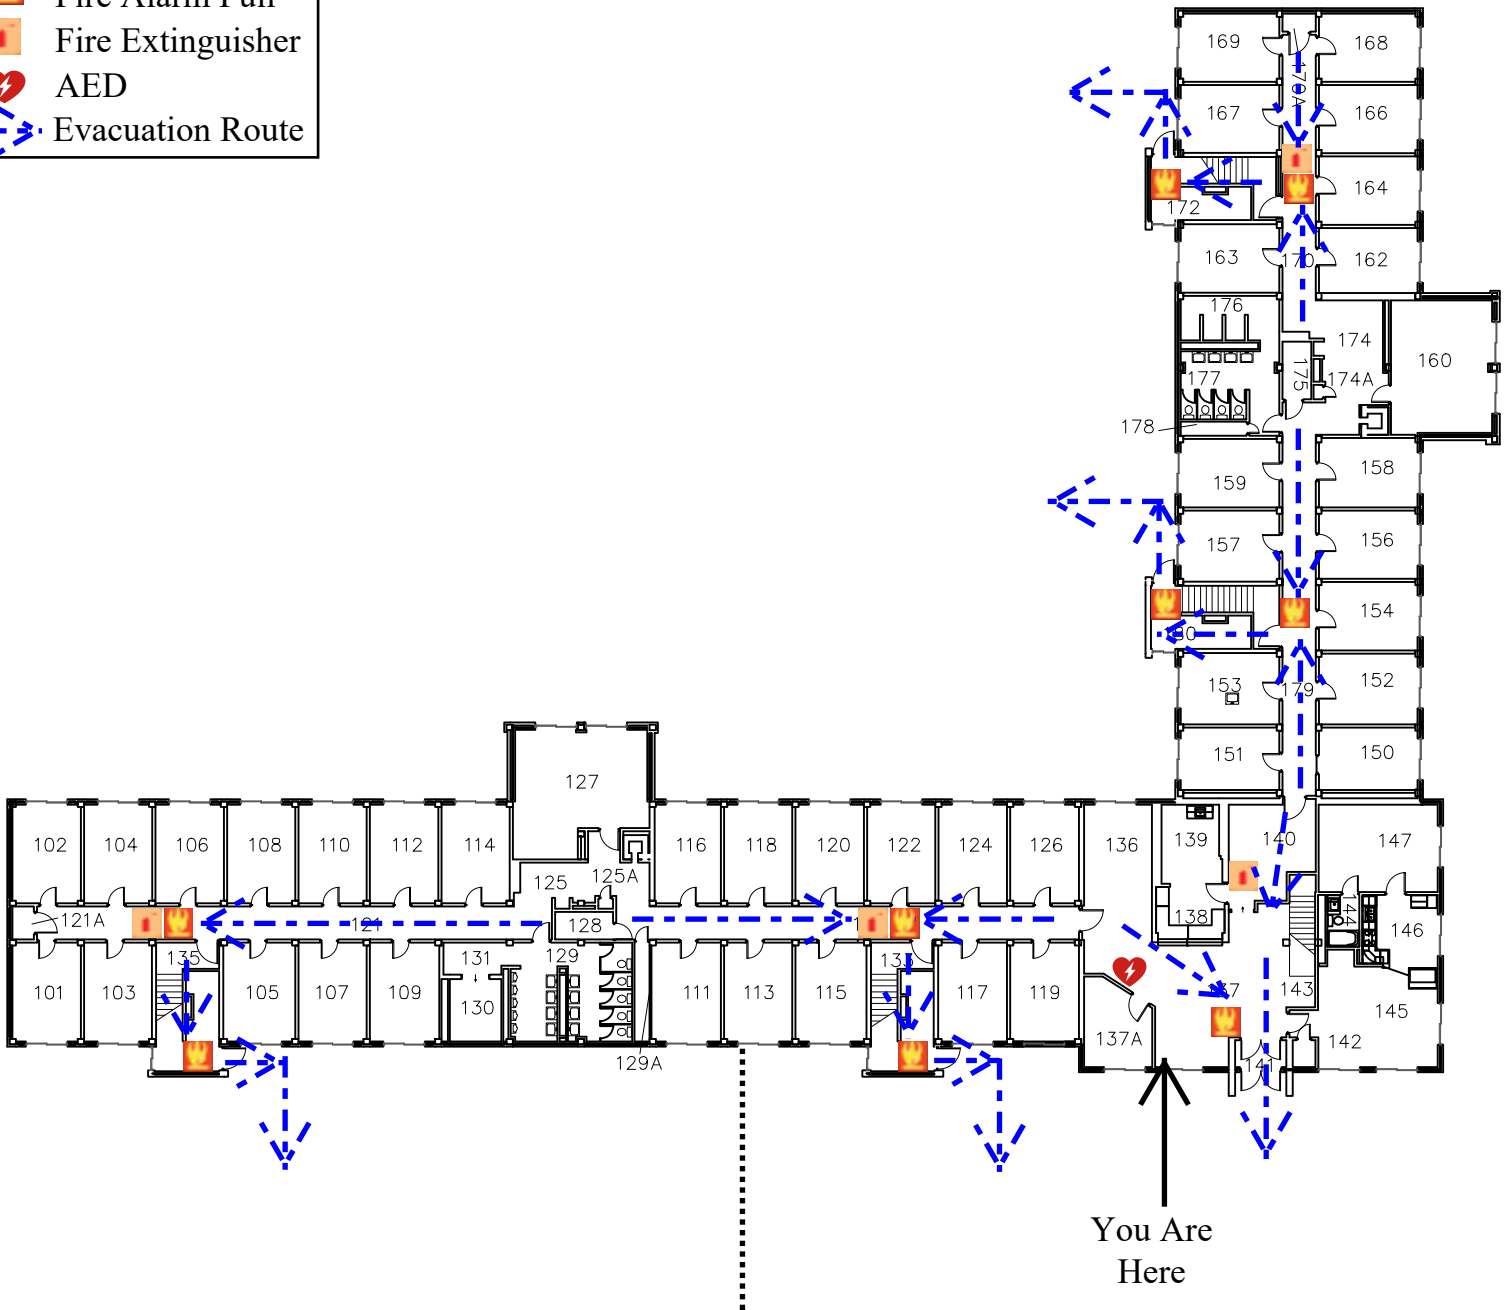

Assembly Point- Chancellors
Parking Lot



University of Wisconsin-Eau Claire


Facilities Planning

Governors Hall
First Floor Plan

DATE:
Aug. 2021
DWG NO:
5



 Fire Alarm Pull
 Fire Extinguisher
 Evacuation Route

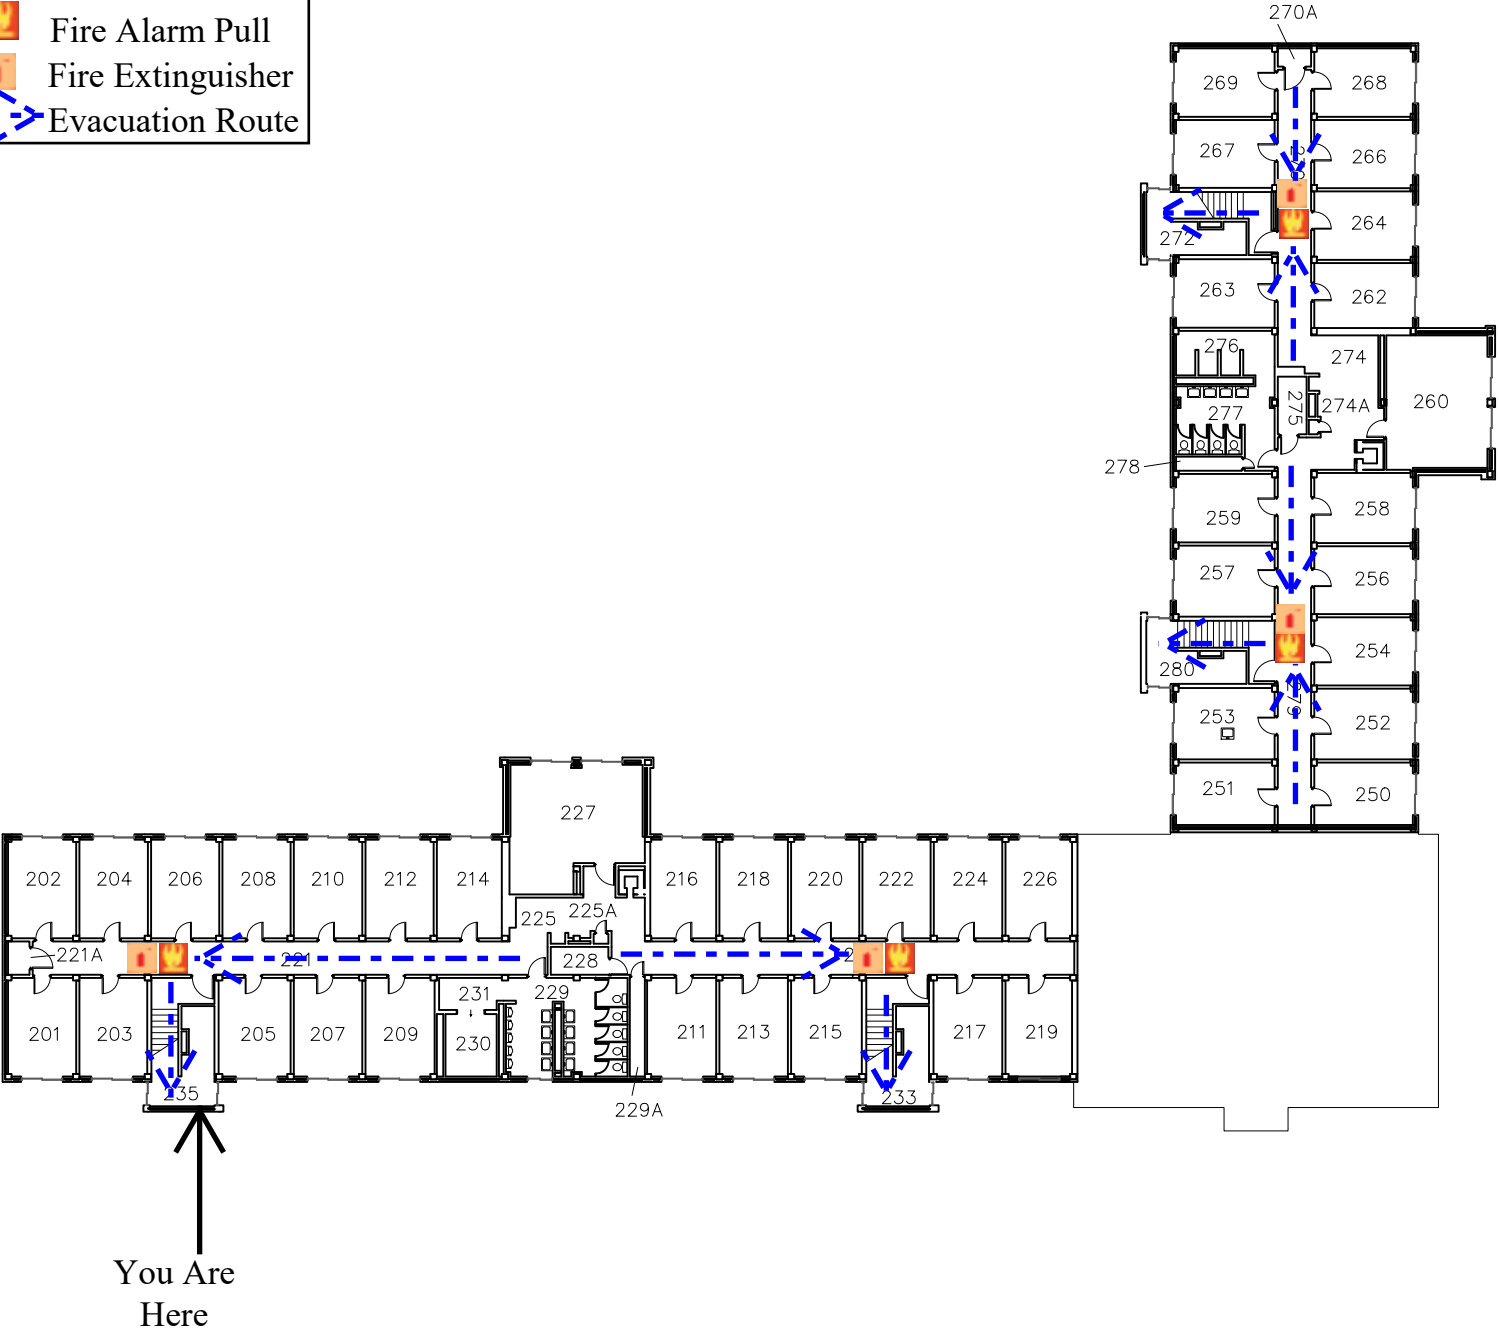

University of Wisconsin-Eau Claire


Facilities Planning

Governors Hall
Second Floor Plan

DATE:
Aug. 2021
DWG NO:
1



 Fire Alarm Pull
 Fire Extinguisher
 Evacuation Route

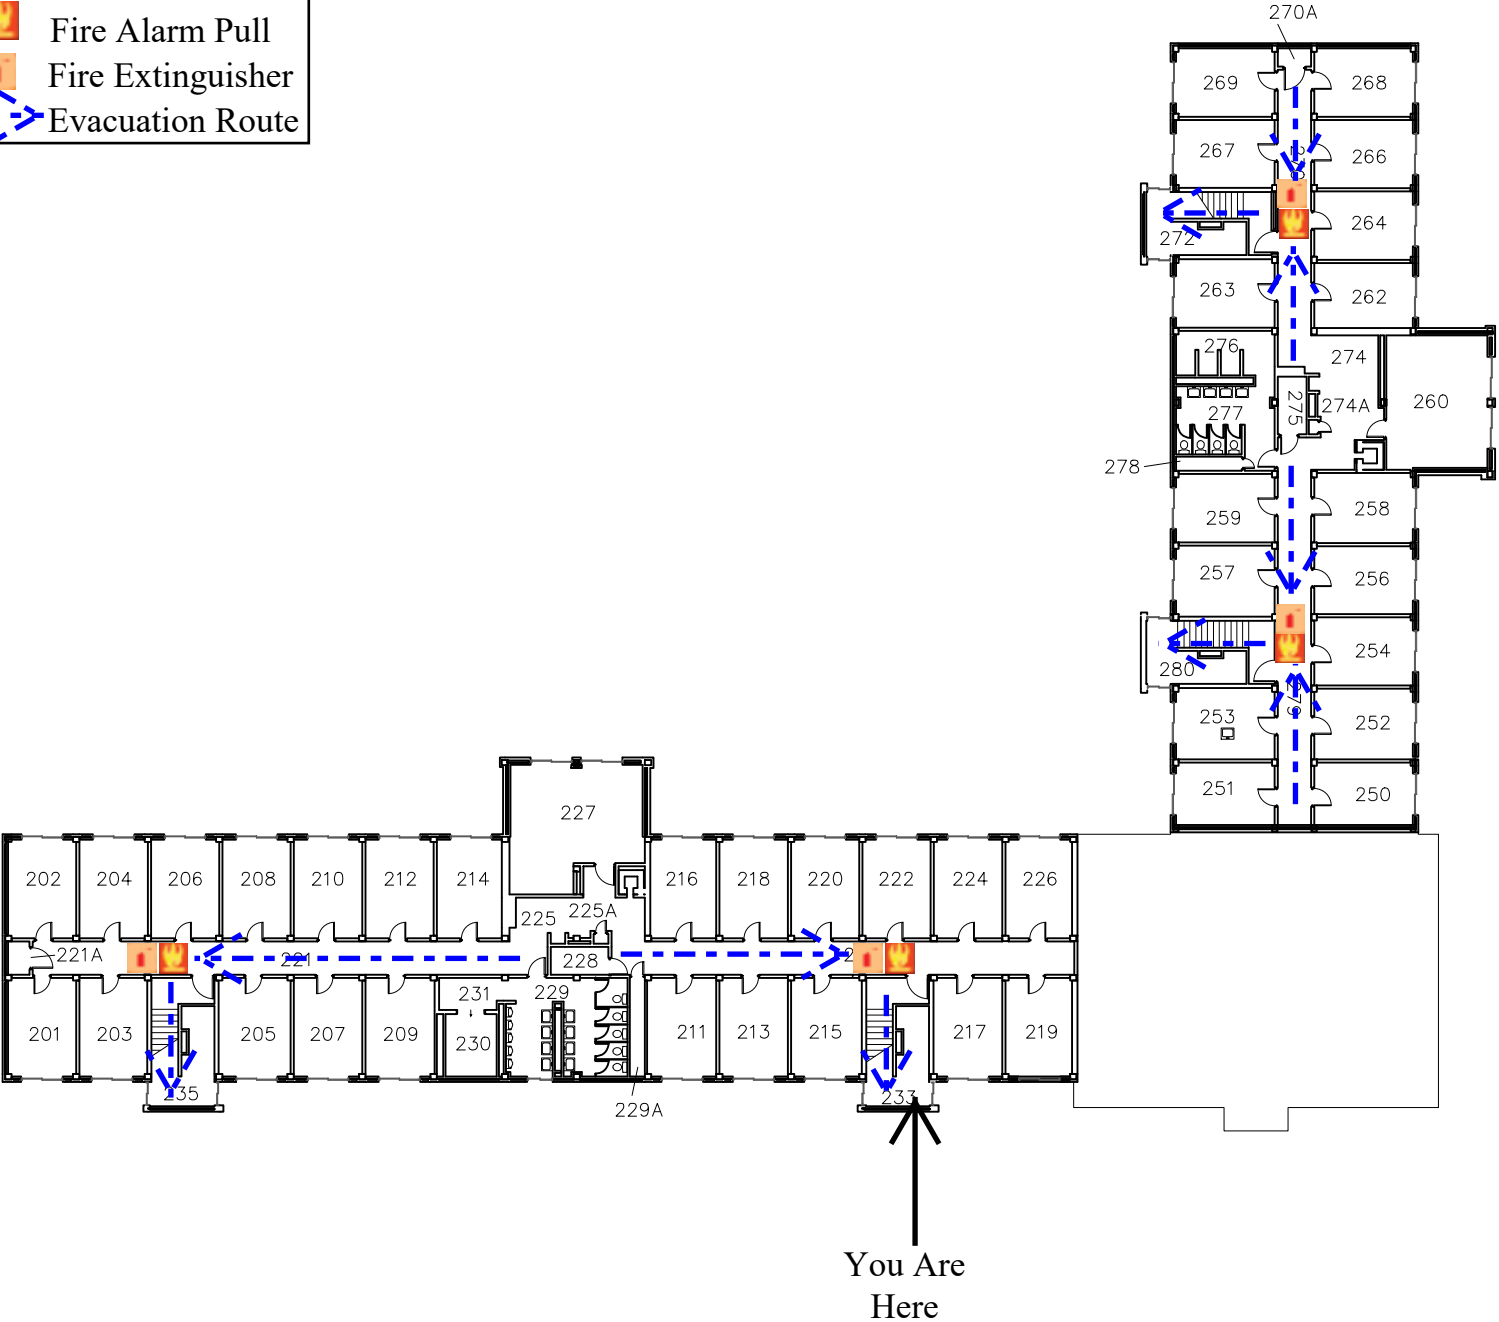

University of Wisconsin-Eau Claire


Facilities Planning

Governors Hall
Second Floor Plan

DATE:
Aug. 2021
DWG NO:
2



 Fire Alarm Pull
 Fire Extinguisher
 Evacuation Route

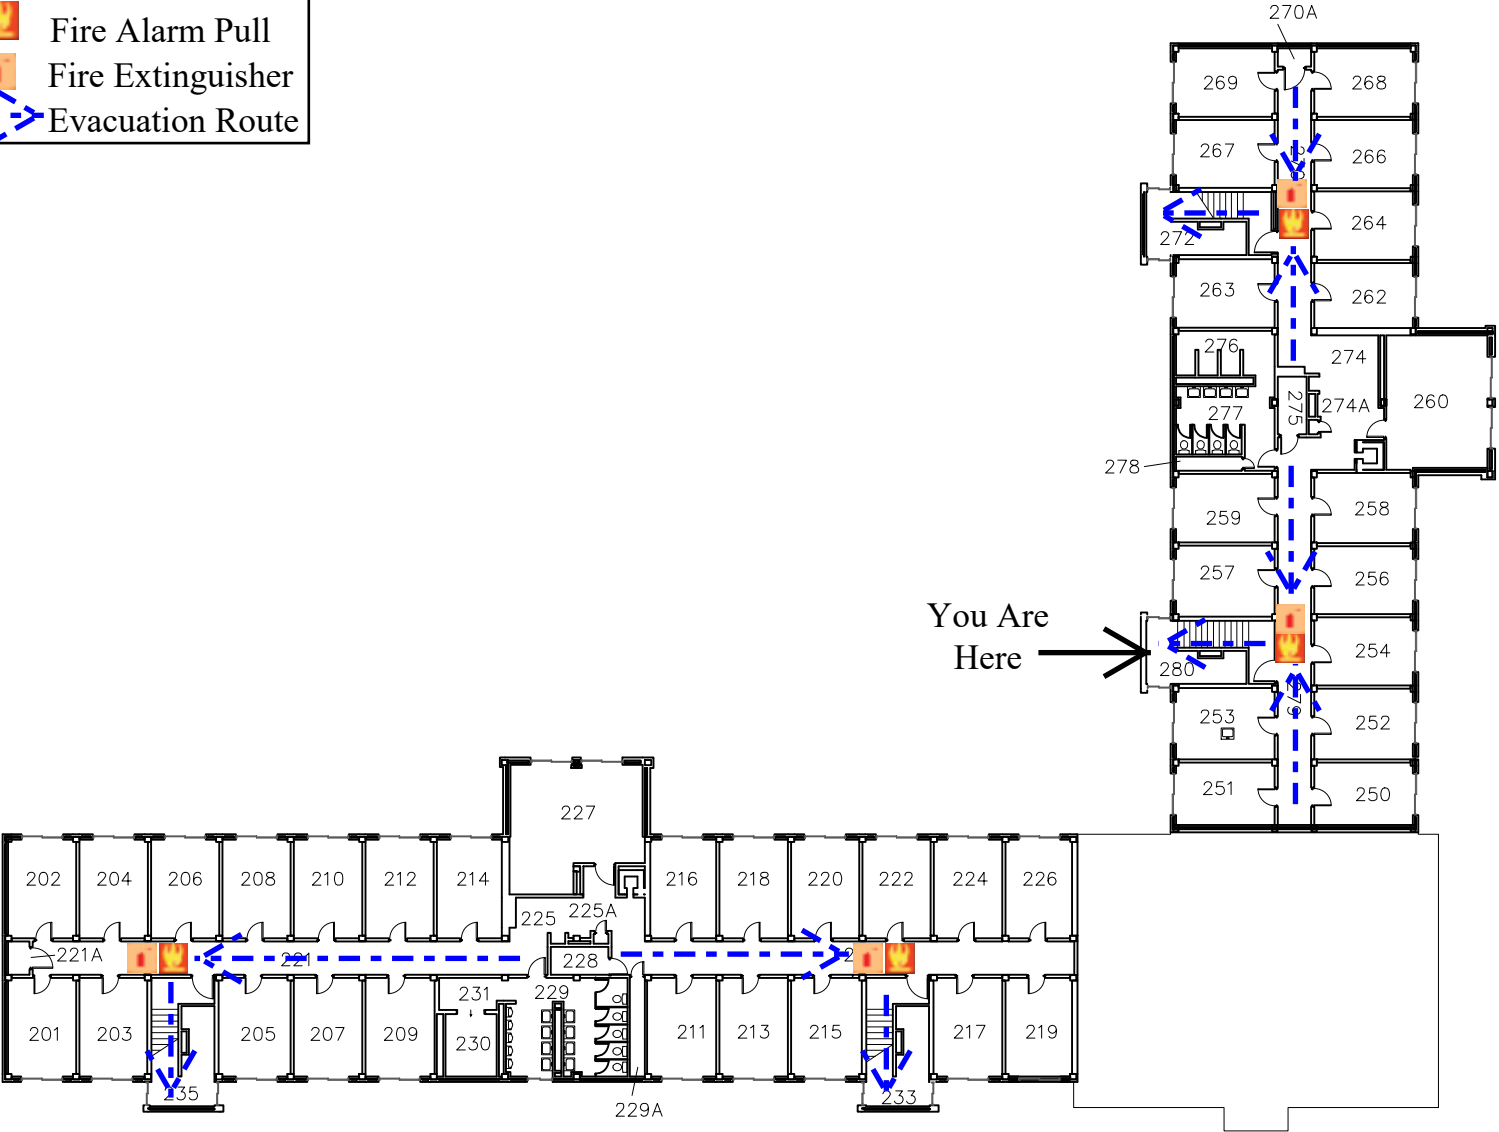

University of Wisconsin-Eau Claire


Facilities Planning

Governors Hall
Second Floor Plan

DATE:
Aug. 2021
DWG NO:
3



 Fire Alarm Pull
 Fire Extinguisher
 Evacuation Route

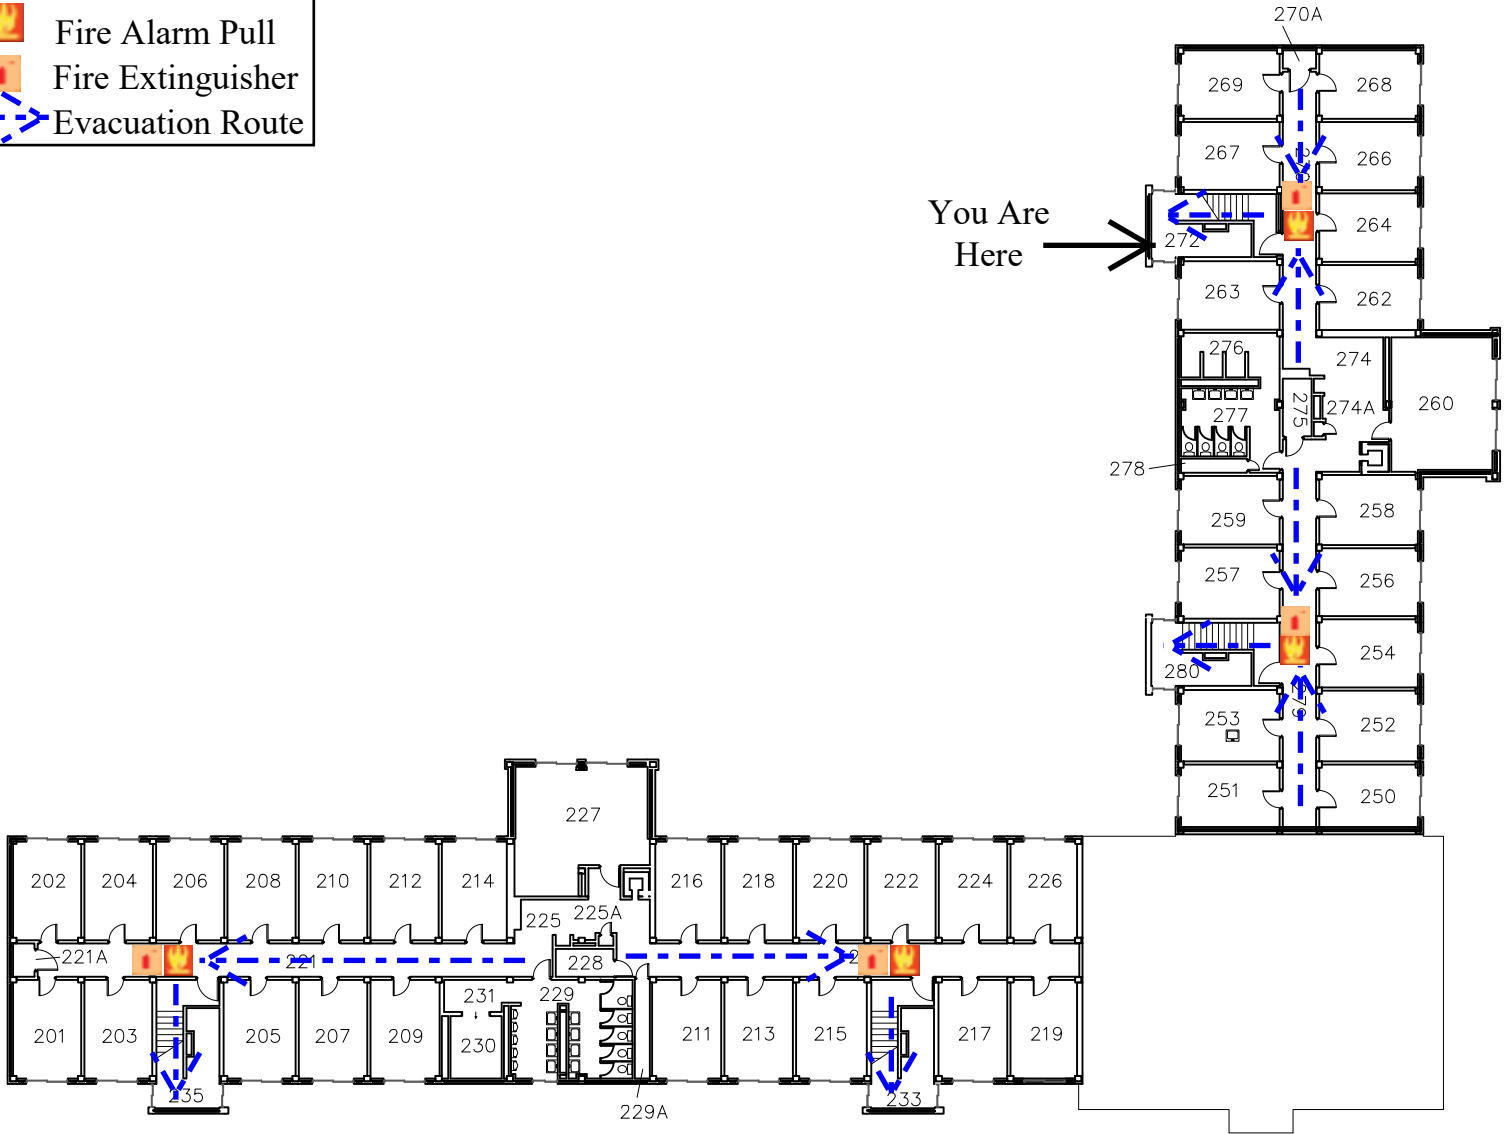

University of Wisconsin-Eau Claire

Facilities Planning

Governors Hall
Second Floor Plan

DATE:
Aug. 2021


DWG NO:
4




Fire Alarm Pull


Fire Extinguisher


Evacuation Route

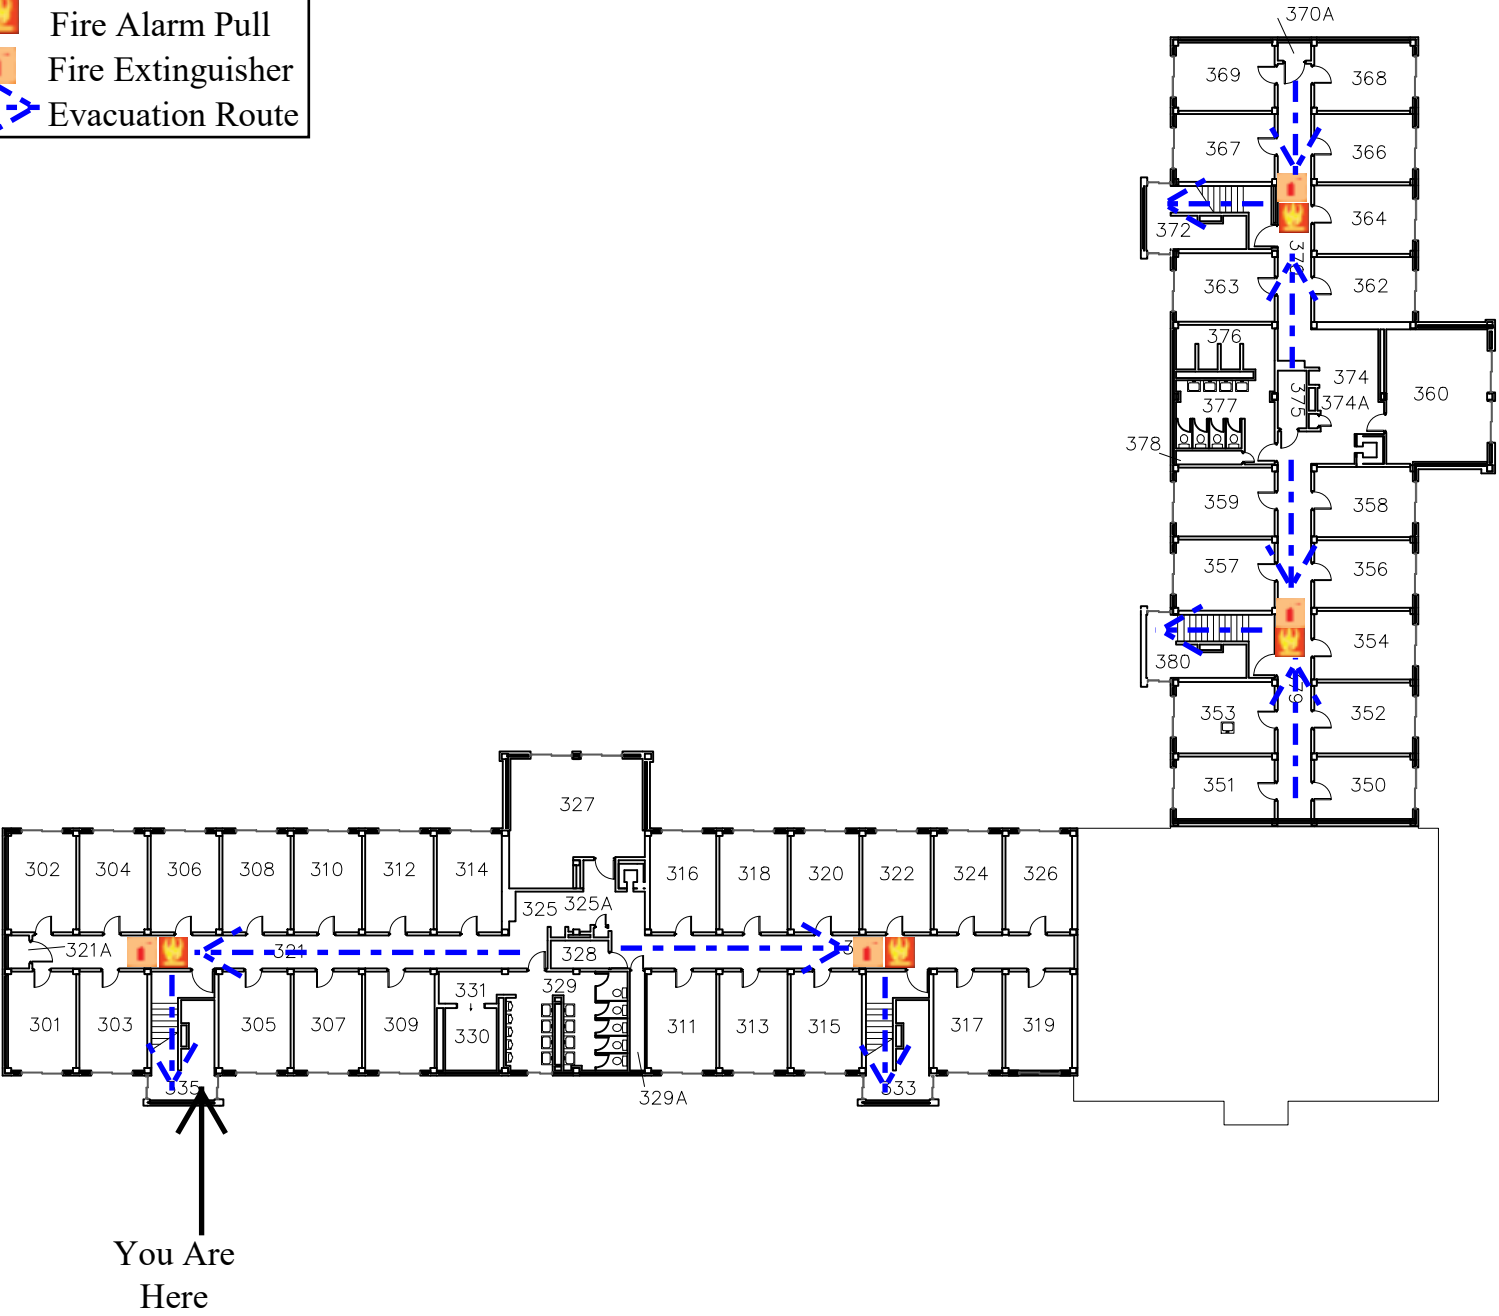

University of Wisconsin-Eau Claire

Facilities Planning

Governors Hall
Third Floor Plan

DATE:


Aug. 2021

DWG NO:

1



 Fire Alarm Pull
 Fire Extinguisher
 Evacuation Route

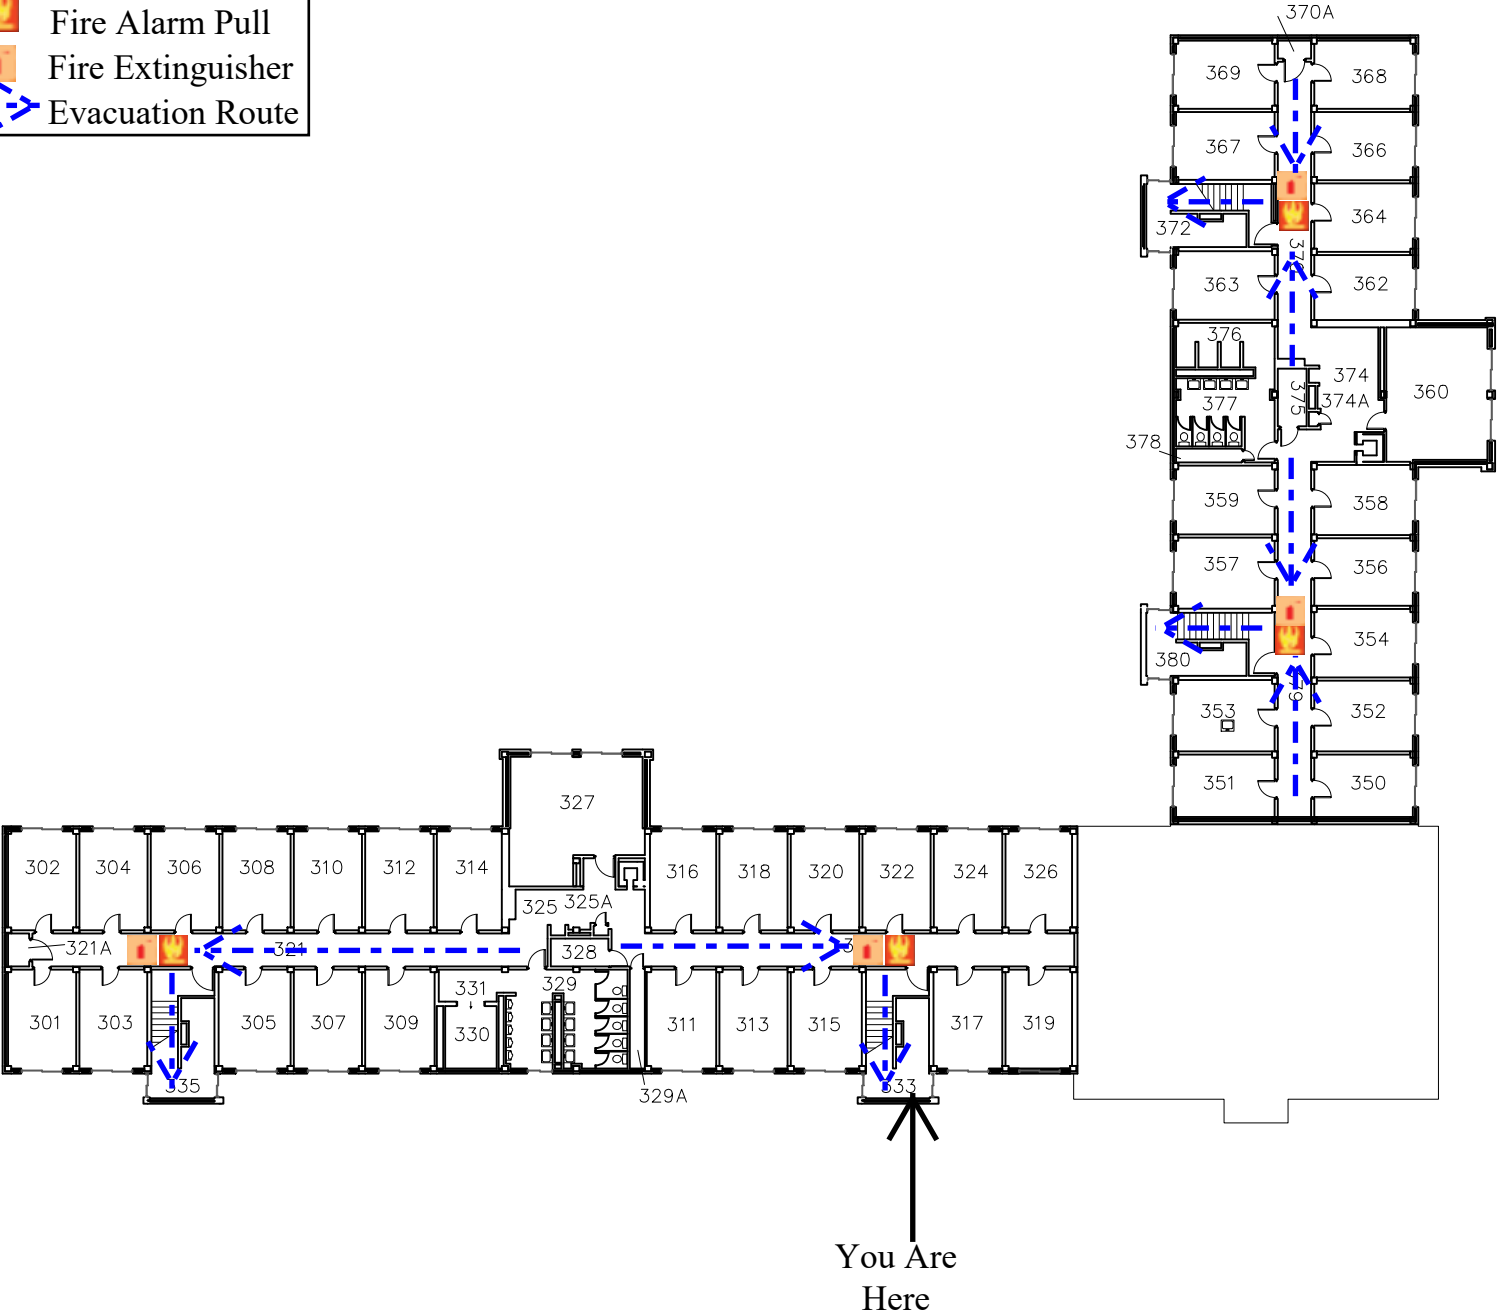

University of Wisconsin-Eau Claire


Facilities Planning

Governors Hall
Third Floor Plan

DATE:
Aug. 2021
DWG NO:
2



 Fire Alarm Pull
 Fire Extinguisher
 Evacuation Route

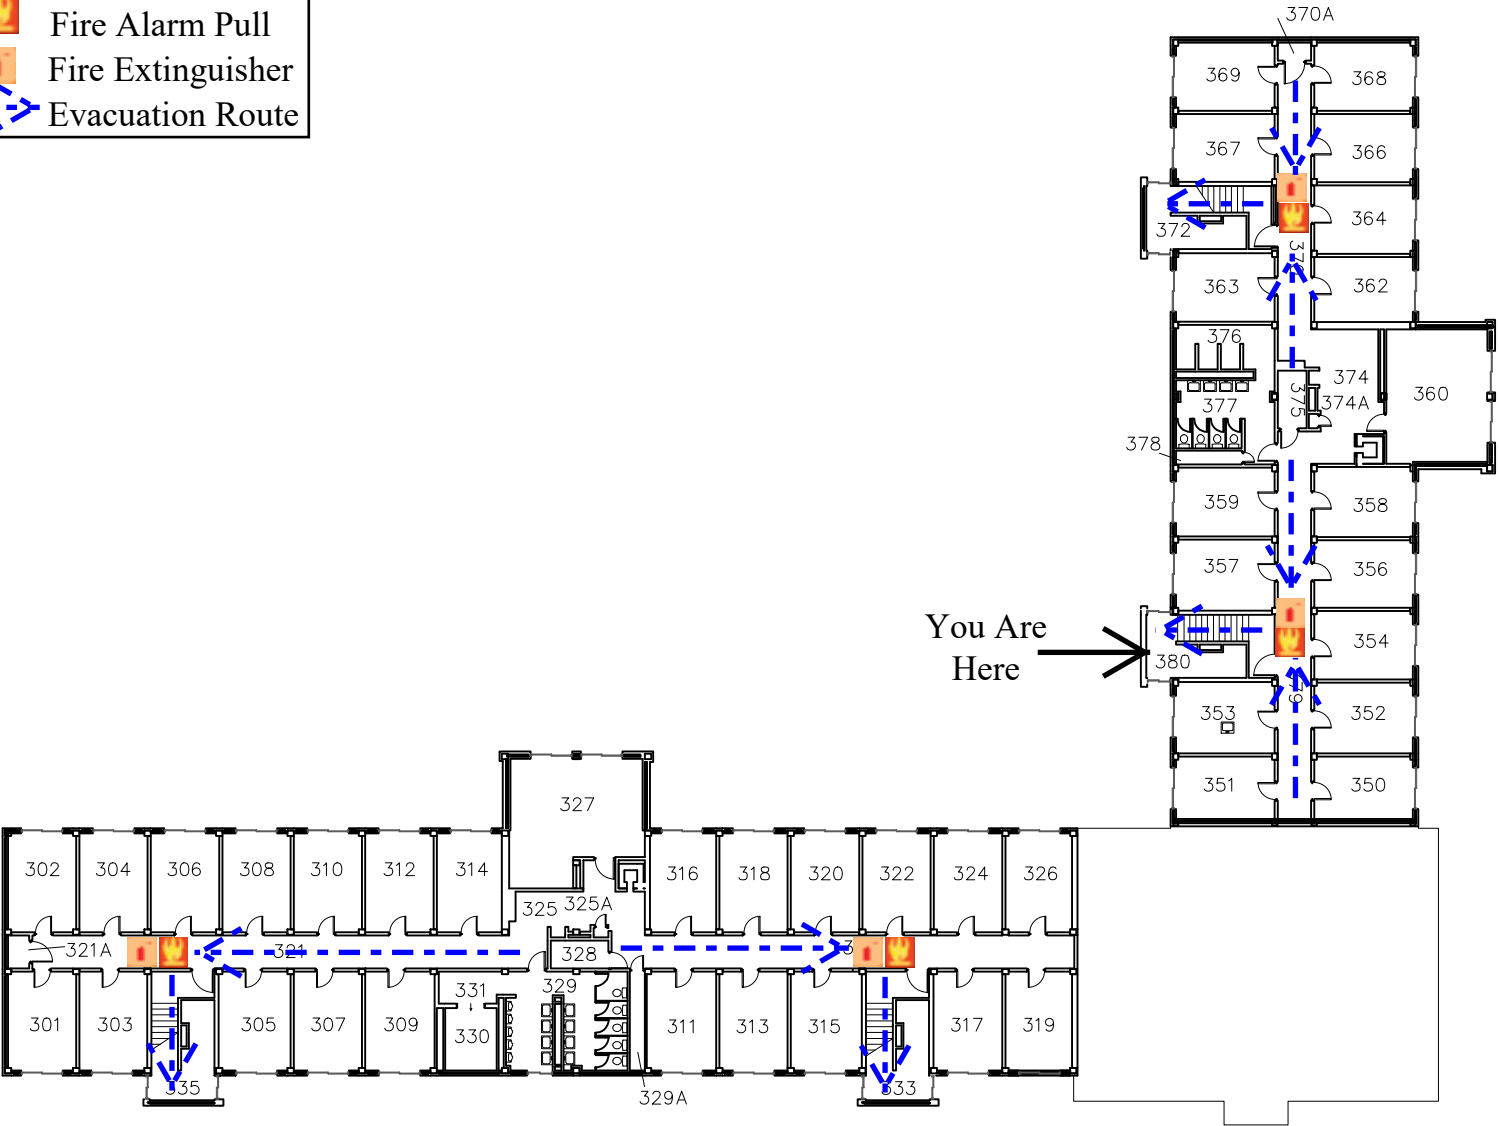

University of Wisconsin-Eau Claire

Facilities Planning


Governors Hall
Third Floor Plan

DATE:
Aug. 2021

DWG NO:
3



 Fire Alarm Pull
 Fire Extinguisher
 Evacuation Route

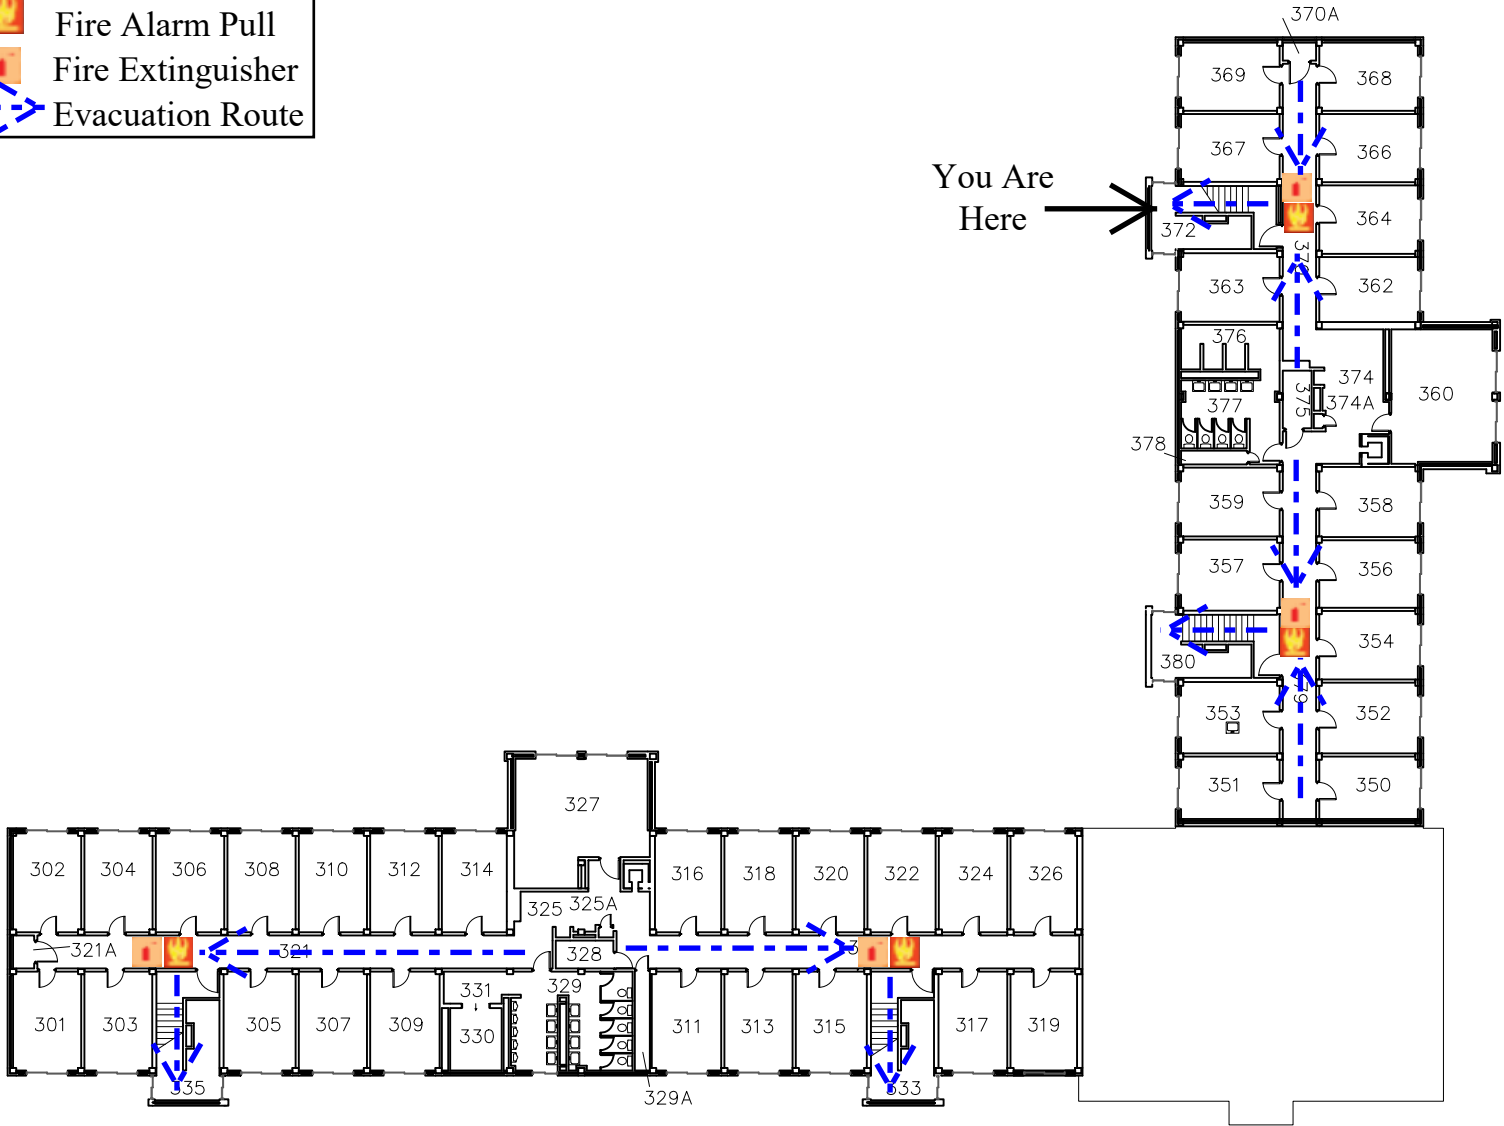

University of Wisconsin-Eau Claire

Facilities Planning


Governors Hall
Third Floor Plan

DATE:
Aug. 2021


DWG NO:
4



 Fire Alarm Pull
  Fire Extinguisher
  Evacuation Route

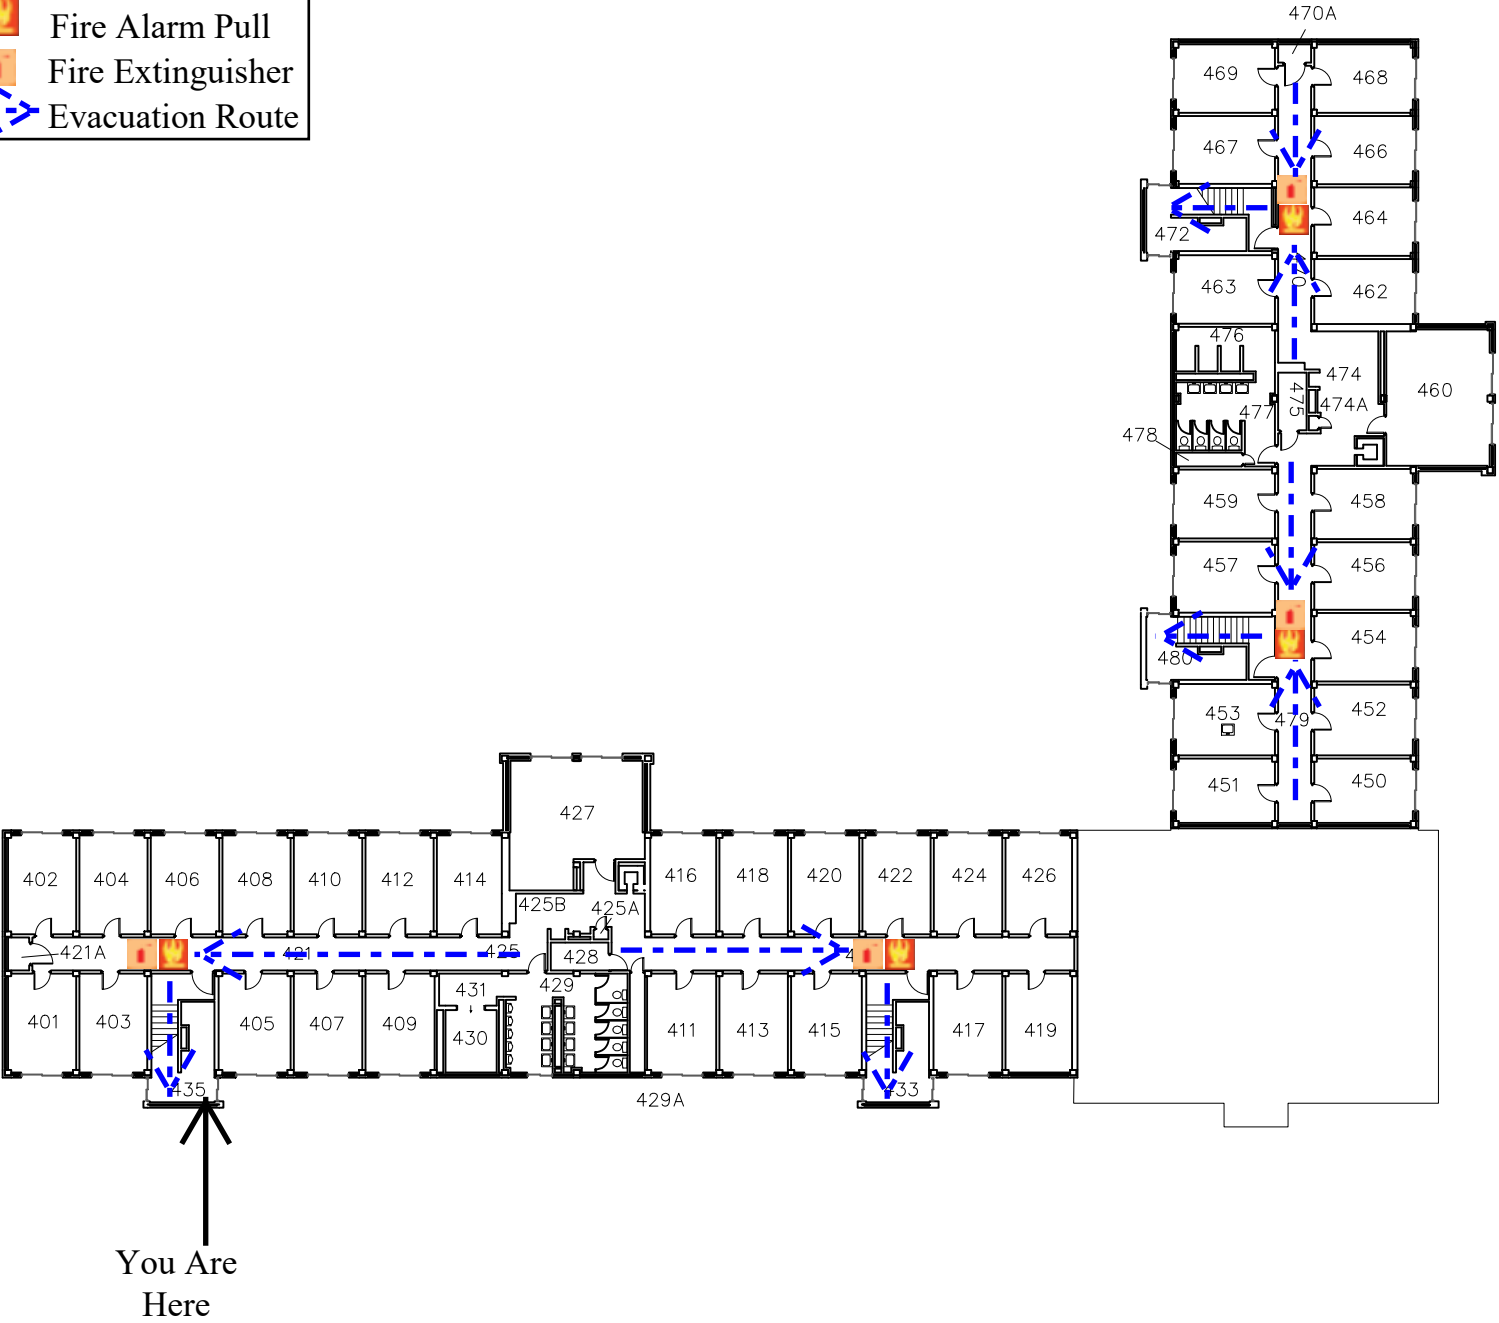

 Fire Alarm Pull
 Fire Extinguisher
 Evacuation Route

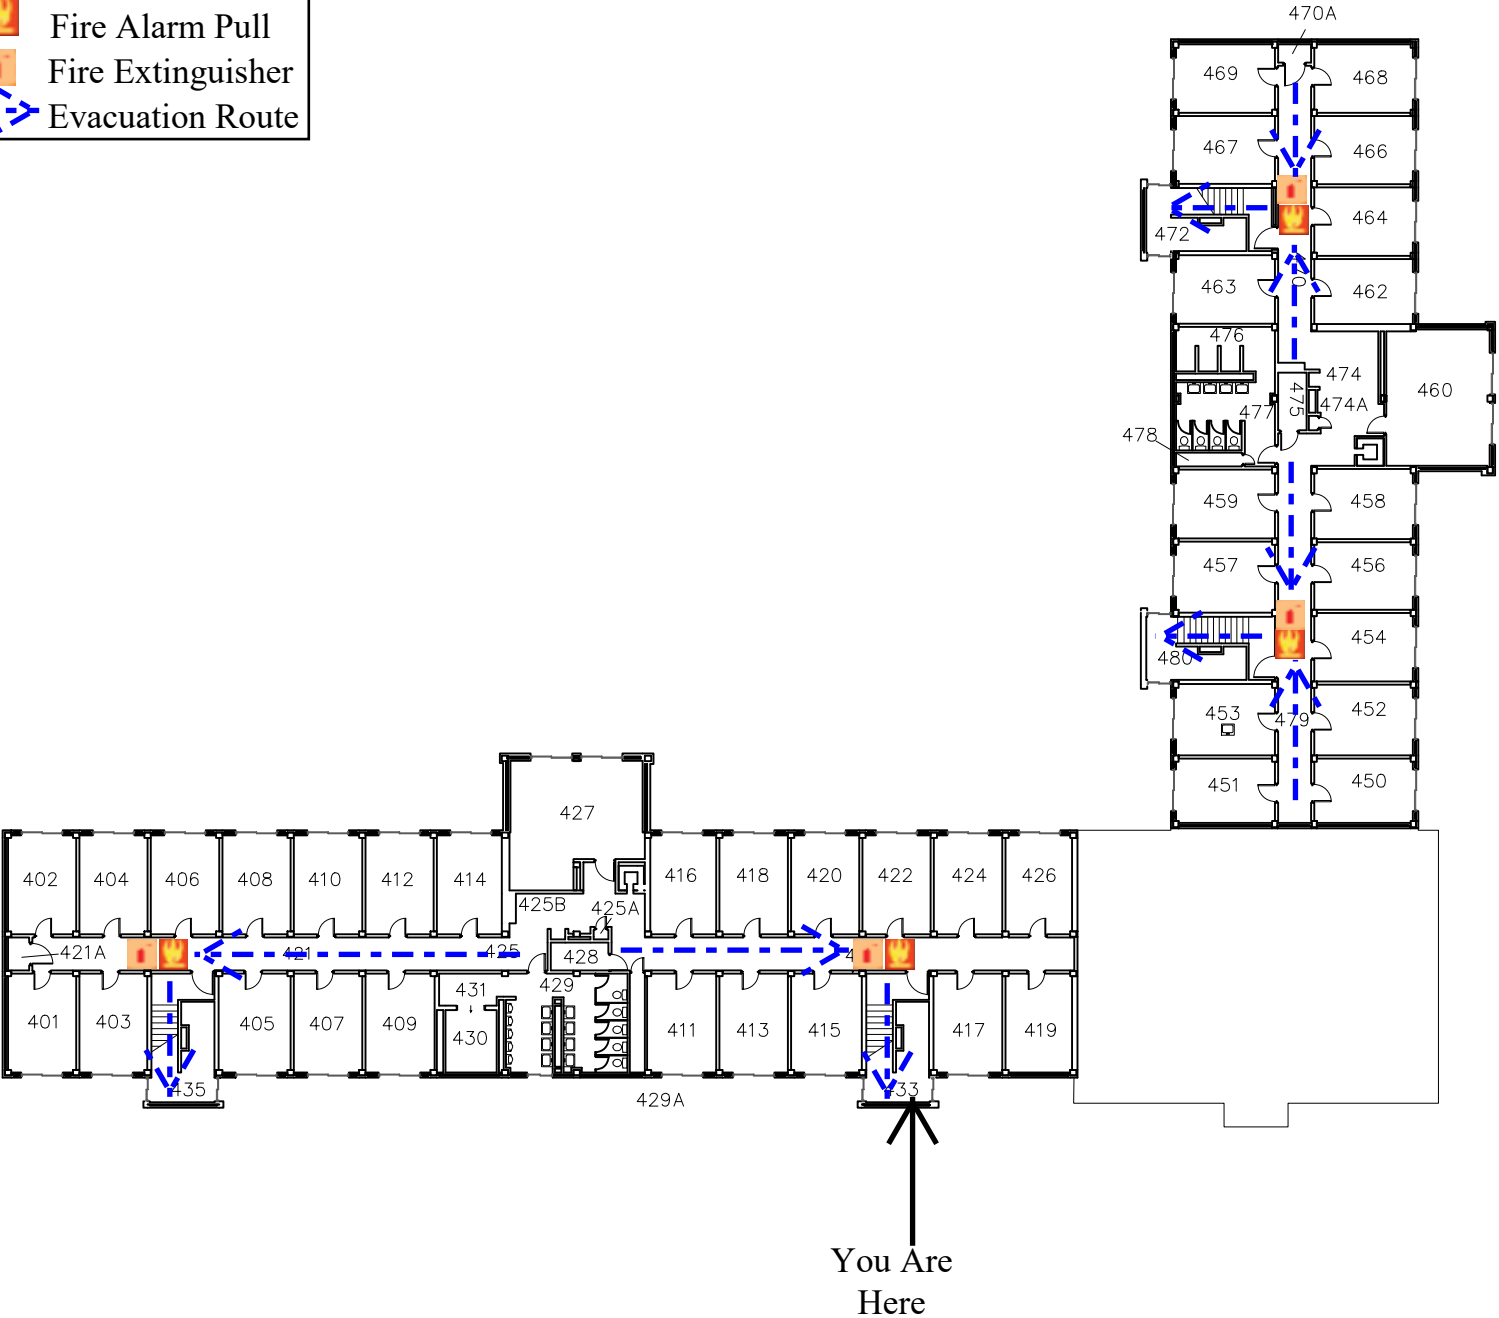

University of Wisconsin-Eau Claire


Facilities Planning

Governors Hall
Forth Floor Plan

DATE:
Aug. 2021
DWG NO:
2



 Fire Alarm Pull
  Fire Extinguisher
  Evacuation Route

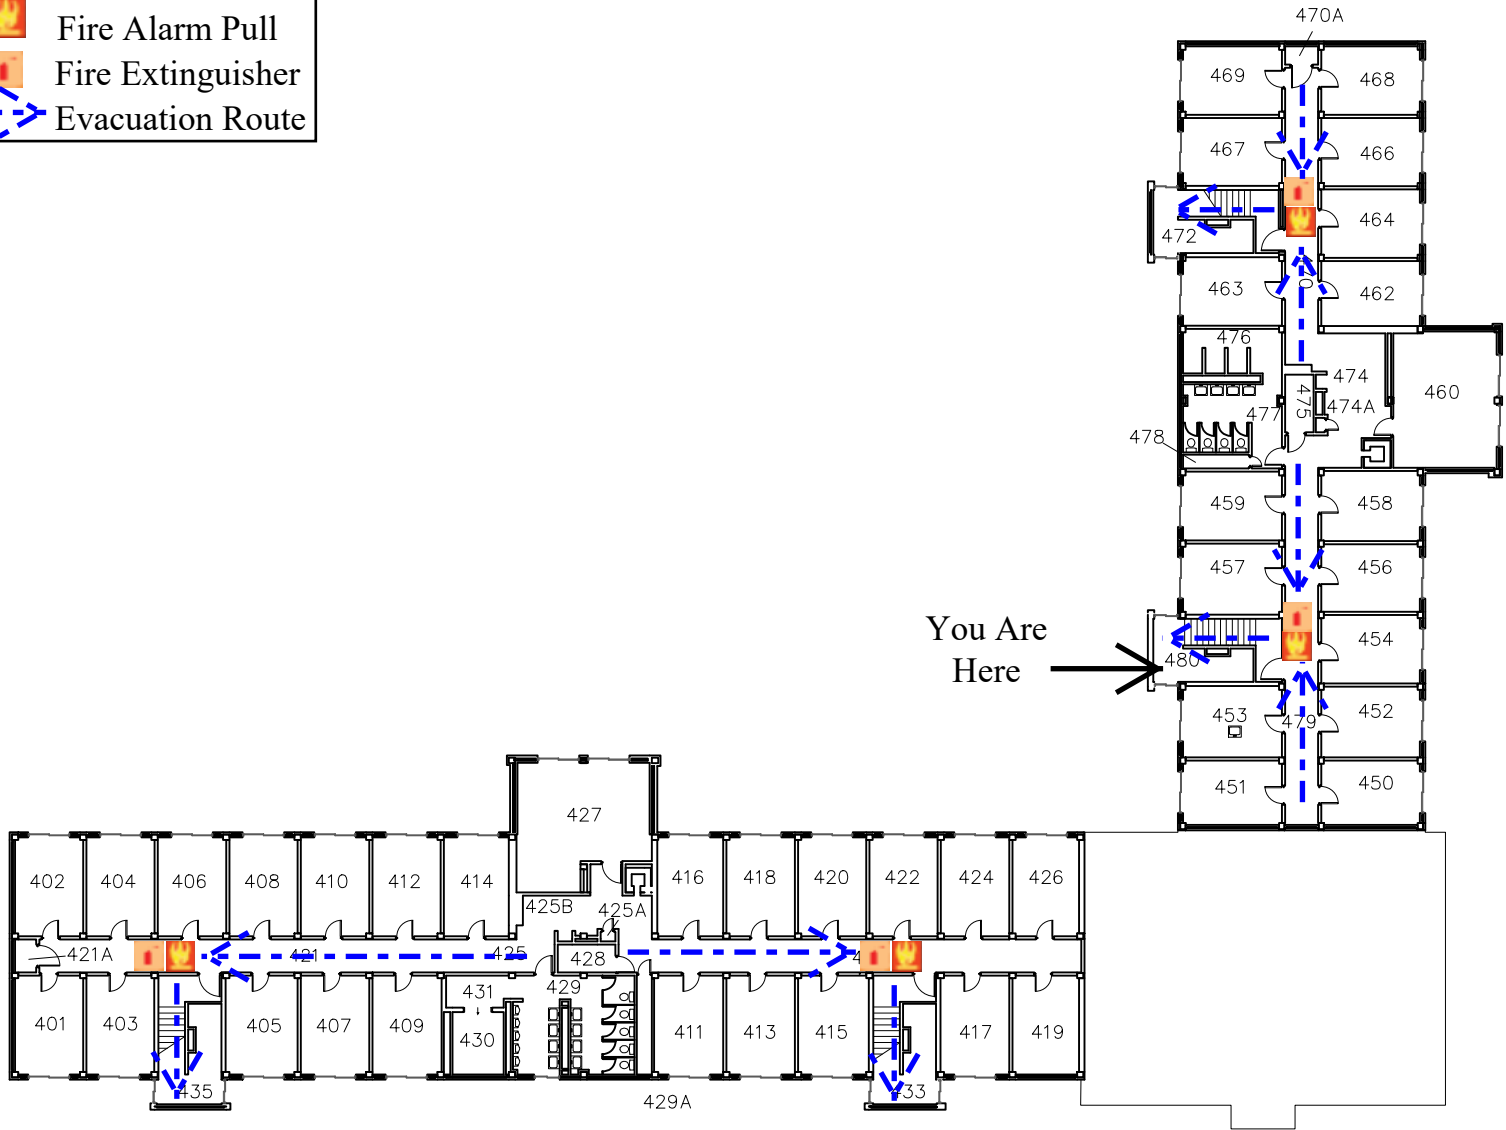

 Fire Alarm Pull
  Fire Extinguisher
  Evacuation Route

