






Fire Alarm Pull

Fire Extinguisher


Evacuation Route

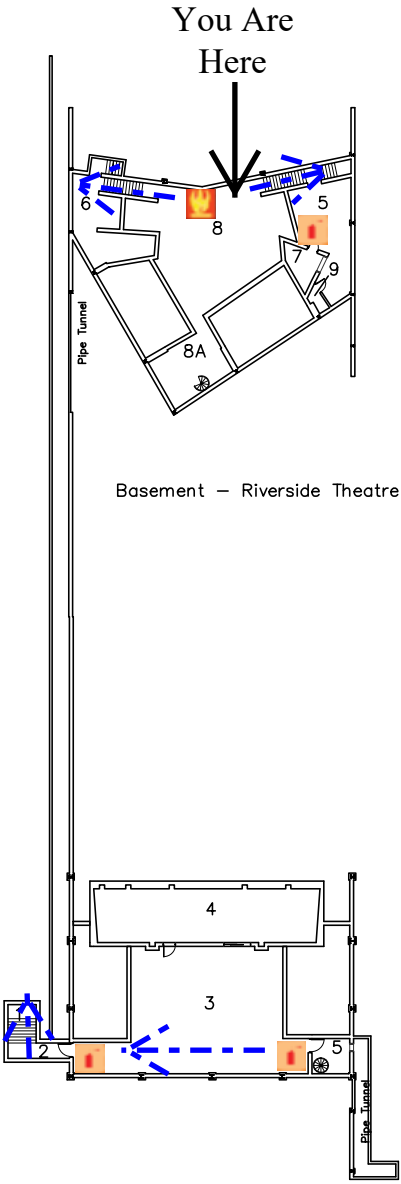


 Fire Alarm Pull


 Fire Extinguisher


 Evacuation Route

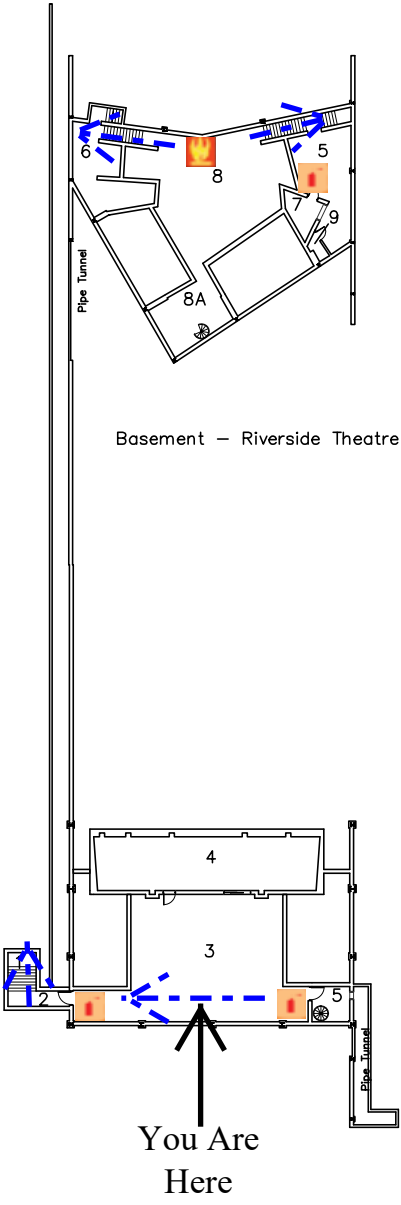


University of Wisconsin-Eau Claire      Facilities Planning

# Haas Fine Arts Building Basement Plan

DATE:  
 Oct 2021  
 DWG NO:  
 2



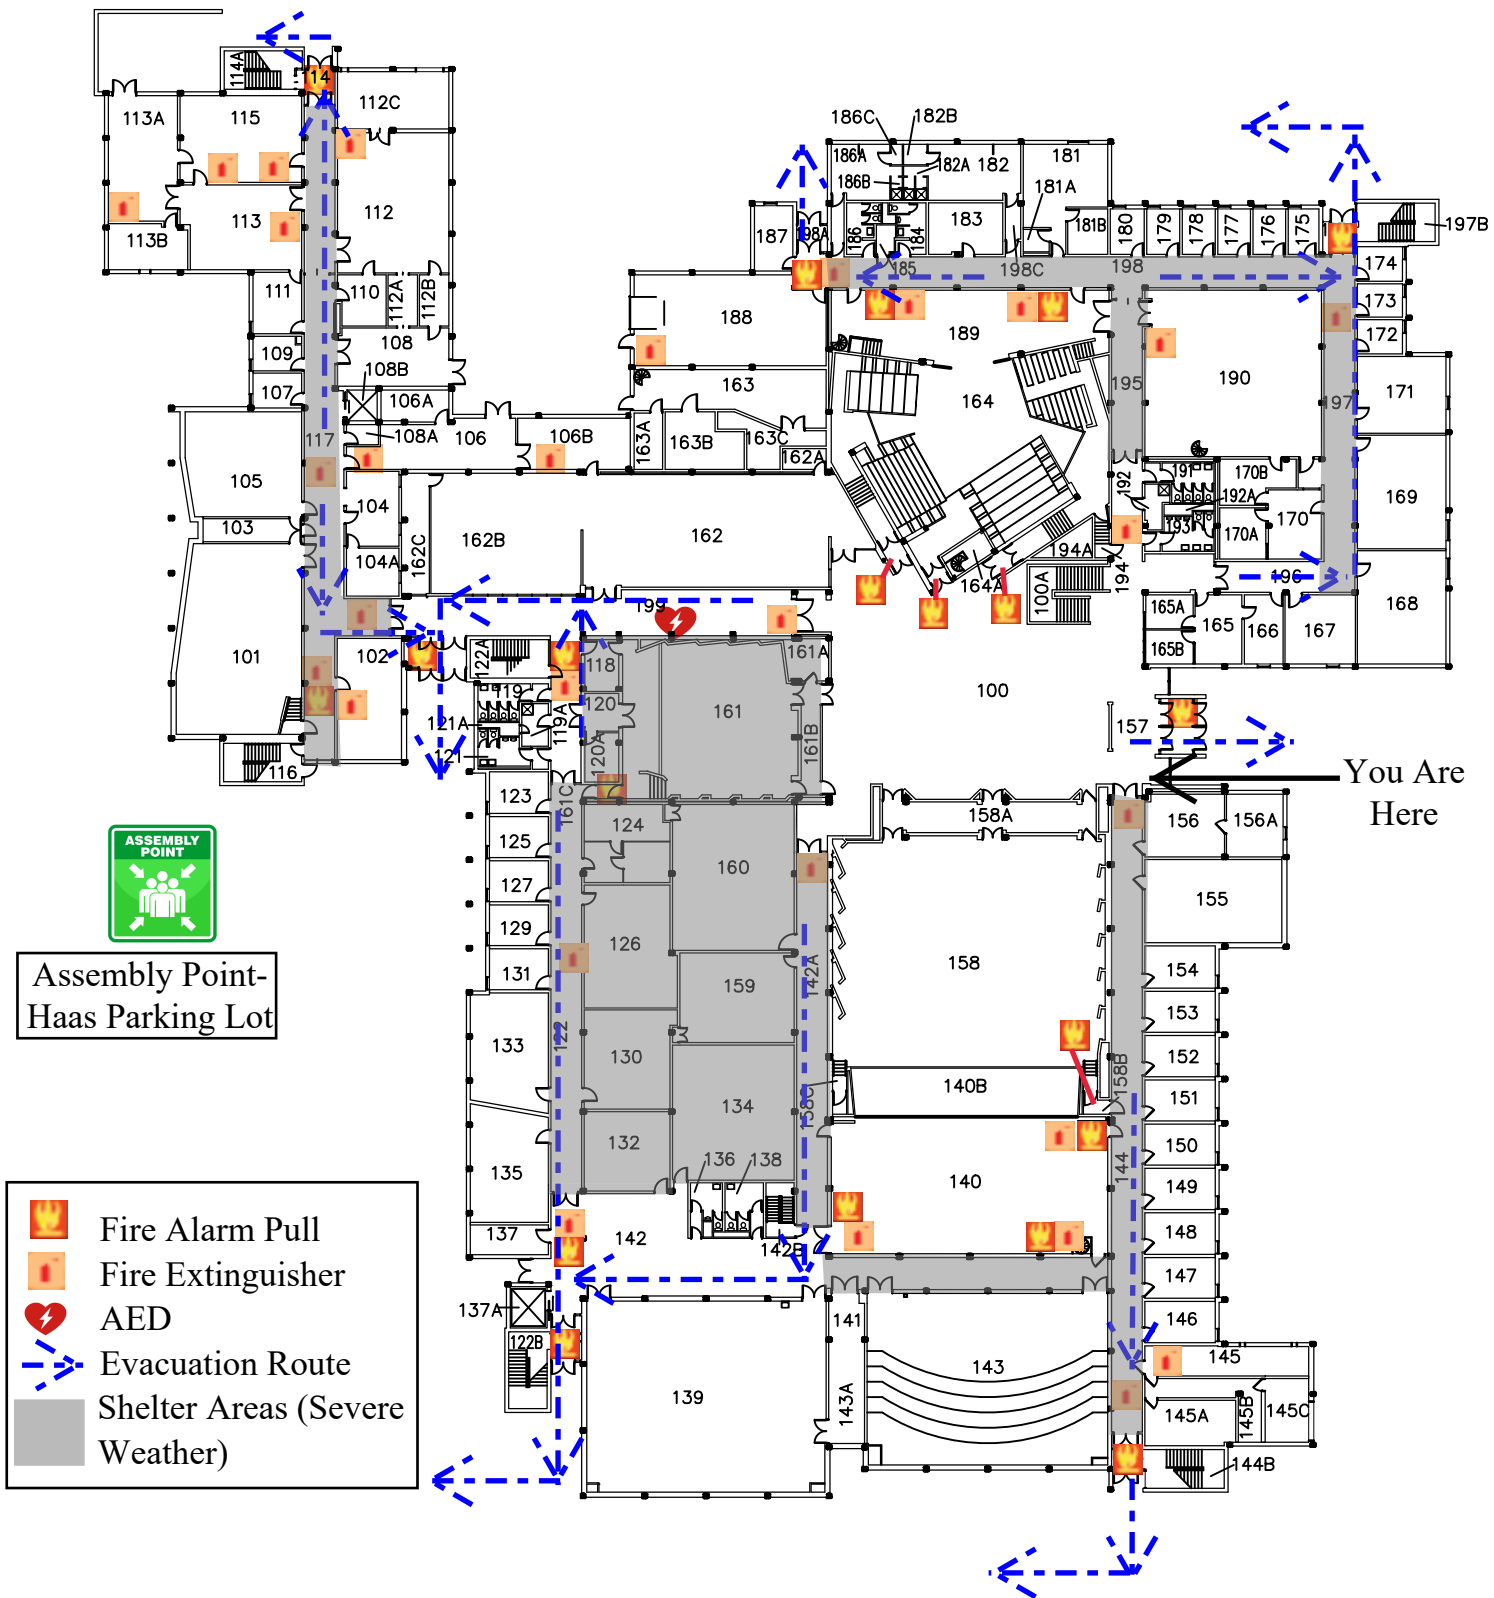

University of Wisconsin-Eau Claire

Facilities Planning

# Haas Fine Arts Building First Floor Plan


DATE:

Oct 2021

DWG NO:

1



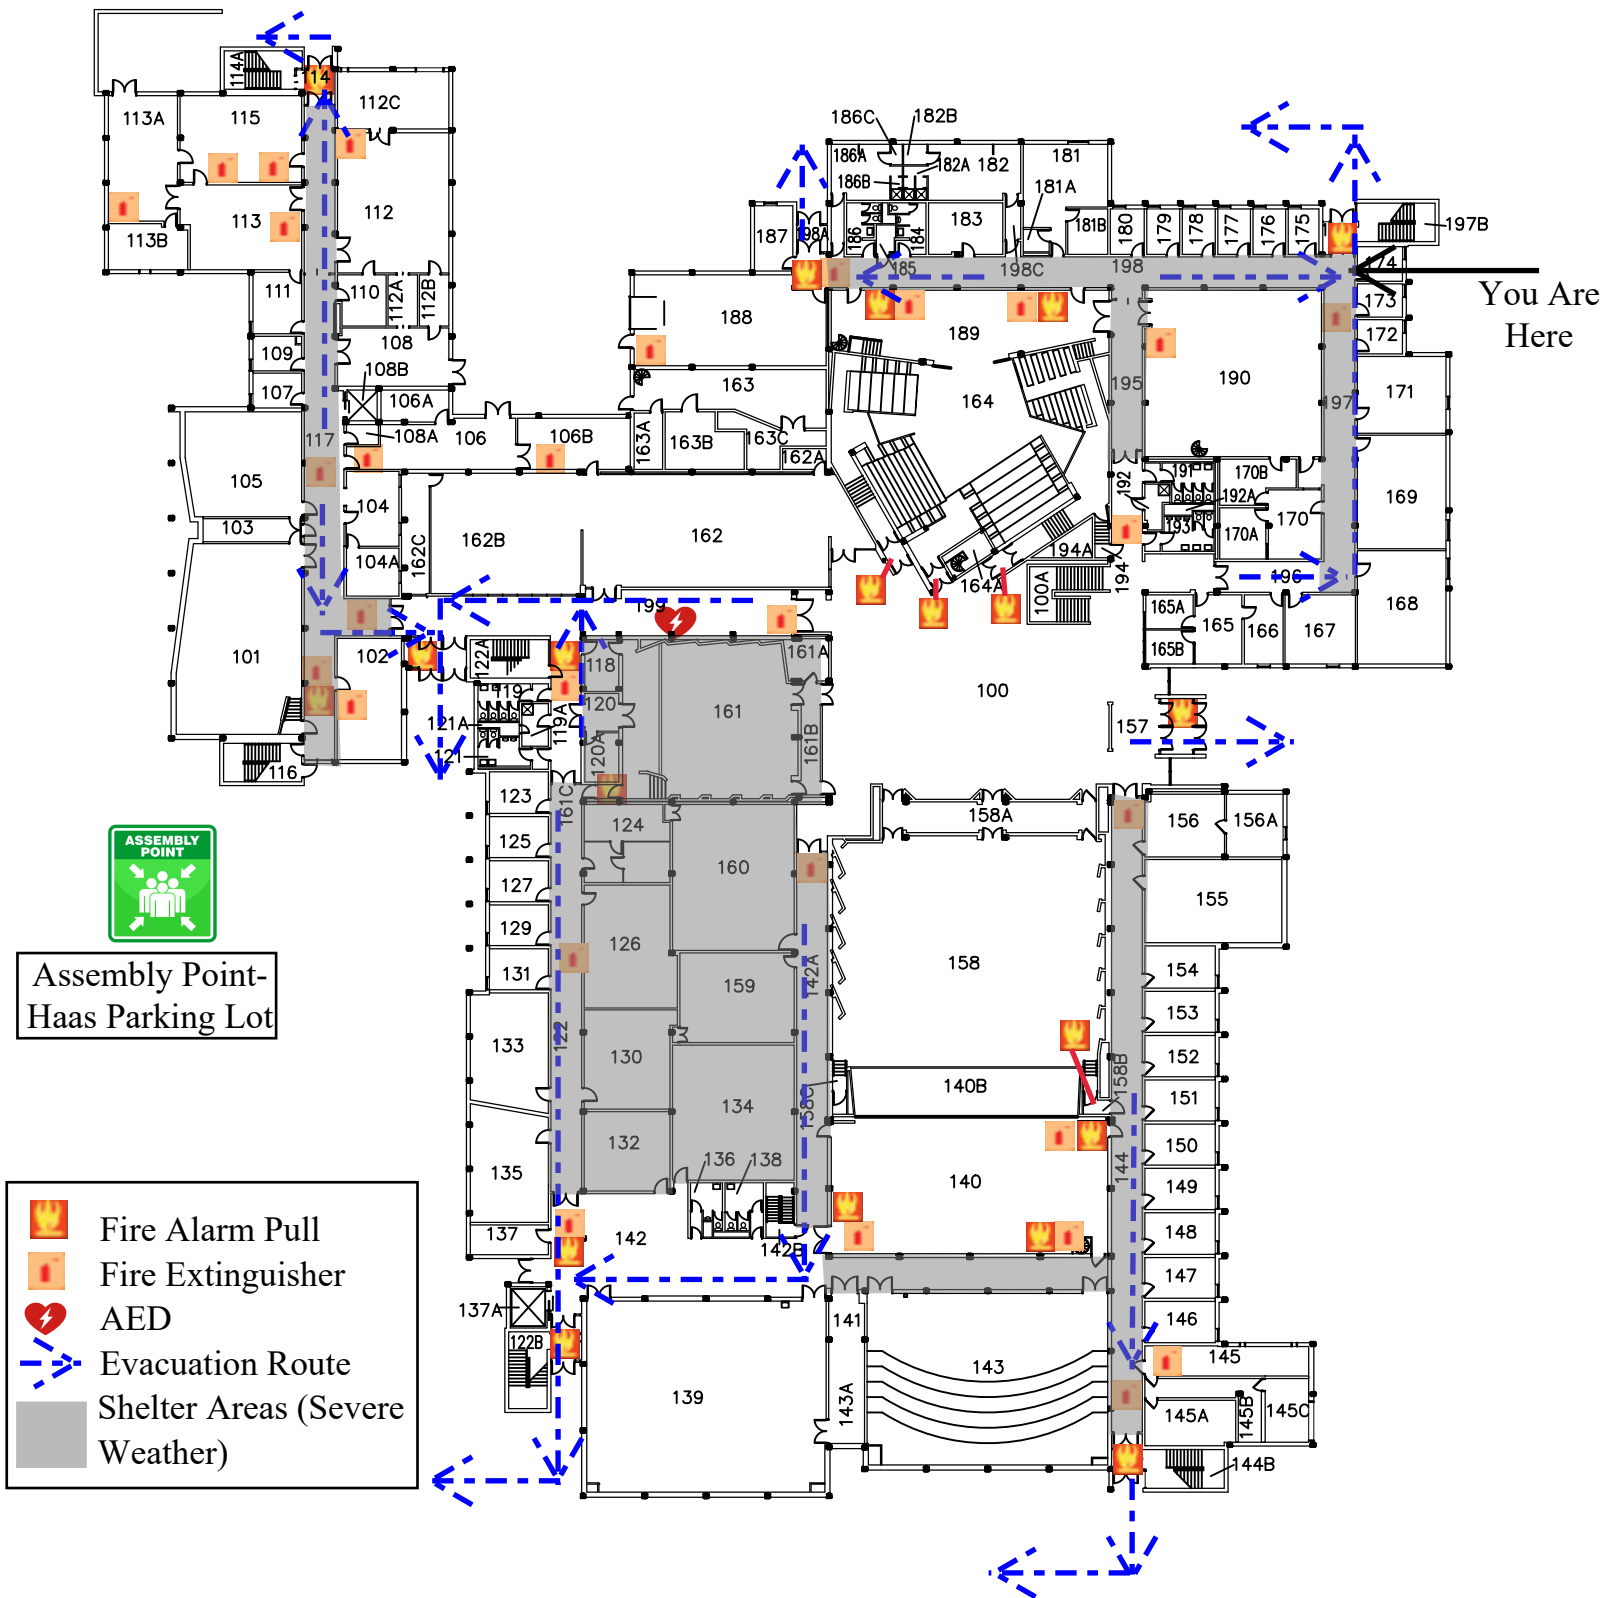

University of Wisconsin-Eau Claire

Facilities Planning

# Haas Fine Arts Building First Floor Plan


DATE:

Oct 2021

DWG NO:

2



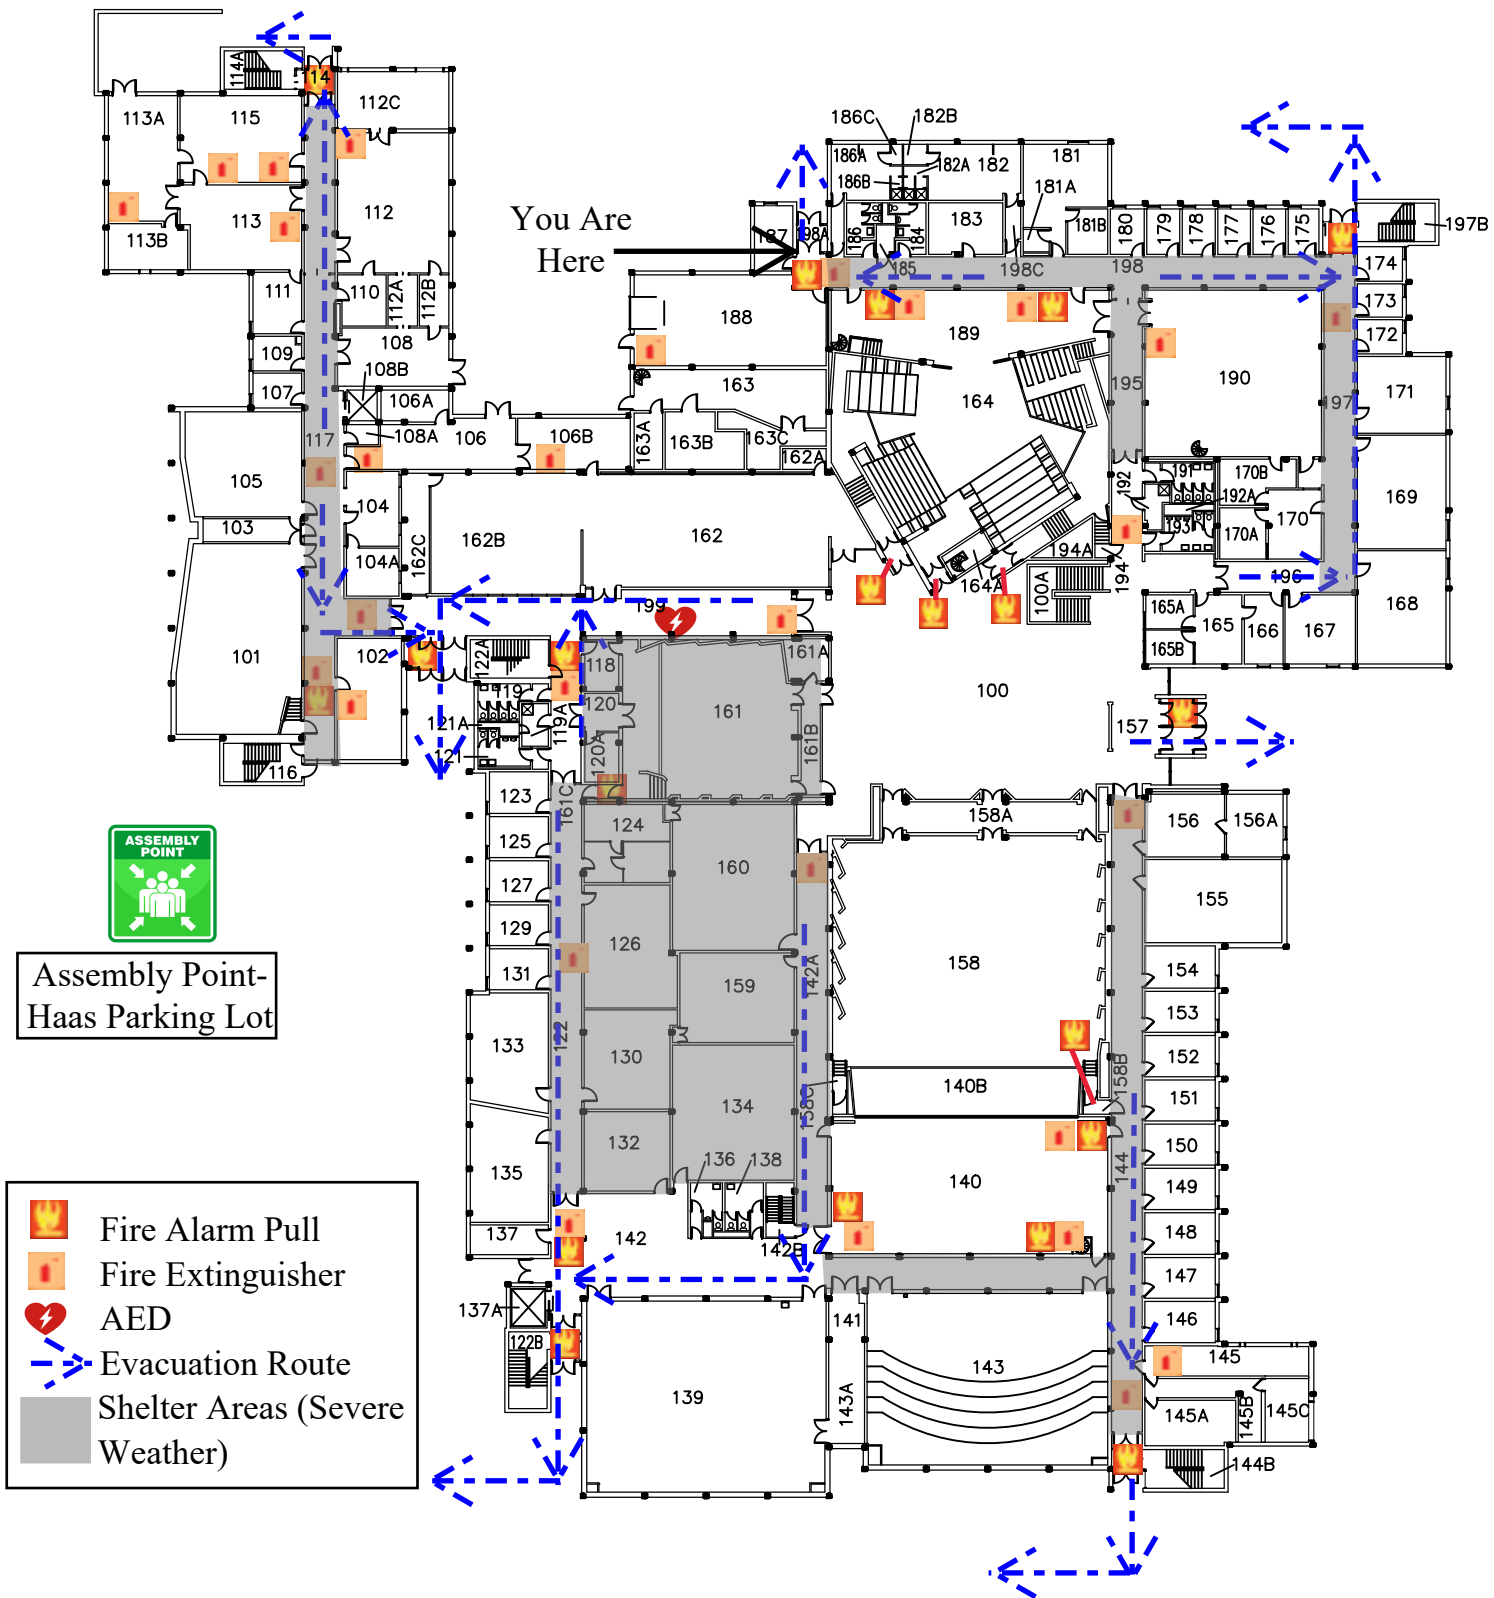

University of Wisconsin-Eau Claire

Facilities Planning

# Haas Fine Arts Building First Floor Plan

DATE:


Oct 2021

DWG NO:

3





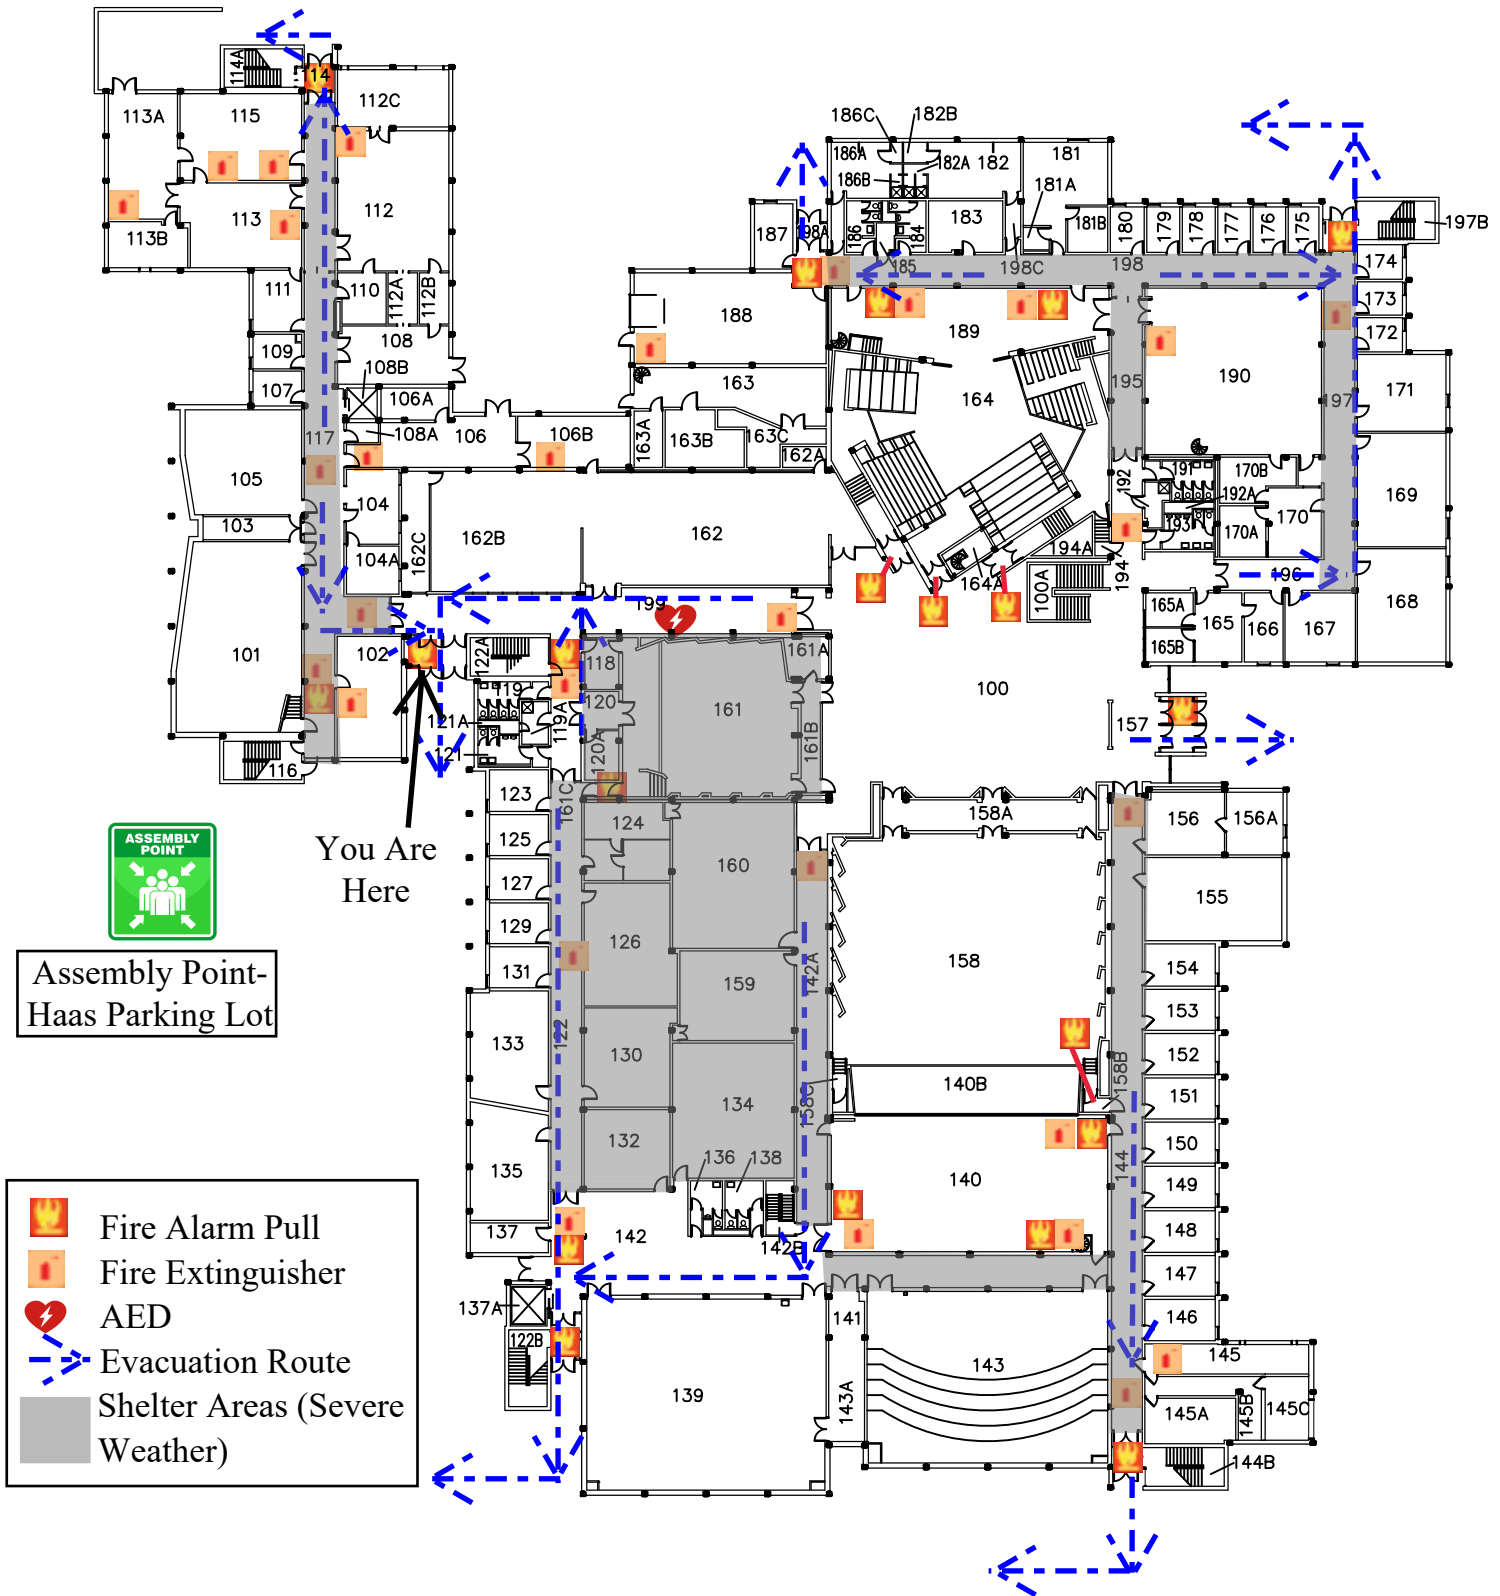

University of Wisconsin-Eau Claire

Facilities Planning

# Haas Fine Arts Building First Floor Plan

DATE:


Oct 2021

DWG NO:

5





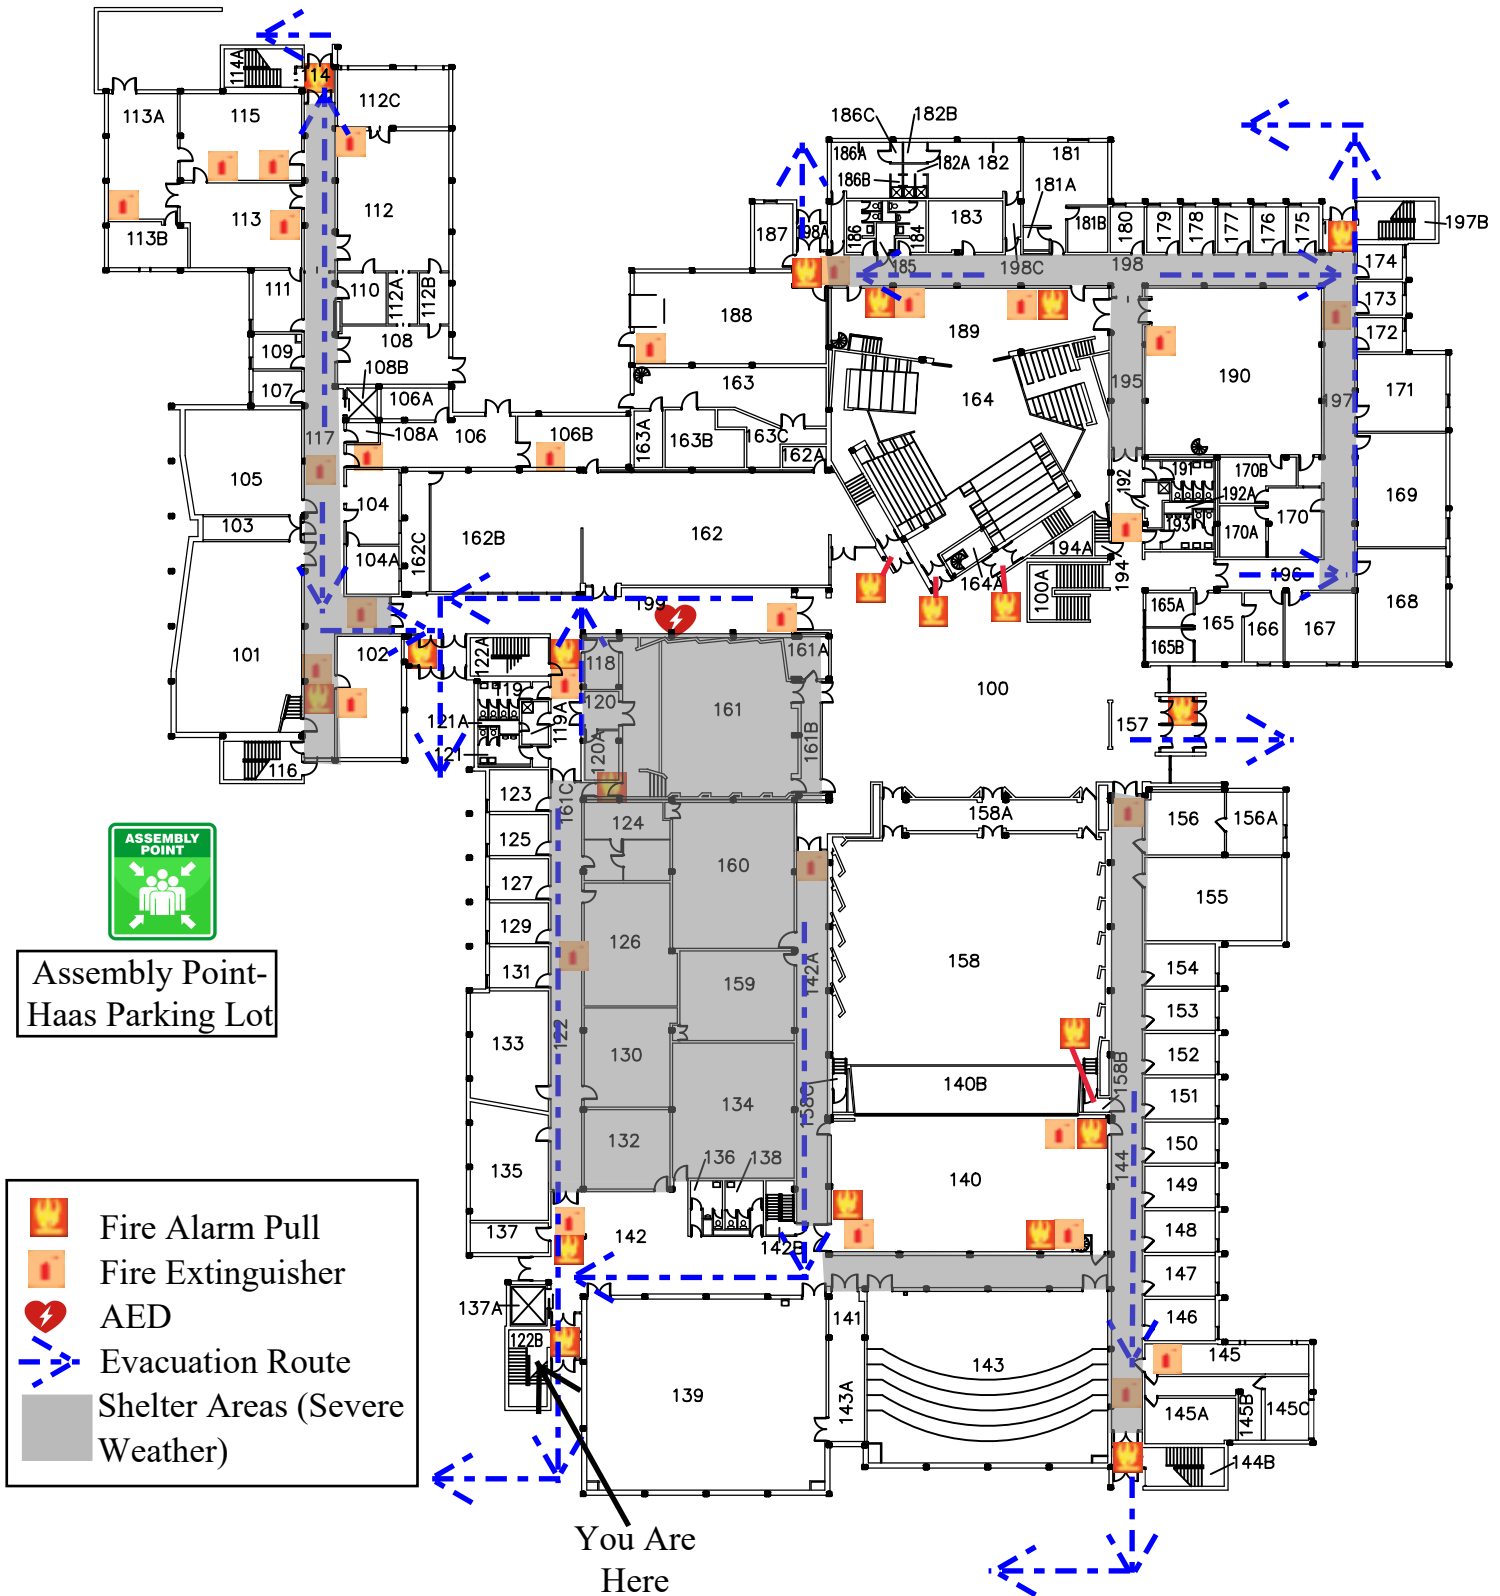

University of Wisconsin-Eau Claire

Facilities Planning

# Haas Fine Arts Building First Floor Plan

DATE:

Oct 2021


DWG NO:

6







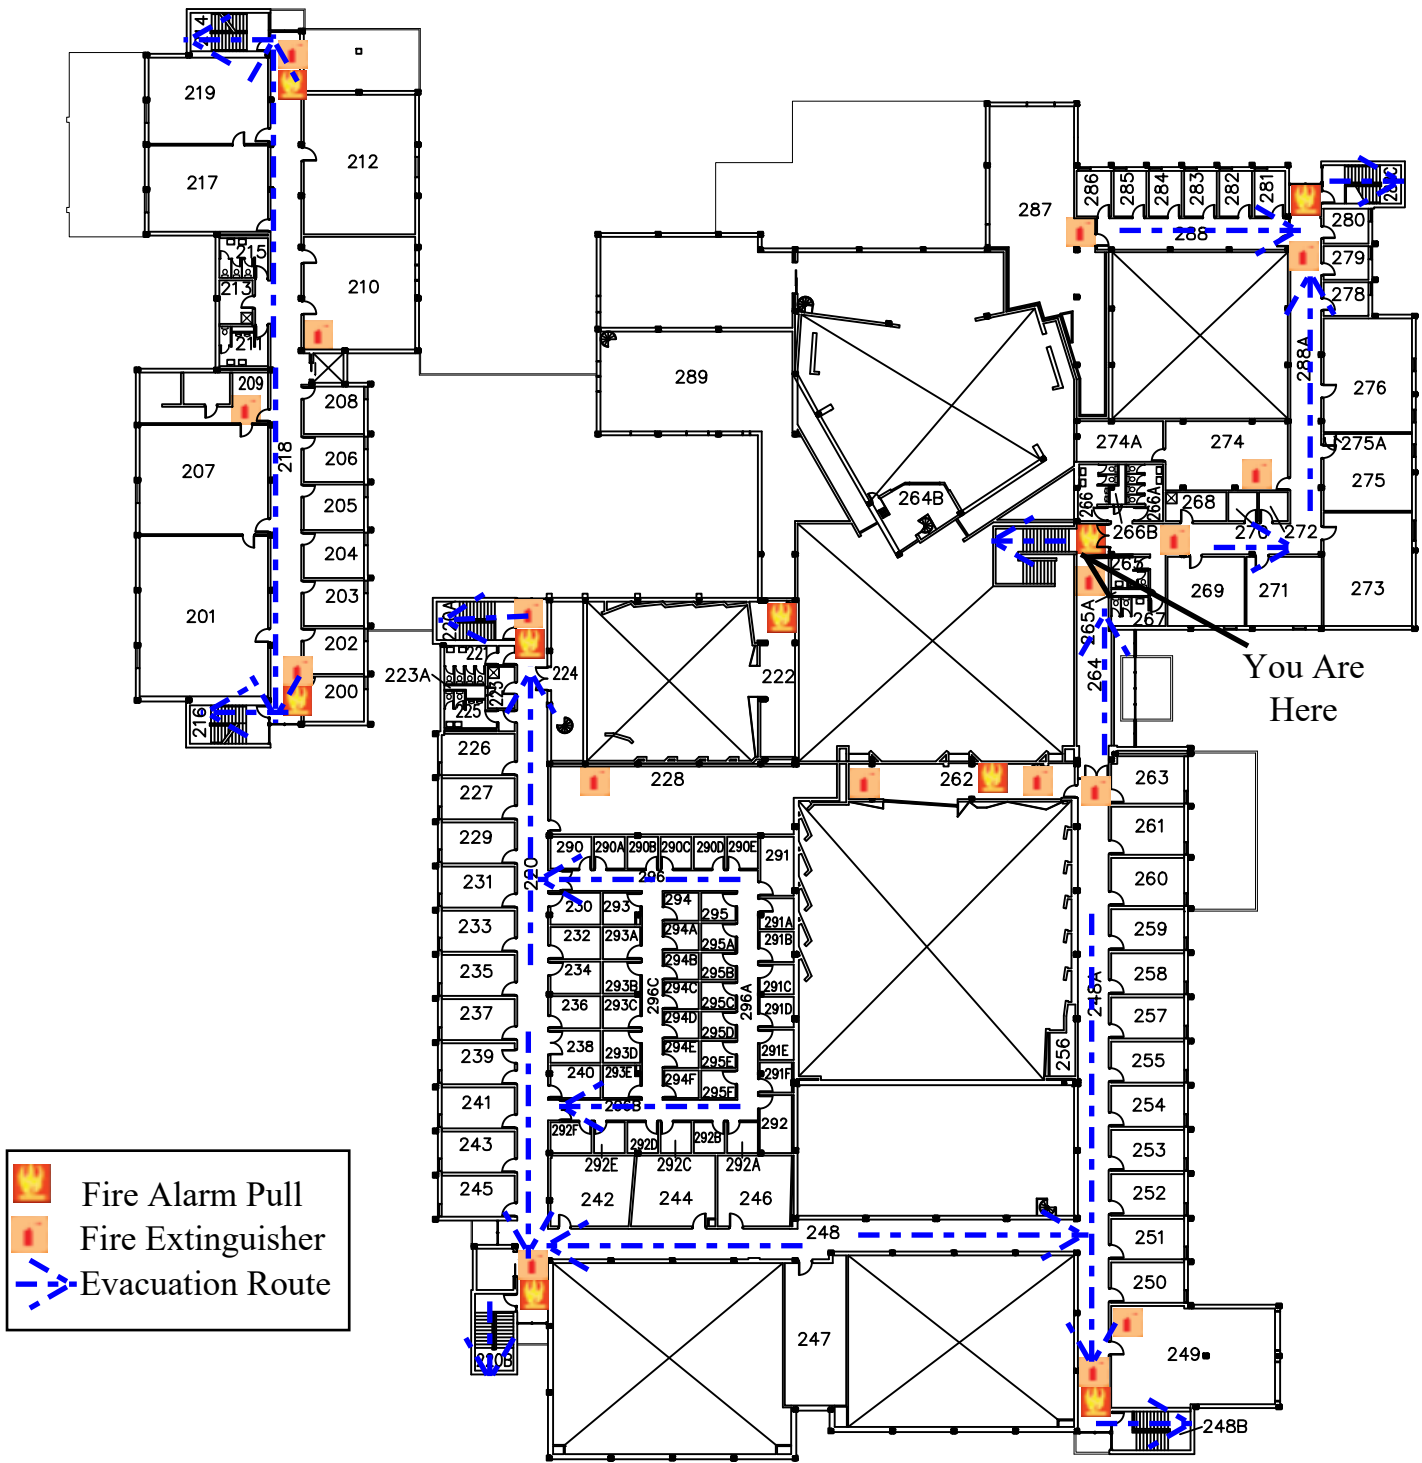

University of Wisconsin-Eau Claire

Facilities Planning

# Haas Fine Arts Building Second Floor


DATE:

Oct 2021

DWG NO:

1



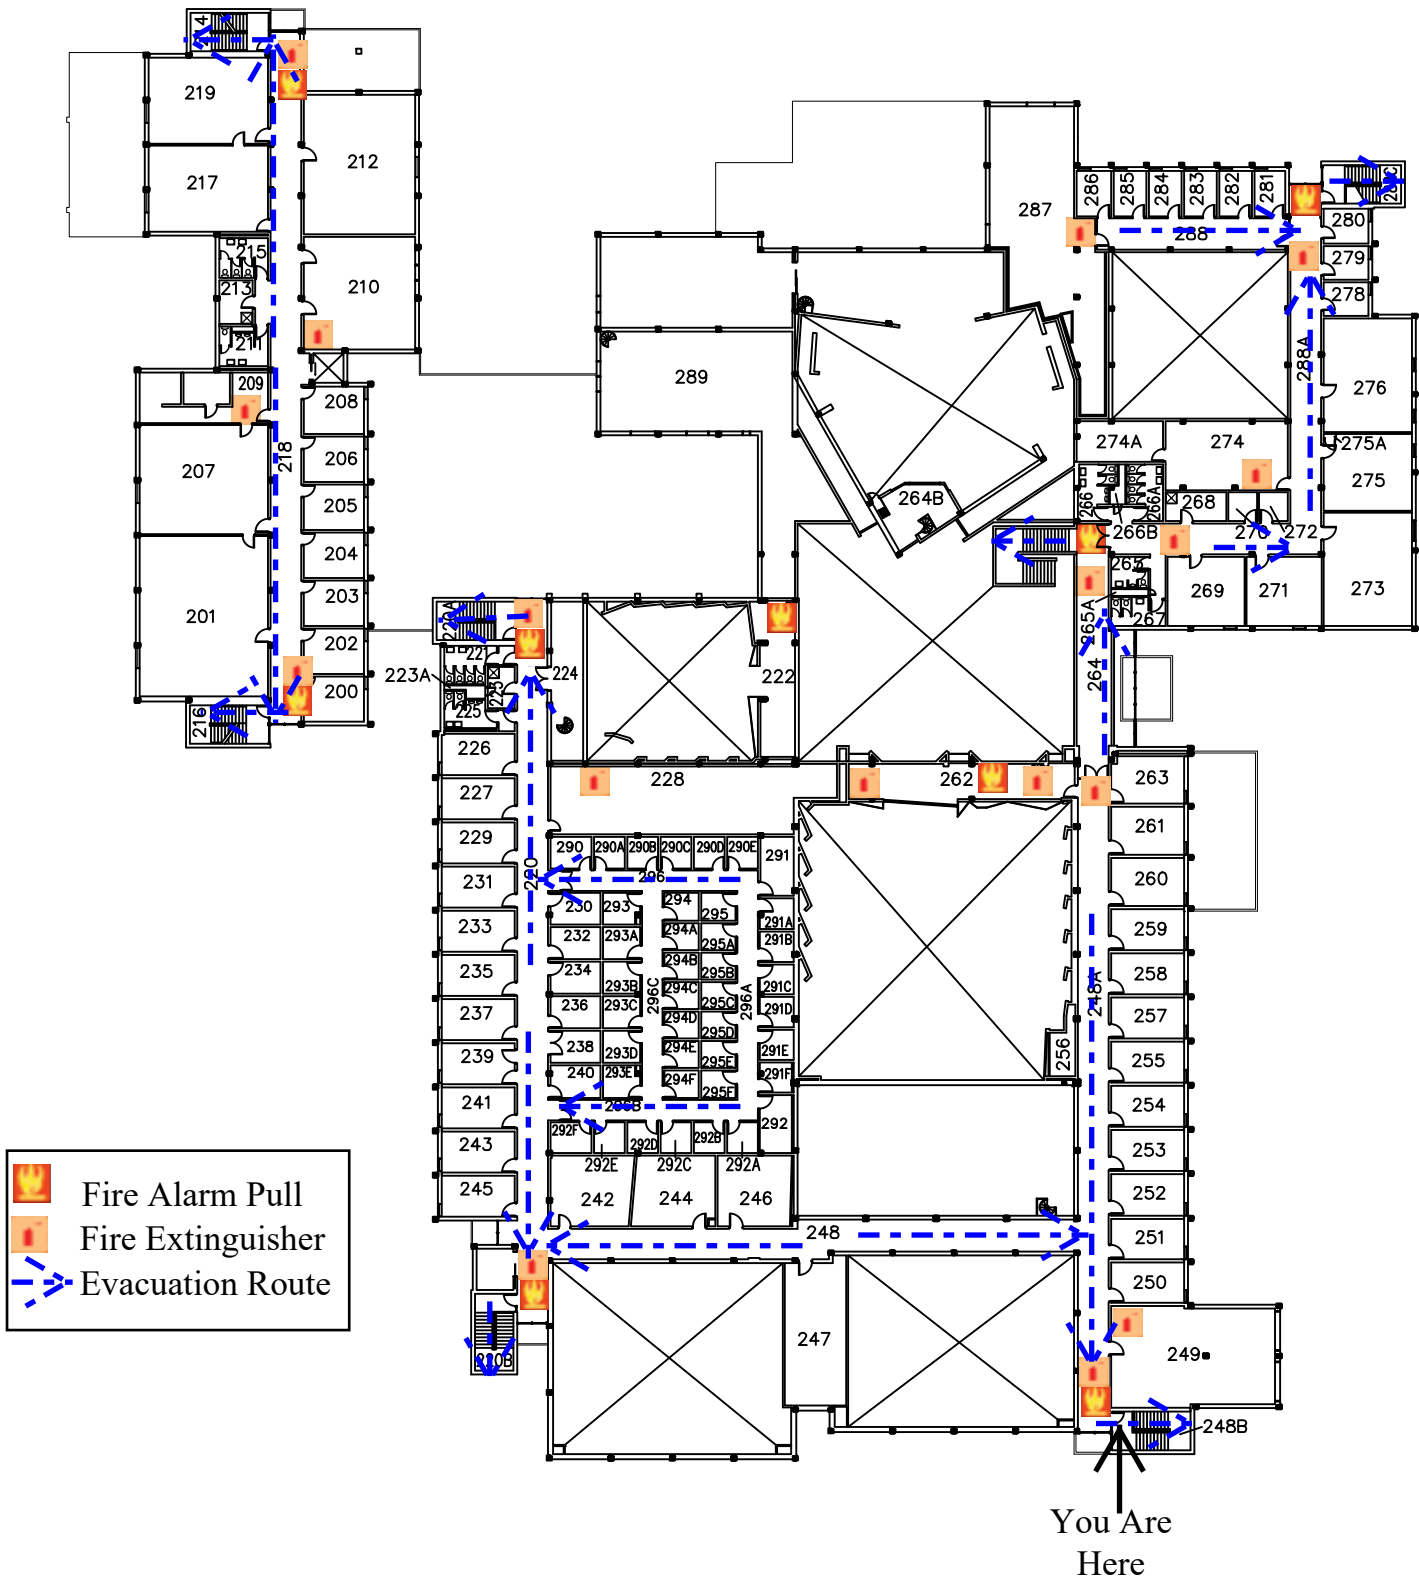

University of Wisconsin-Eau Claire

Facilities Planning

# Haas Fine Arts Building Second Floor


DATE:

Oct 2021

DWG NO:

2



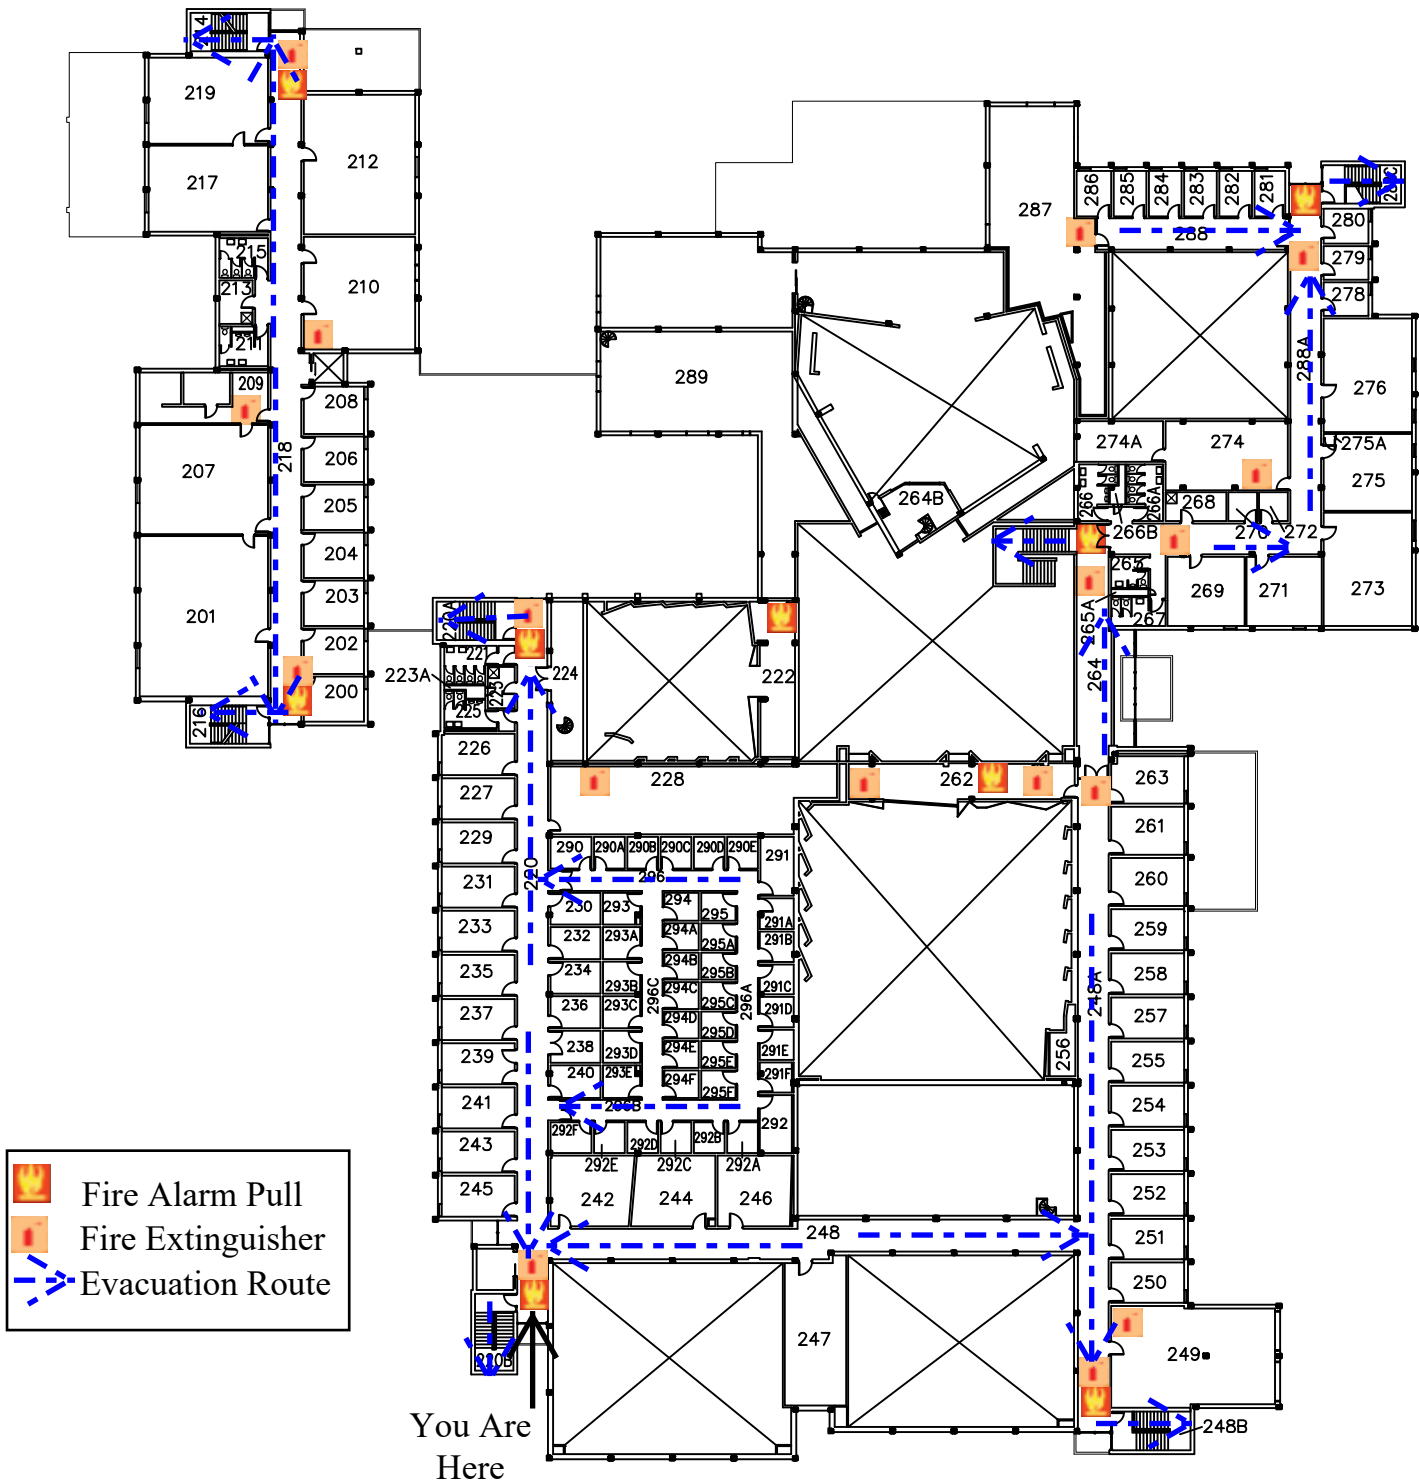

University of Wisconsin-Eau Claire

Facilities Planning

# Haas Fine Arts Building Second Floor


DATE:

Oct 2021

DWG NO:

3



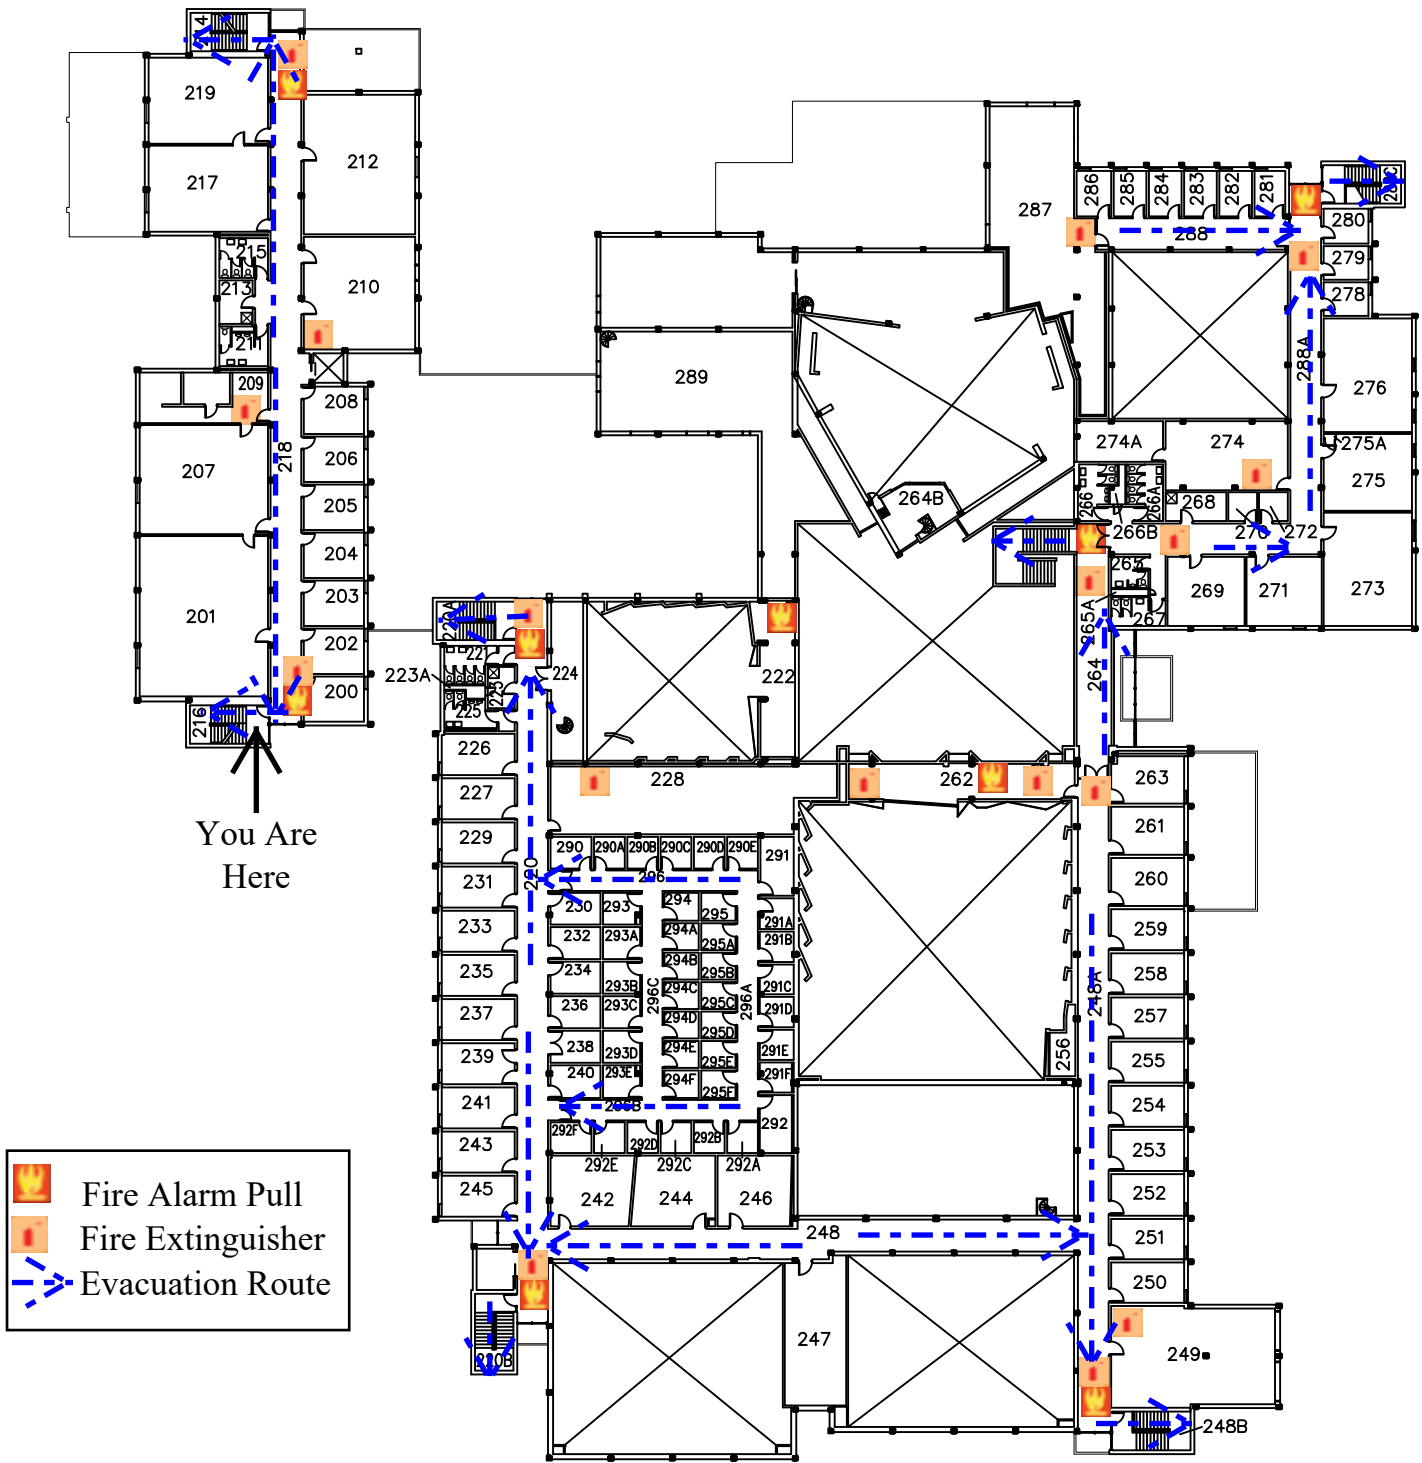

University of Wisconsin-Eau Claire

Facilities Planning

# Haas Fine Arts Building Second Floor


DATE:


Oct 2021

DWG NO:

4



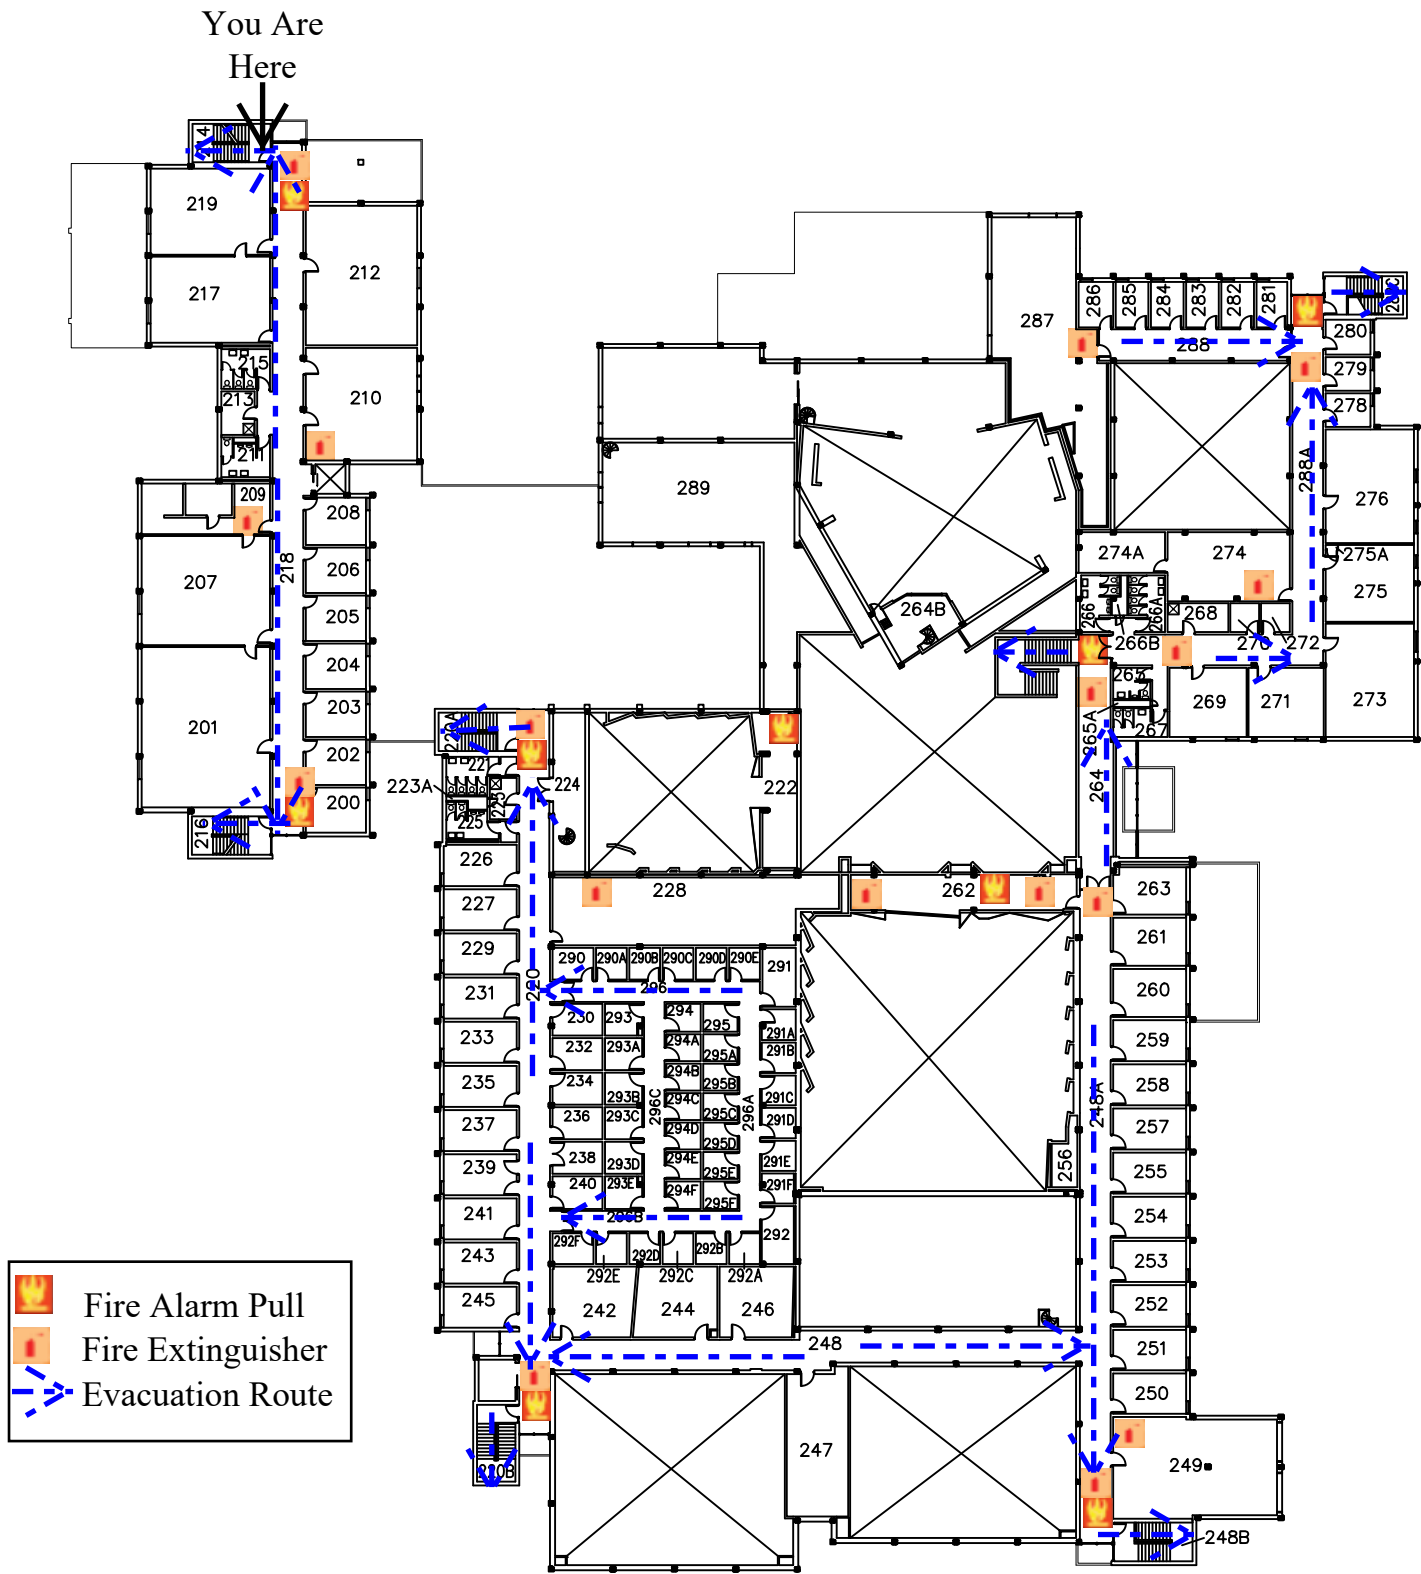

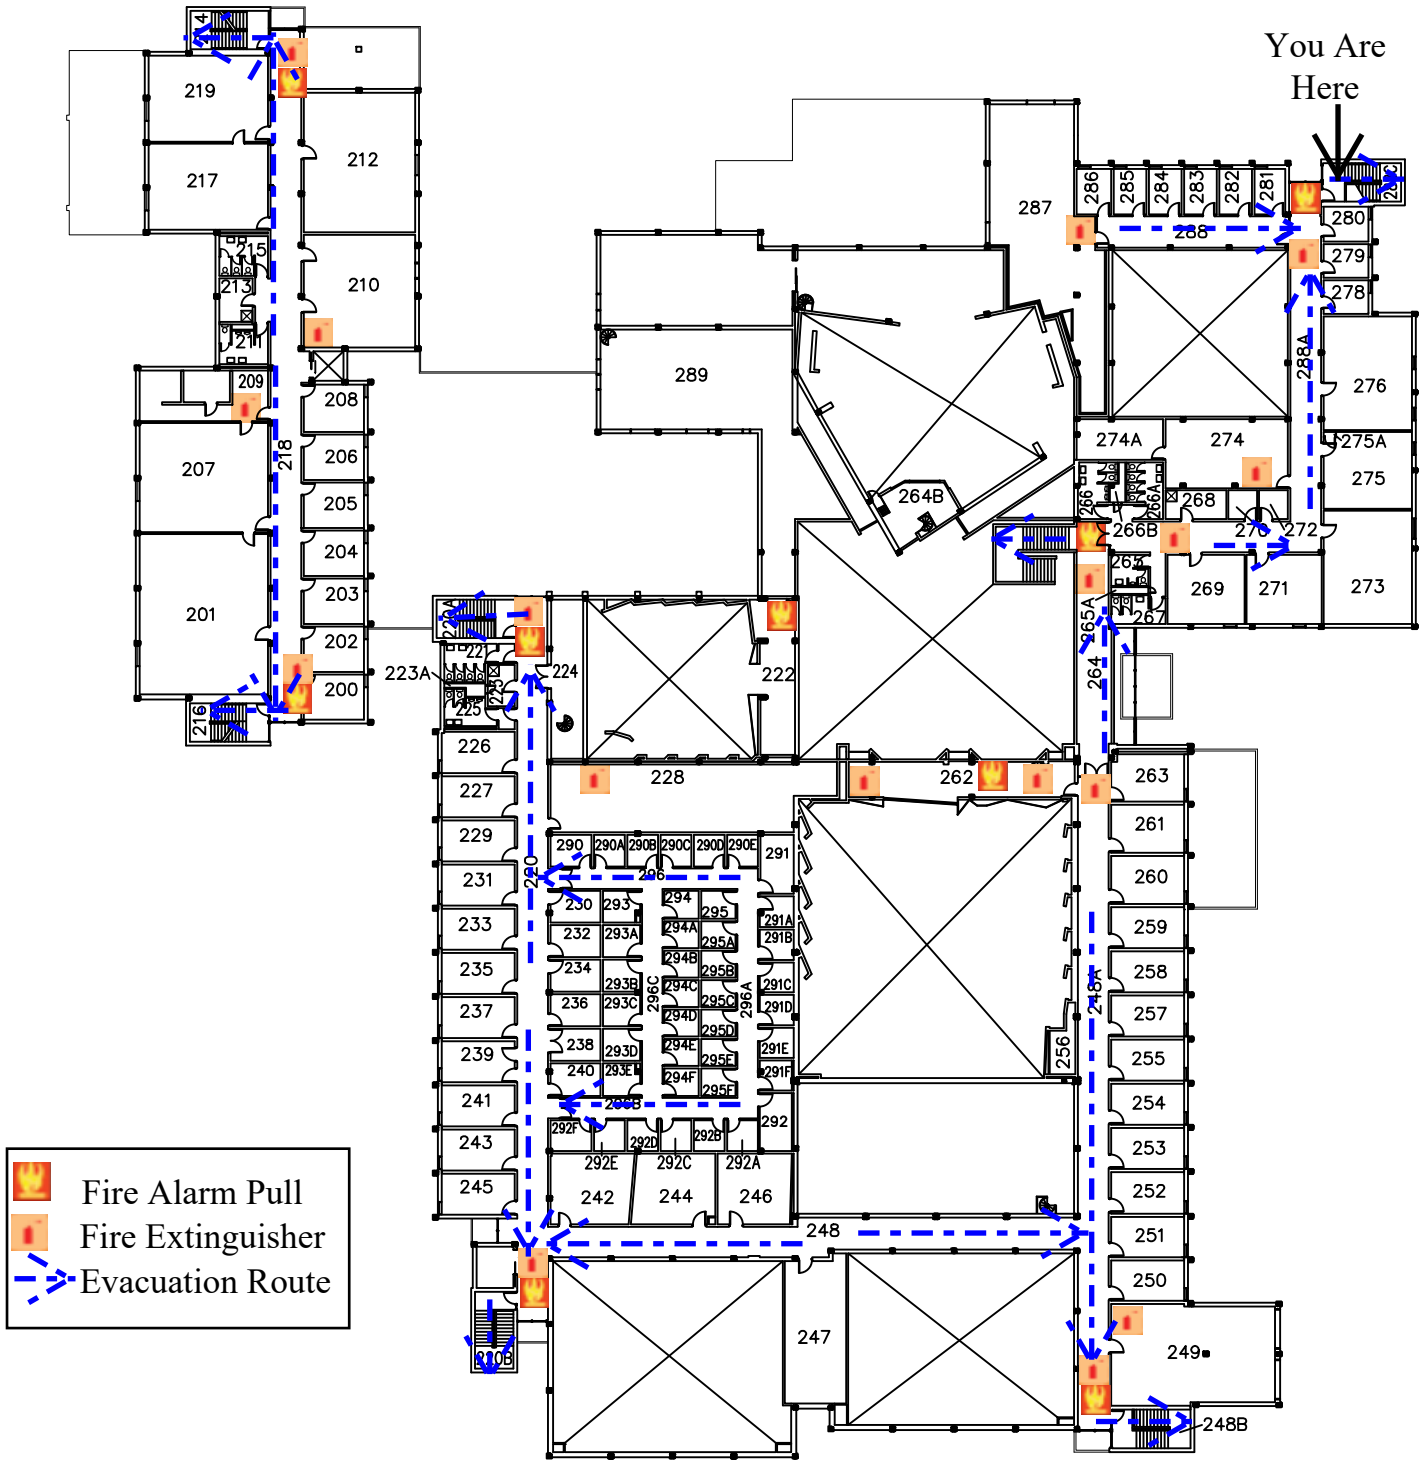

University of Wisconsin-Eau Claire

Facilities Planning

# Haas Fine Arts Building Second Floor

DATE:


Oct 2021

DWG NO:

6





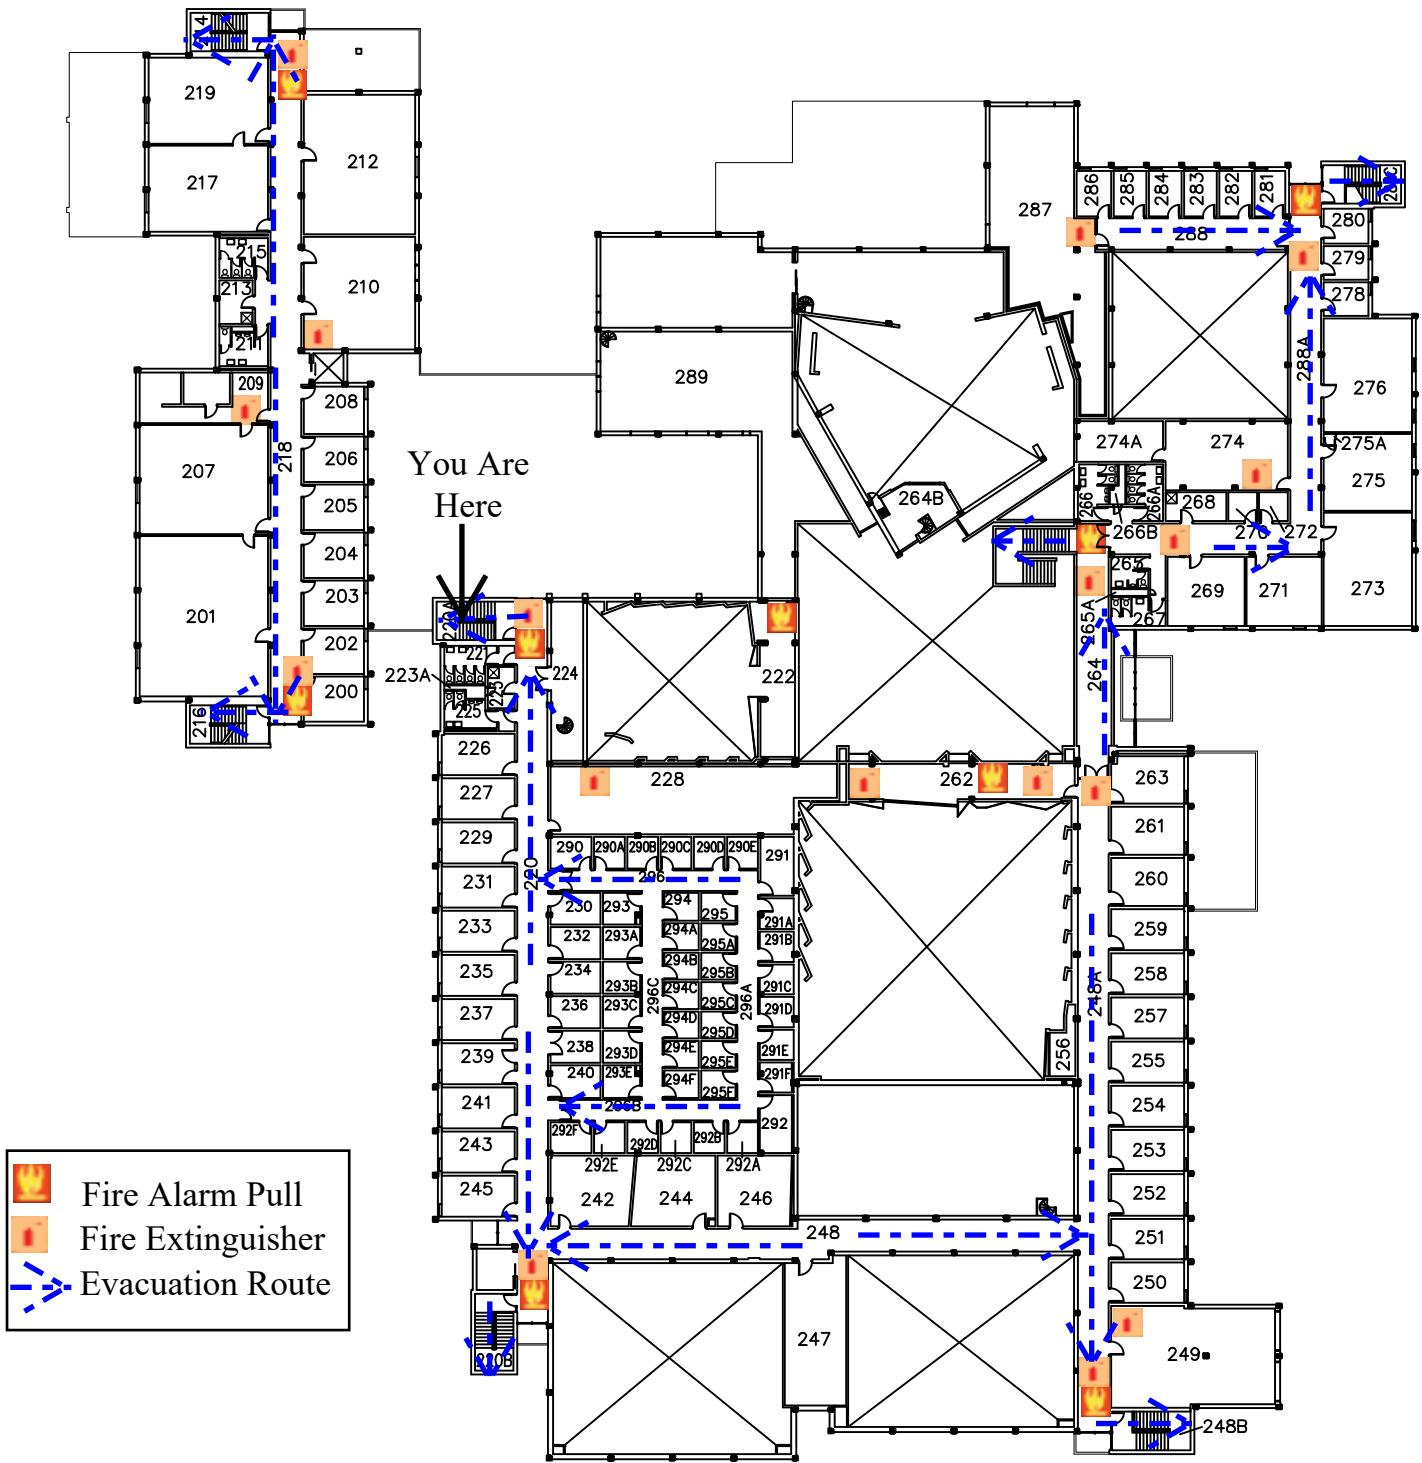

University of Wisconsin-Eau Claire

Facilities Planning

# Haas Fine Arts Building Second Floor


DATE:

Oct 2021

DWG NO:

7



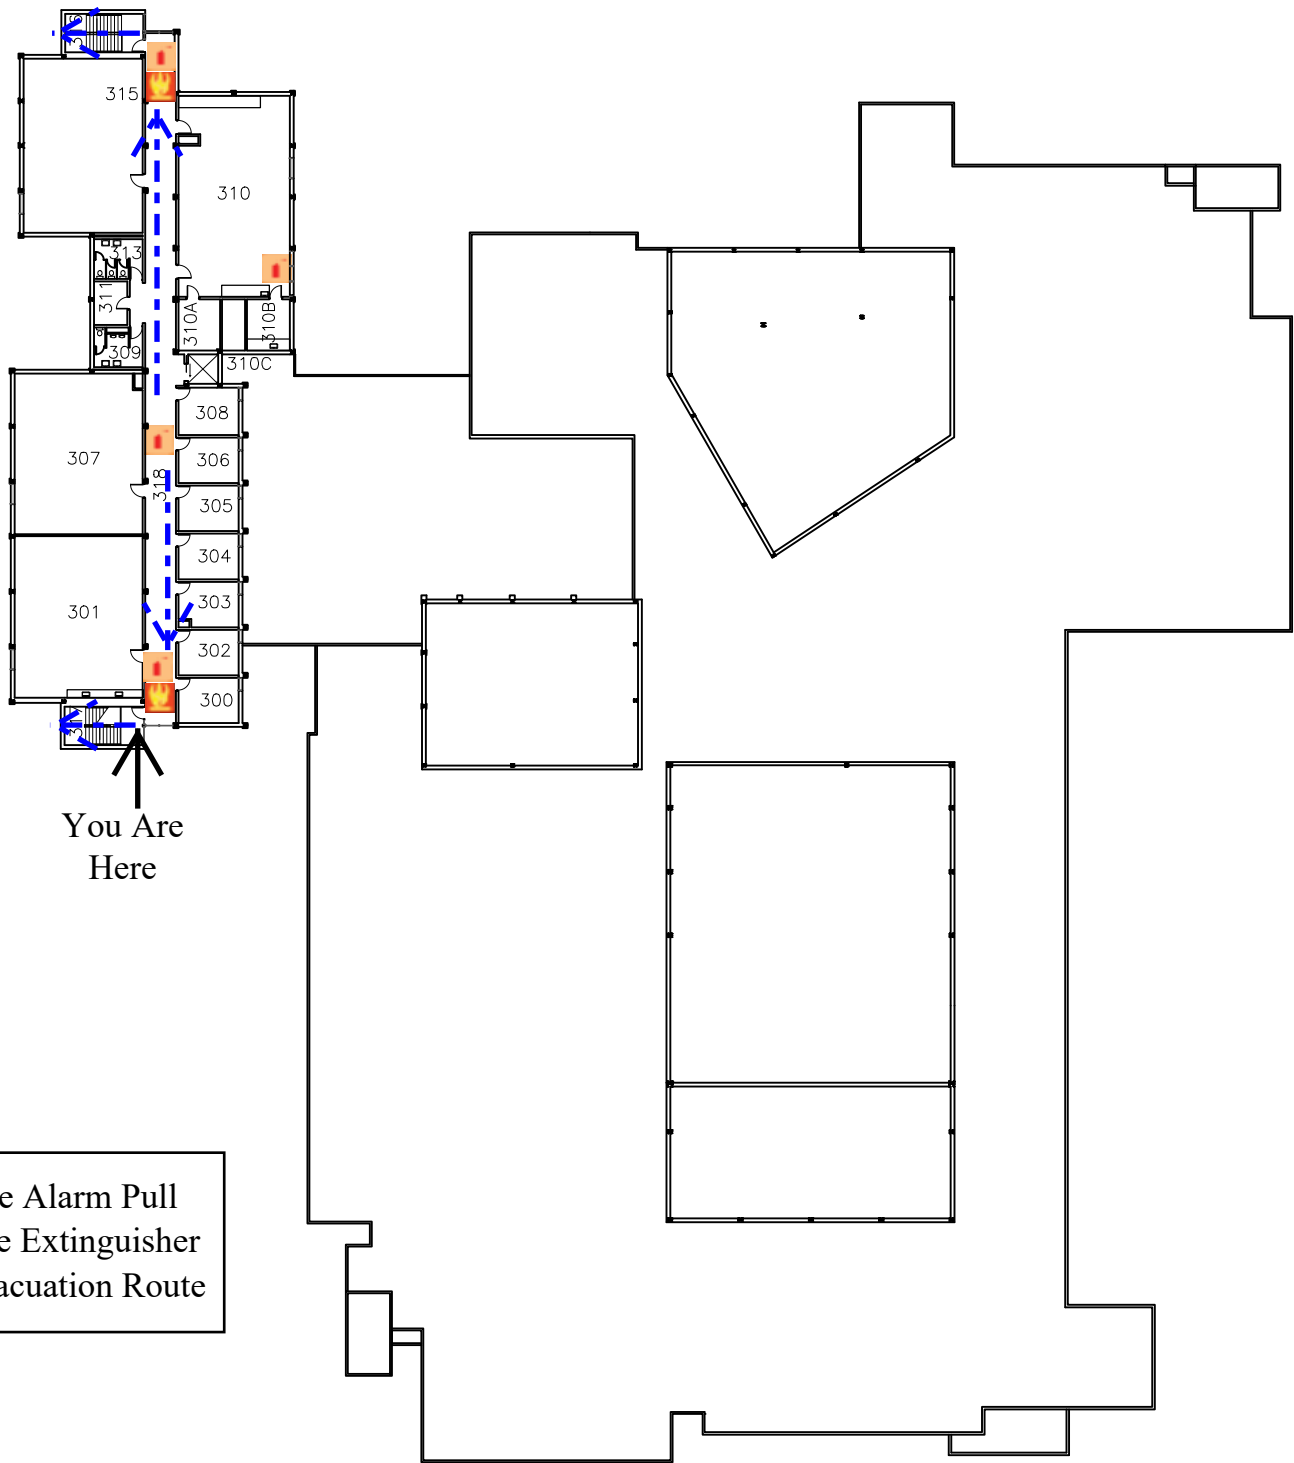

|                                                                                    |                   |
|------------------------------------------------------------------------------------|-------------------|
|  | Fire Alarm Pull   |
|  | Fire Extinguisher |
|  | Evacuation Route  |



University of Wisconsin-Eau Claire

Facilities Planning

# Haas Fine Arts Building Third Floor

DATE:


Oct 2021

DWG NO:

1



You Are  
Here

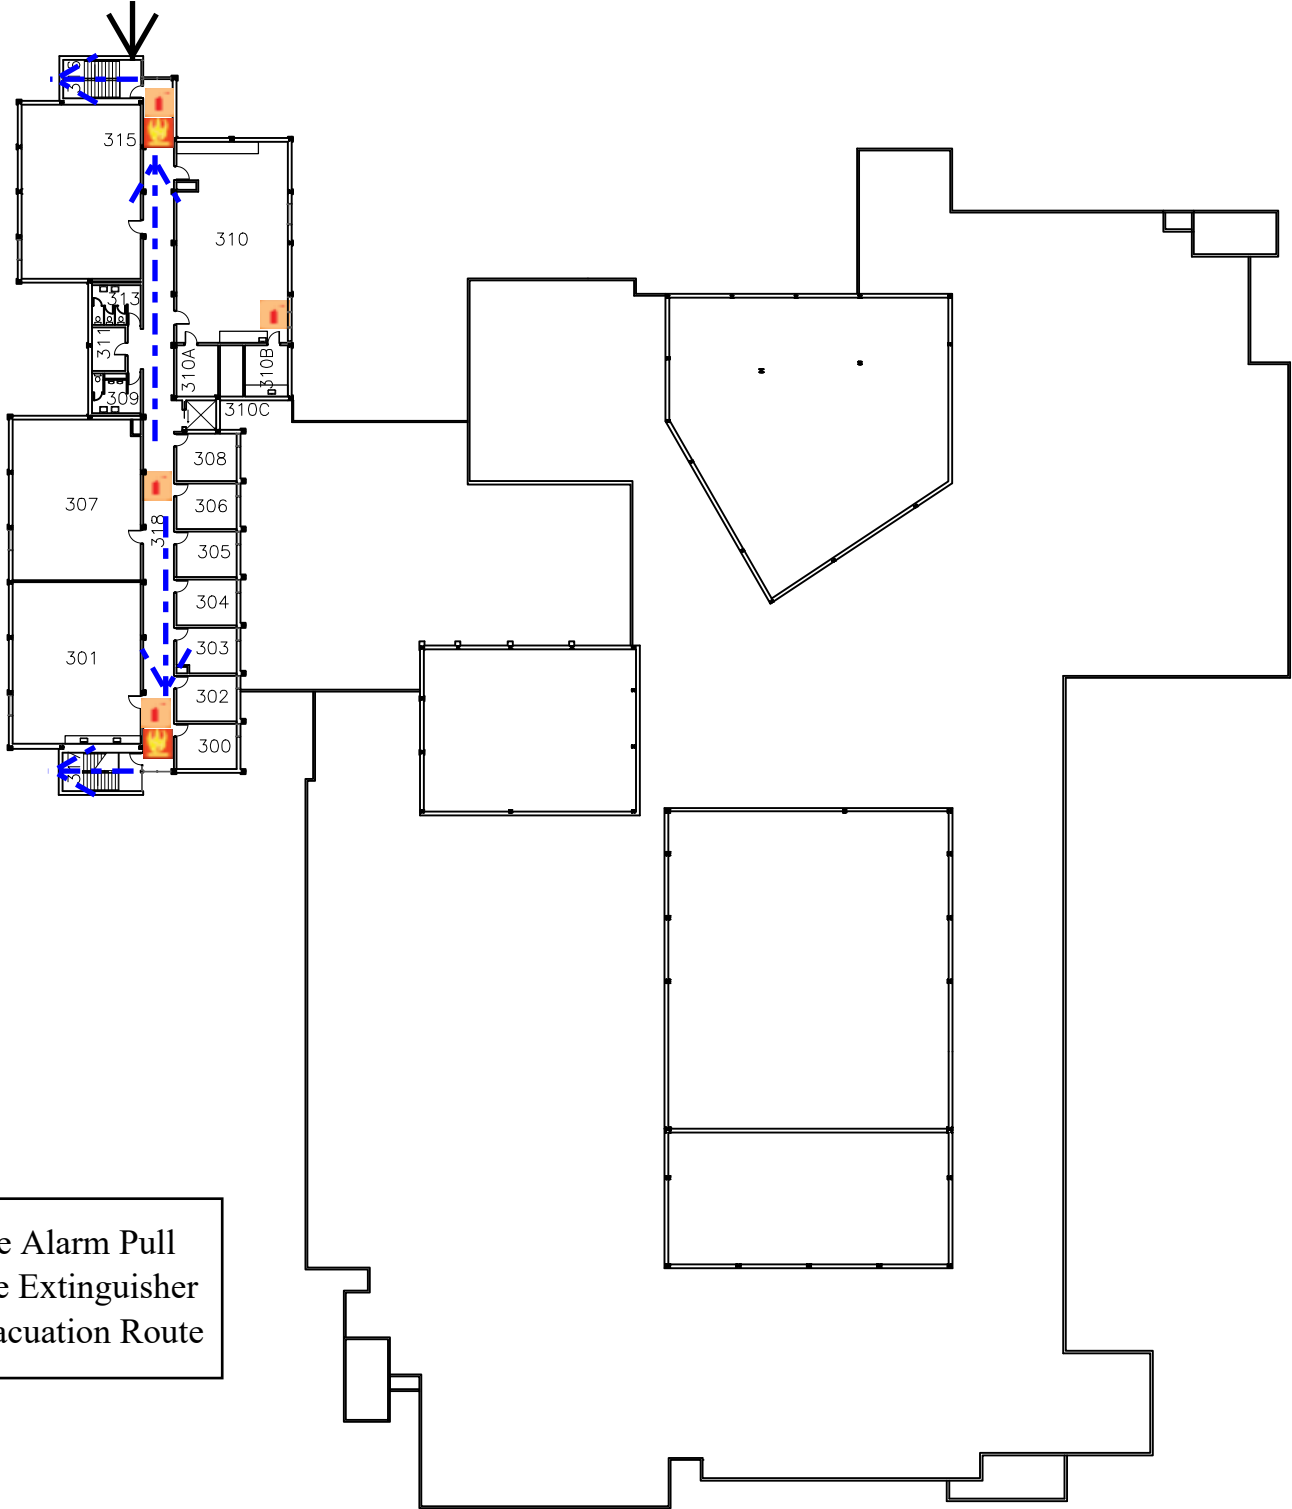

|                                                                                    |                   |
|------------------------------------------------------------------------------------|-------------------|
|  | Fire Alarm Pull   |
|  | Fire Extinguisher |
|  | Evacuation Route  |



University of Wisconsin-Eau Claire

Facilities Planning

# Haas Fine Arts Building Third Floor

DATE:

Oct 2021

DWG NO:

2



NORTH