




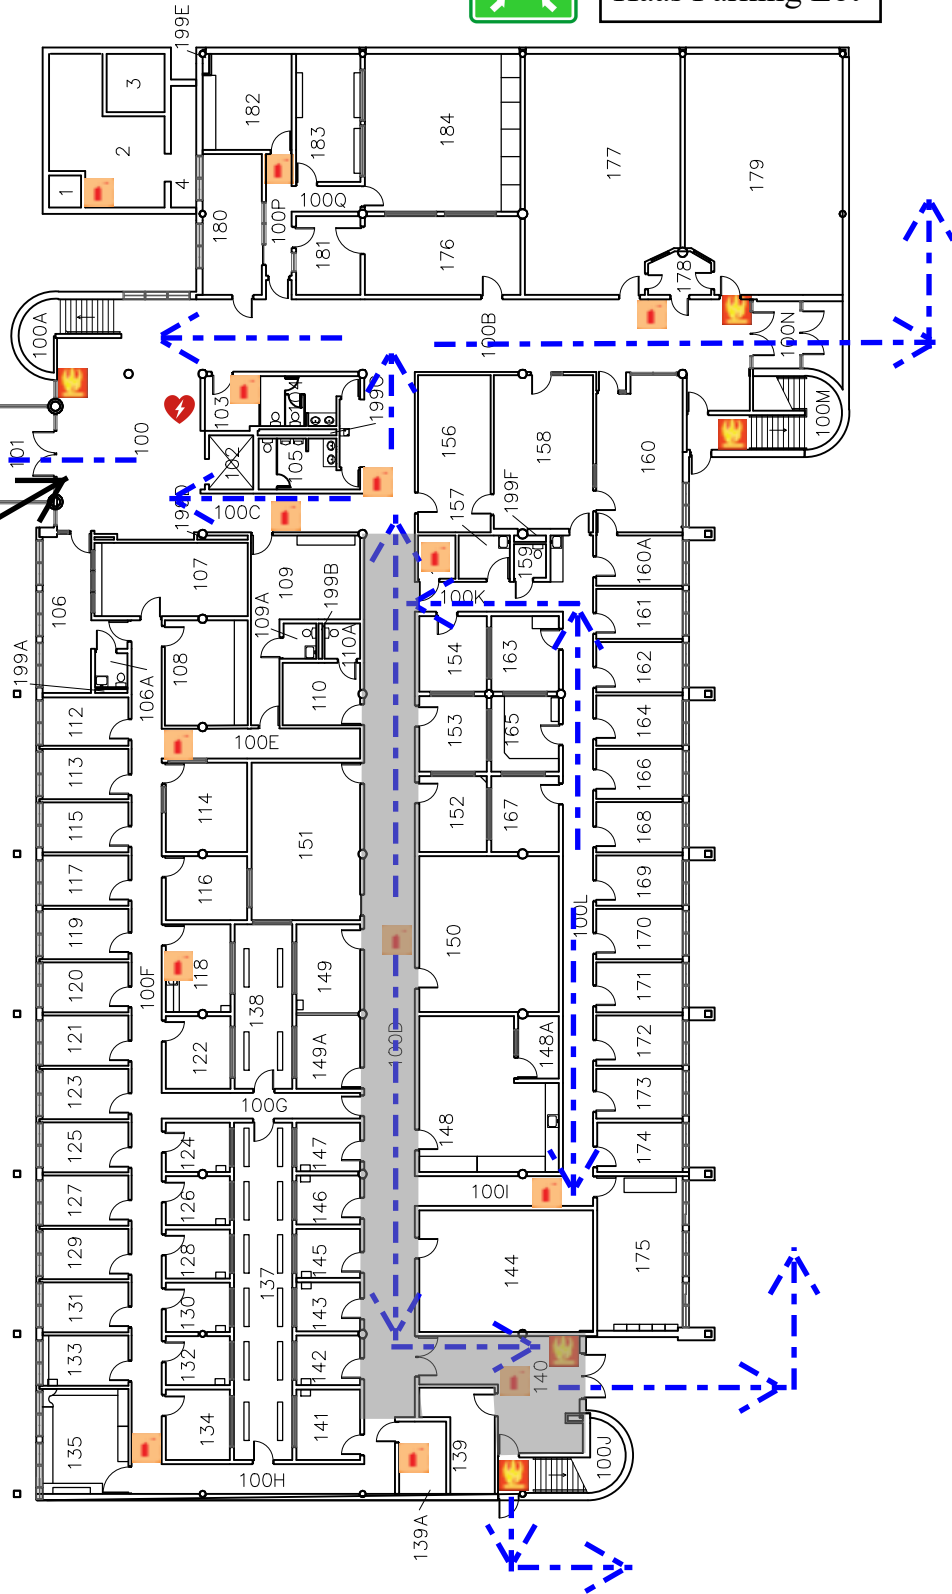




Assembly Point-
Haas Parking Lot

You Are
Here

-  Fire Alarm Pull Fire
-  Extinguisher
-  AED
-  Evacuation Route
-  Shelter Areas
(Severe Weather)



University of Wisconsin-Eau Claire

Facilities Planning

DATE:

Oct 2021

DWG NO:

1






Human Sciences and Services First Floor Plan




East



Assembly Point-
Haas Parking Lot

-  Fire Alarm Pull Fire
-  Extinguisher
-  AED
-  Evacuation Route
-  Shelter Areas
(Severe Weather)

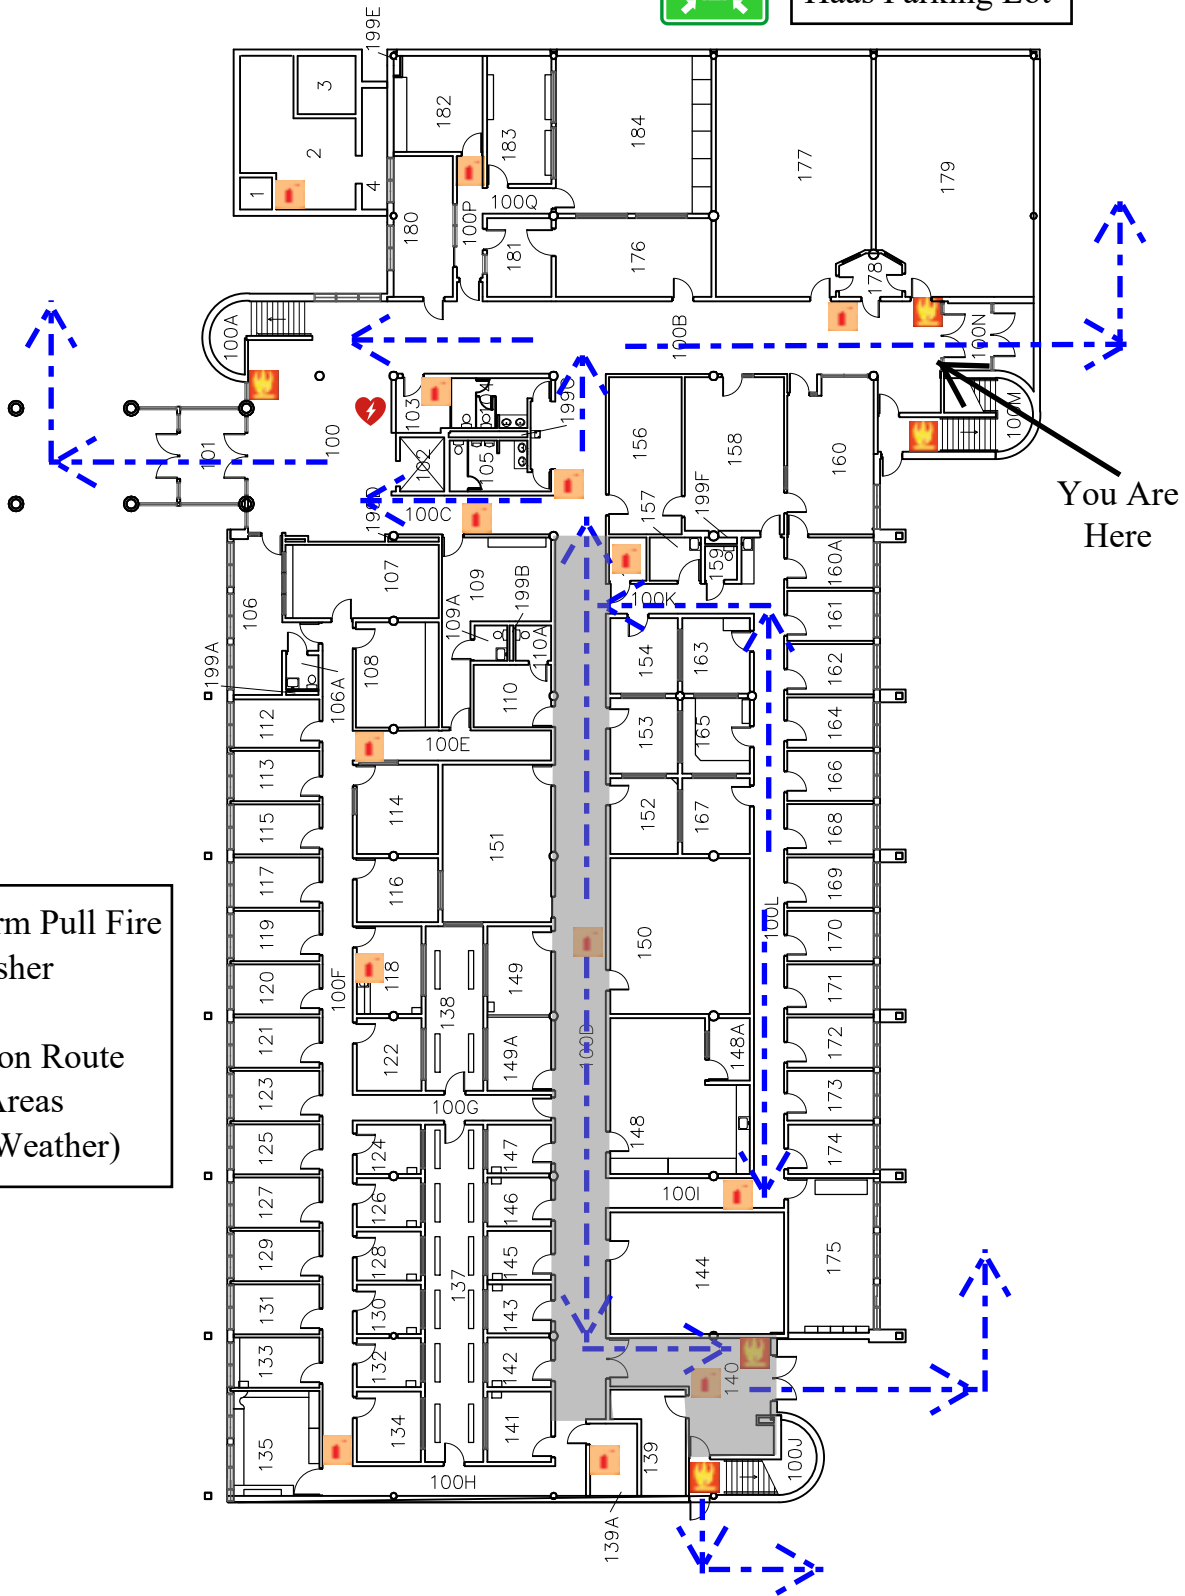

You Are
Here



University of Wisconsin-Eau Claire

Facilities Planning

DATE:

Oct 2021

DWG NO:






2


Human Sciences and Services First Floor Plan





Assembly Point-
Haas Parking Lot

-  Fire Alarm Pull Fire
-  Extinguisher
-  AED
-  Evacuation Route
-  Shelter Areas
(Severe Weather)

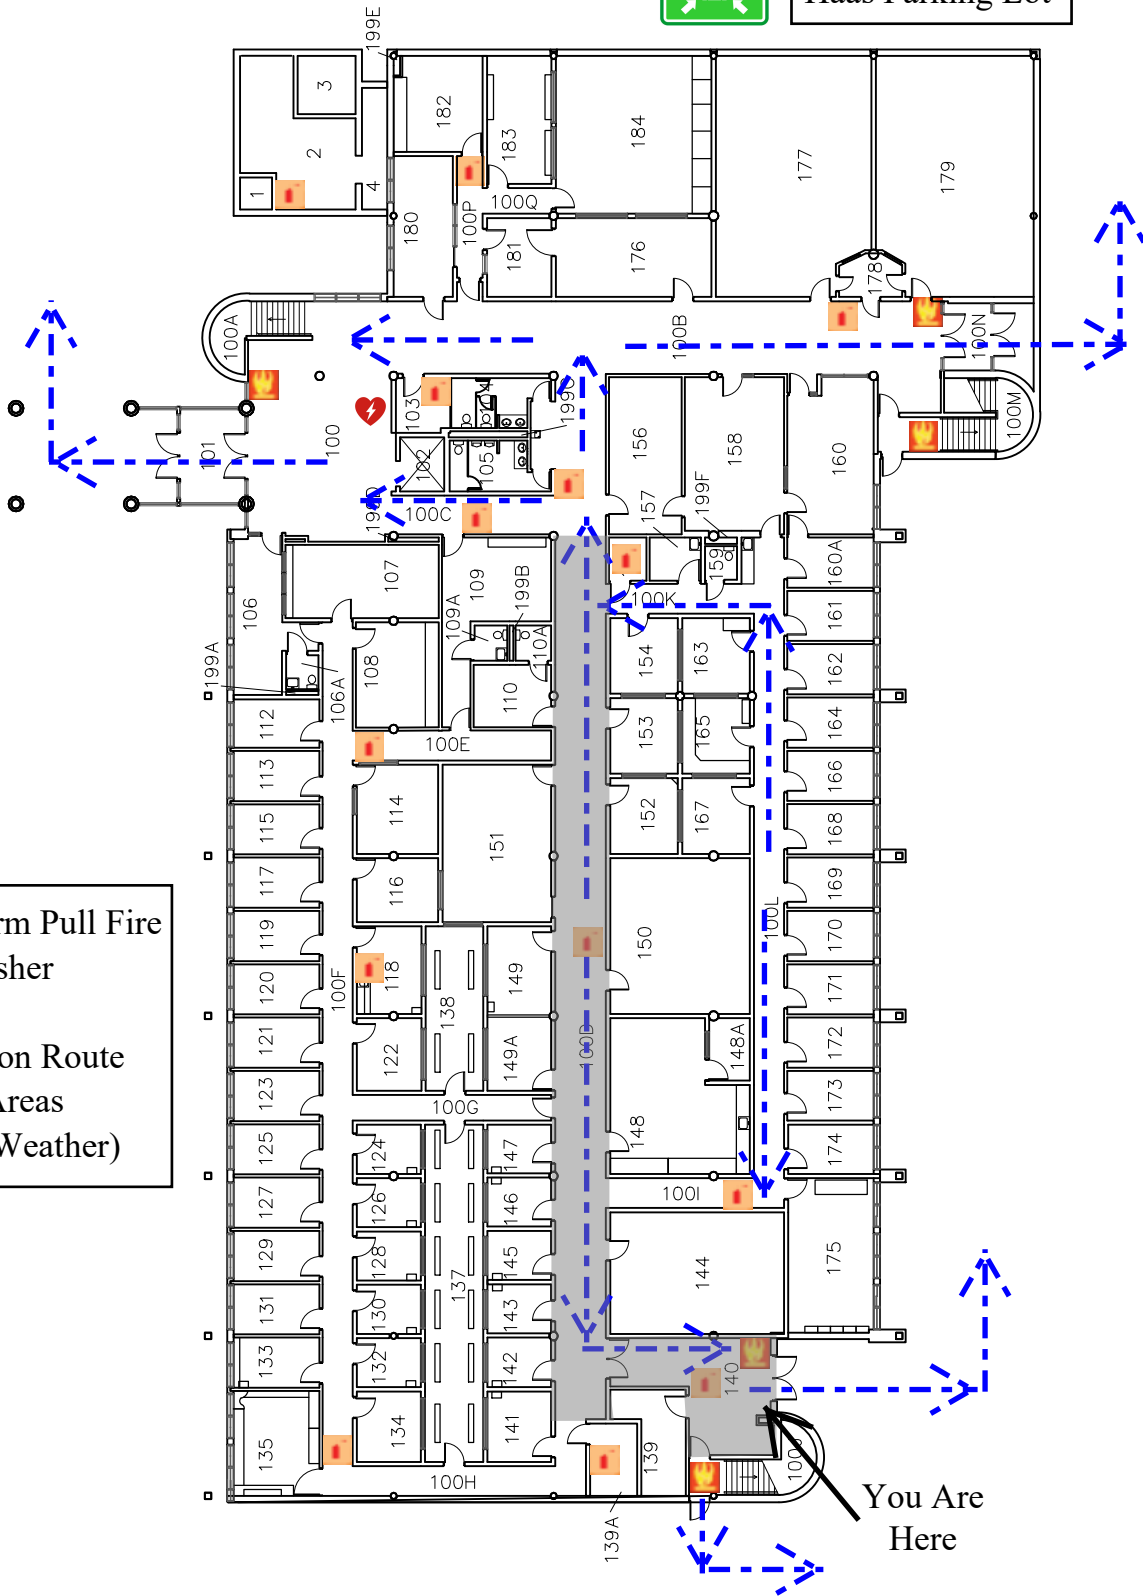

University of Wisconsin-Eau Claire

Facilities Planning

DATE:

Oct 2021

Human Sciences and Services First Floor Plan






DWG NO:


3





Assembly Point-
Haas Parking Lot

-  Fire Alarm Pull Fire
-  Extinguisher
-  AED
-  Evacuation Route
-  Shelter Areas
(Severe Weather)

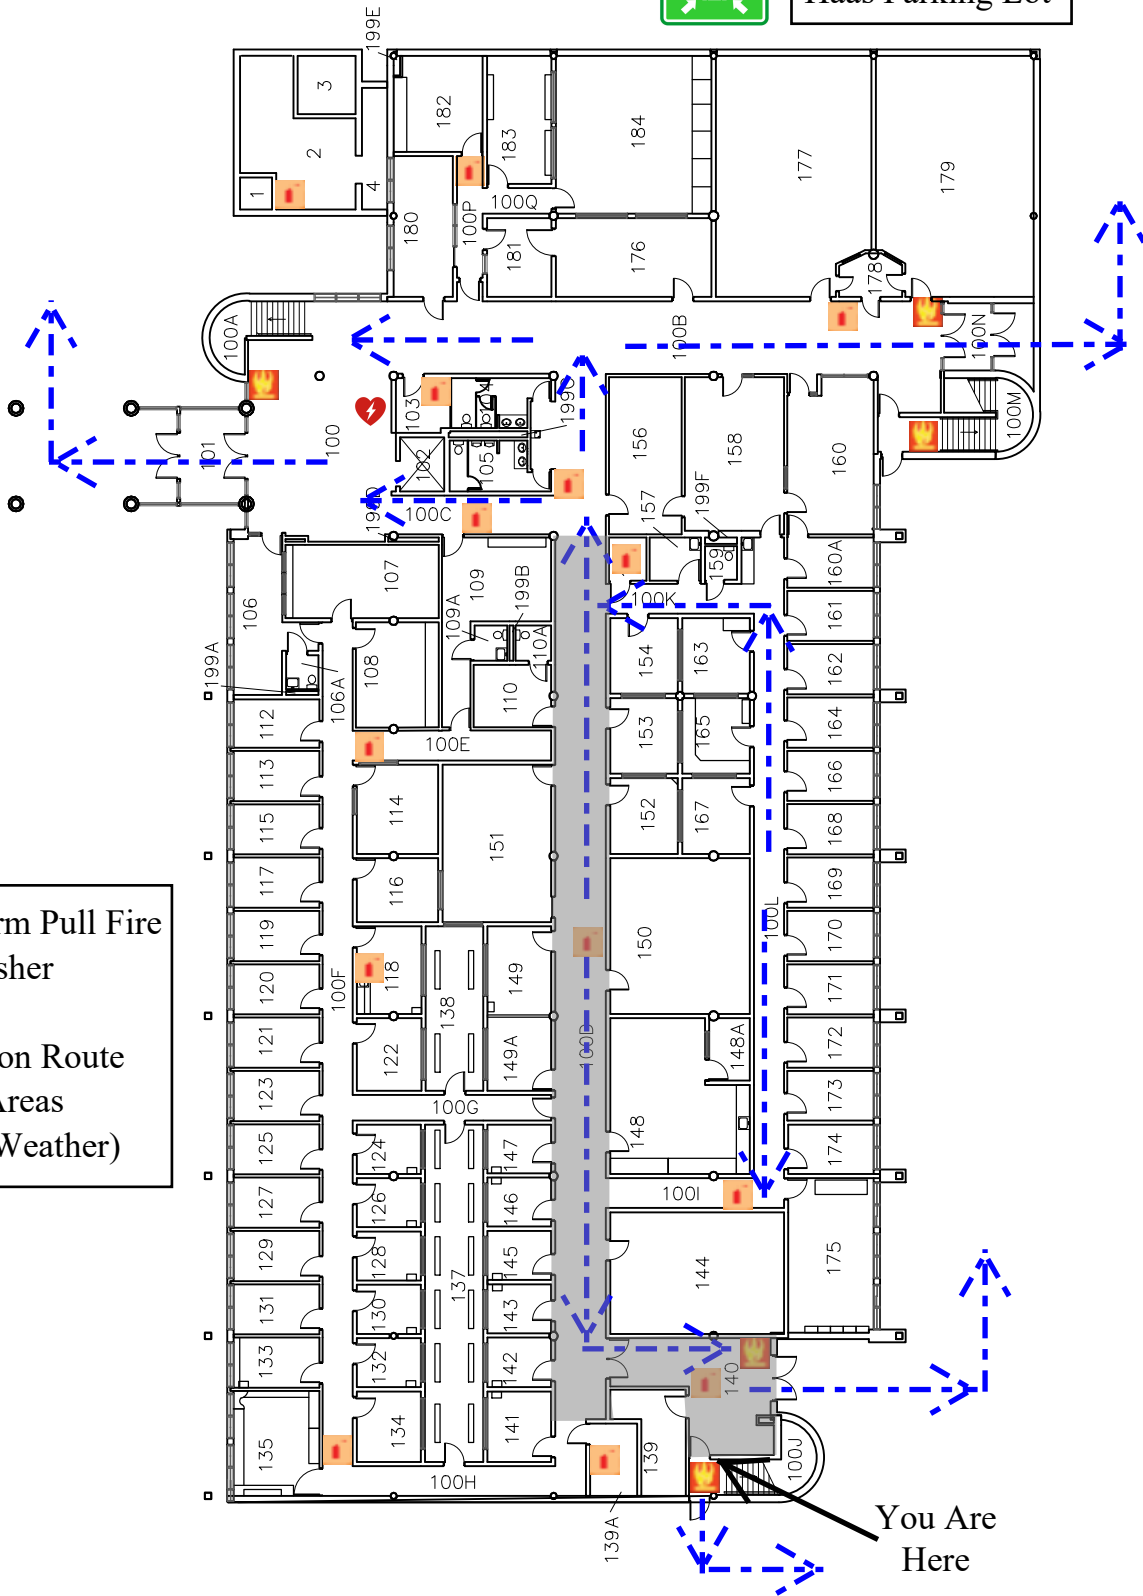

University of Wisconsin-Eau Claire

Facilities Planning

DATE:

Oct 2021




DWG NO:


4




Human Sciences and Services First Floor Plan




You Are Here

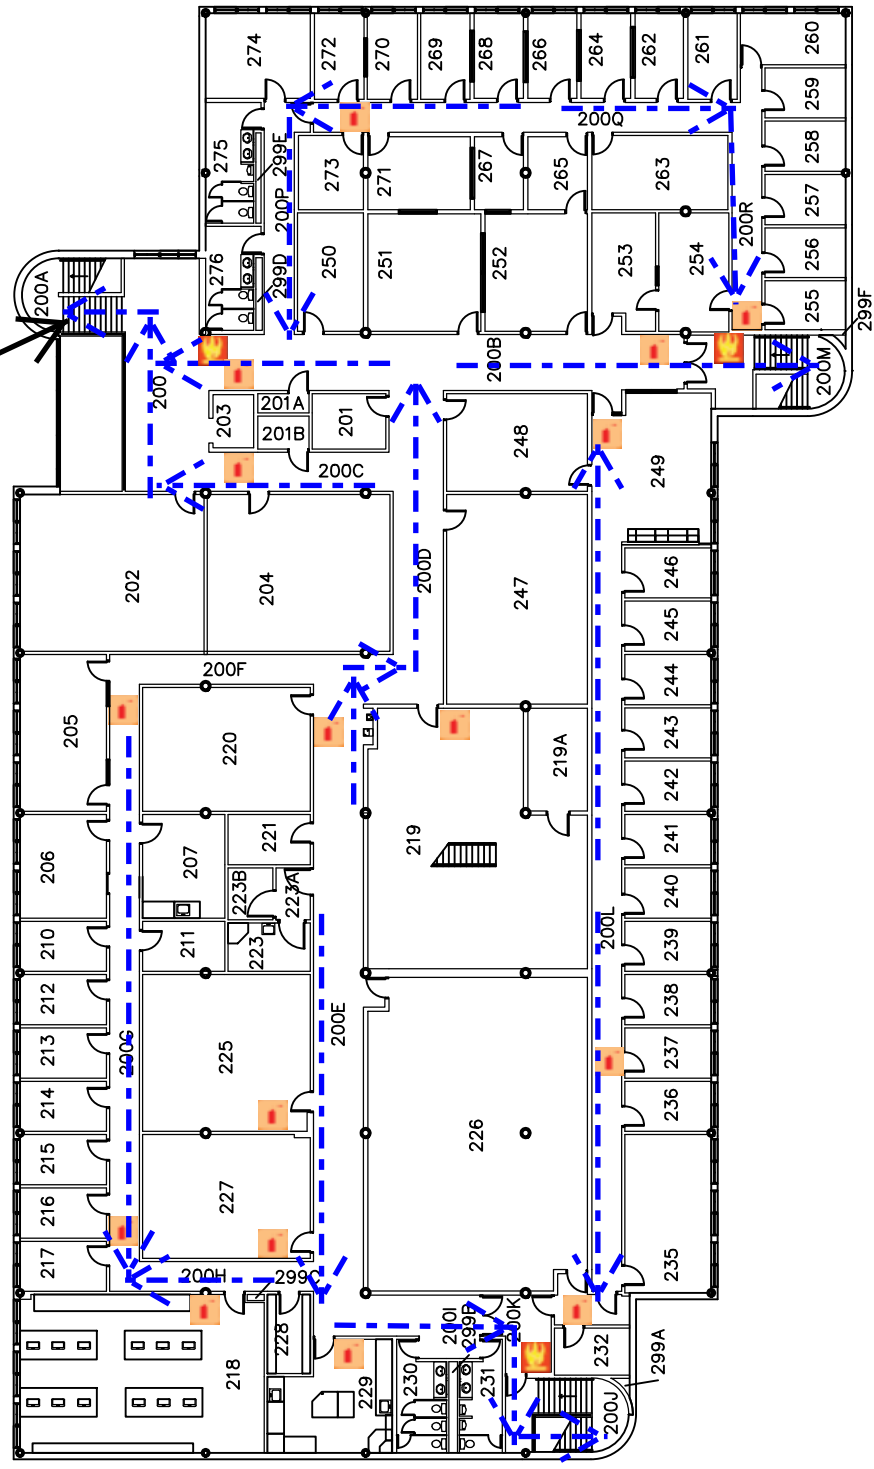	Fire Alarm Pull
	Fire Extinguisher
	Evacuation Route



	Fire Alarm Pull
	Fire Extinguisher
	Evacuation Route

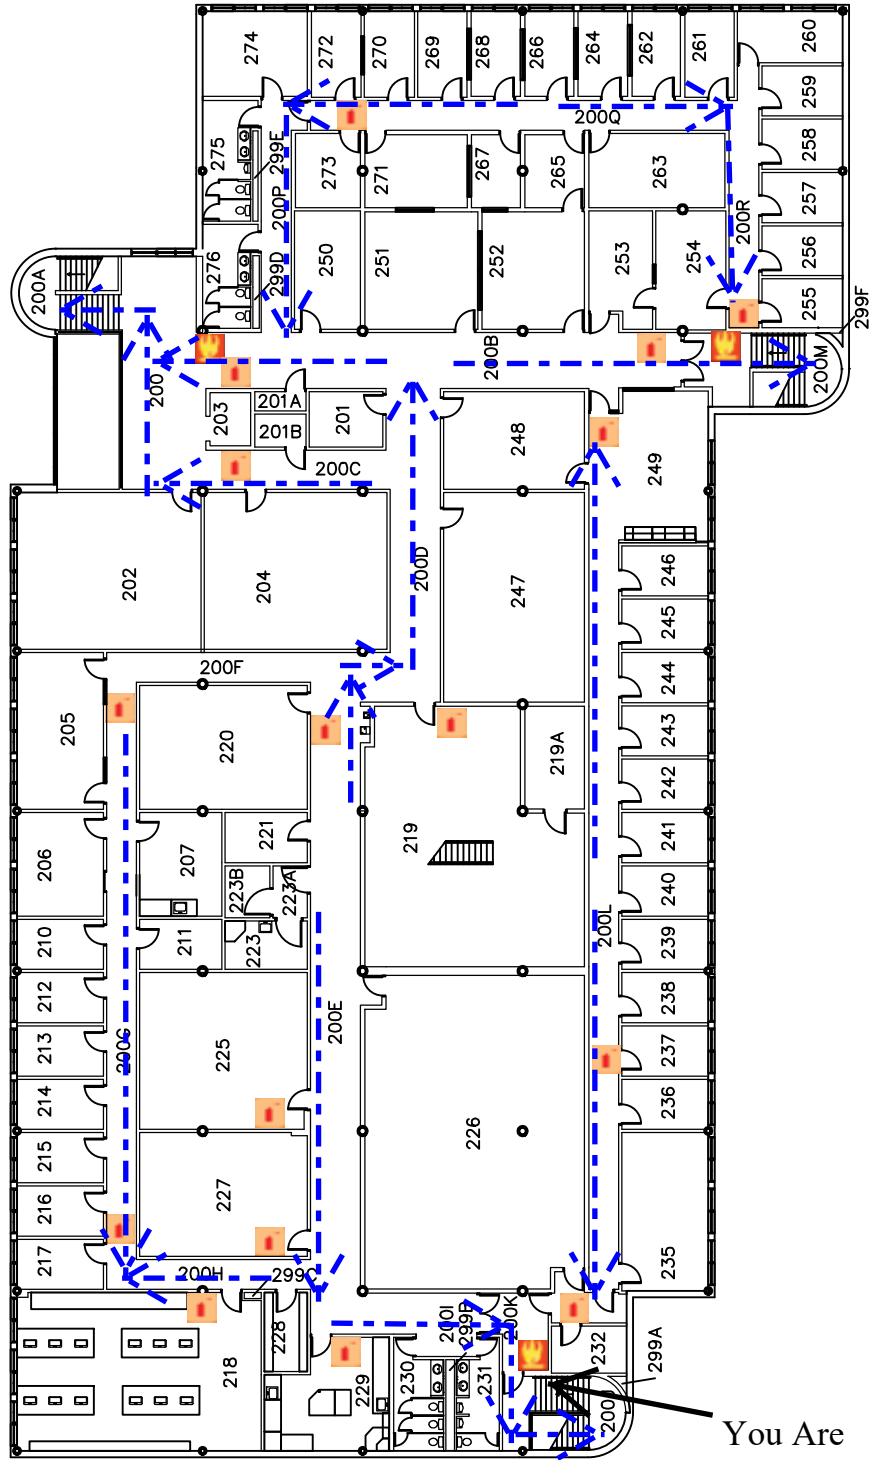

You Are Here



University of Wisconsin-Eau Claire




Facilities Planning


Human Sciences and Services Second Floor Plan

DATE:
Oct 2021

DWG NO:
2



	Fire Alarm Pull
	Fire Extinguisher
	Evacuation Route

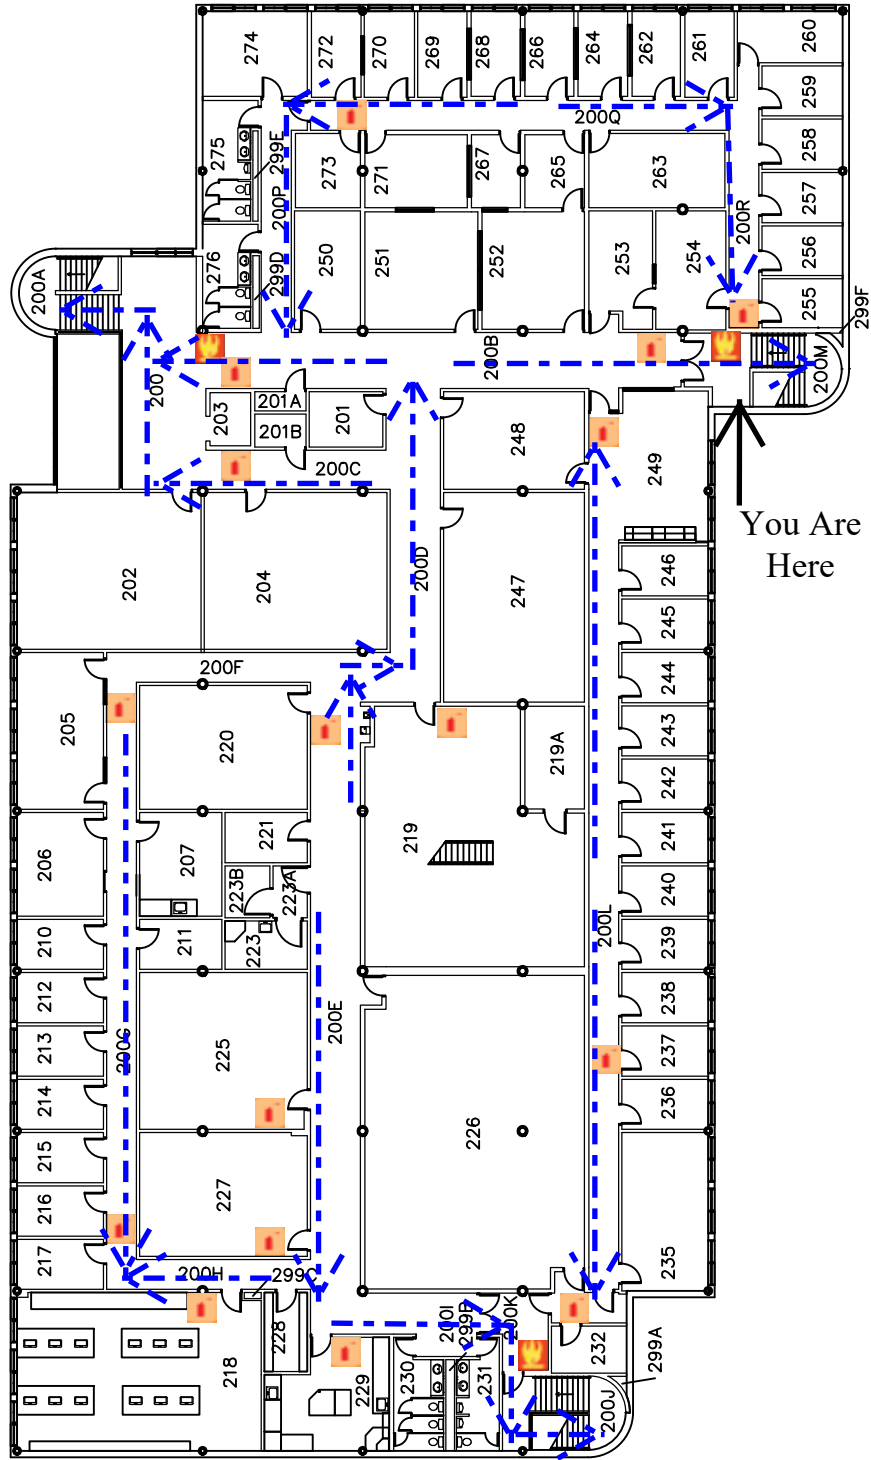

University of Wisconsin-Eau Claire

Facilities Planning

Human Sciences and Services Second Floor Plan

DATE:

Oct 2021

DWG NO:

3

