
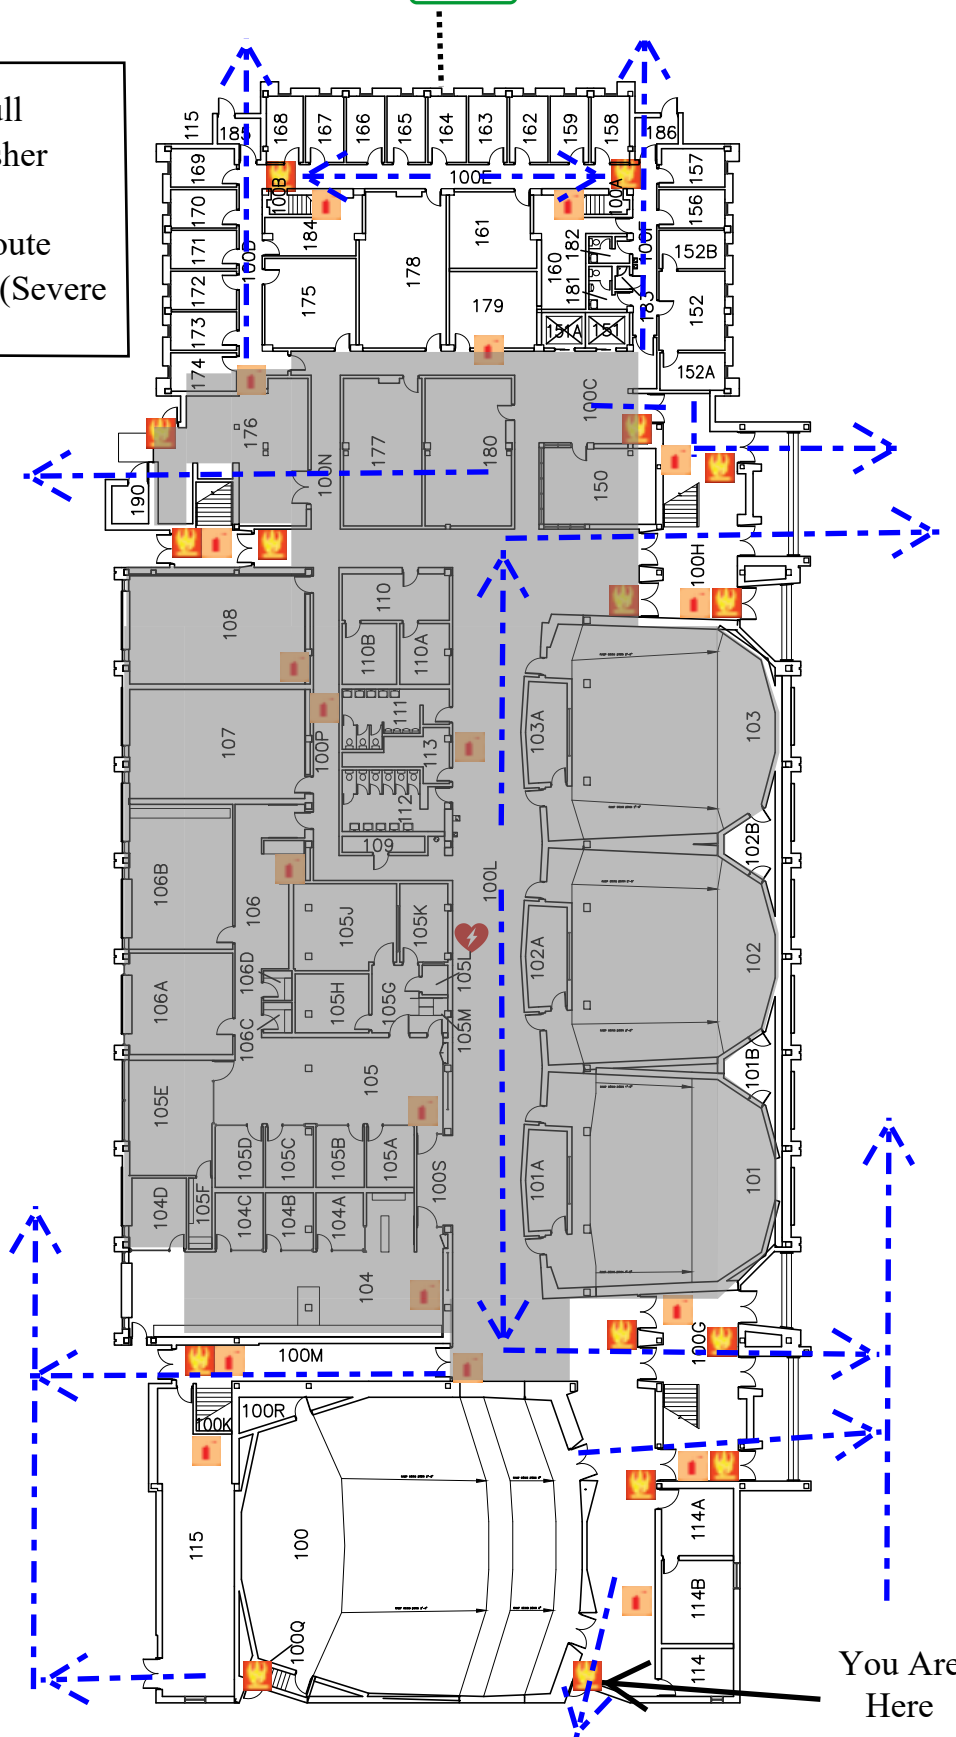
 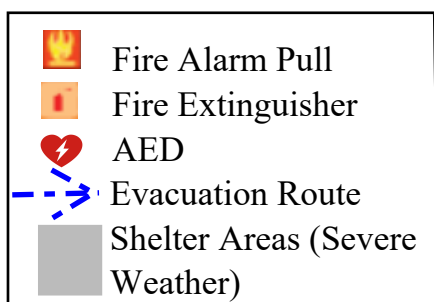




University of Wisconsin-Eau Claire

Facilities Planning

Hibbard Humanities Hall

First Floor Plan

DATE:

July 2021

DWG NO:

1





Assembly Point- Hibbard
Parking Lot (Accross the street)



Fire Alarm Pull



Fire Extinguisher




AED



Evacuation Route



Shelter Areas (Severe
Weather)

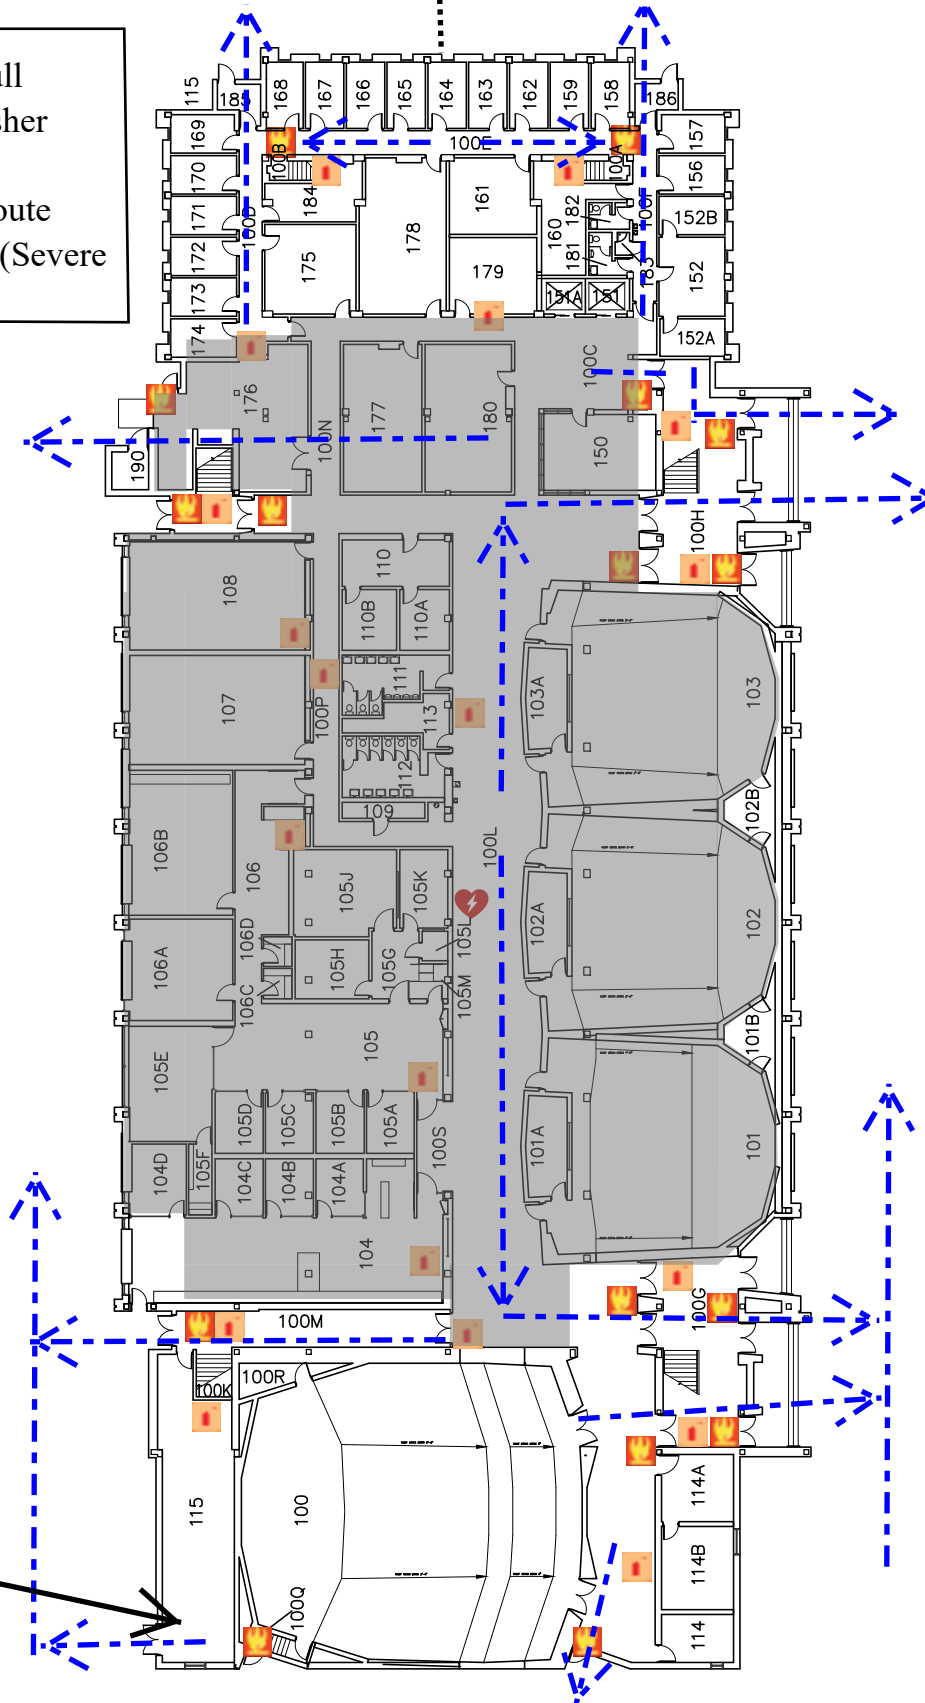

You Are
Here



University of Wisconsin-Eau Claire

Facilities Planning

Hibbard Humanities Hall First Floor Plan

DATE:

July 2021

DWG NO:

2





Assembly Point- Hibbard
Parking Lot (Accross the street)



Fire Alarm Pull



Fire Extinguisher



AED




Evacuation Route



Shelter Areas (Severe
Weather)

You Are
Here

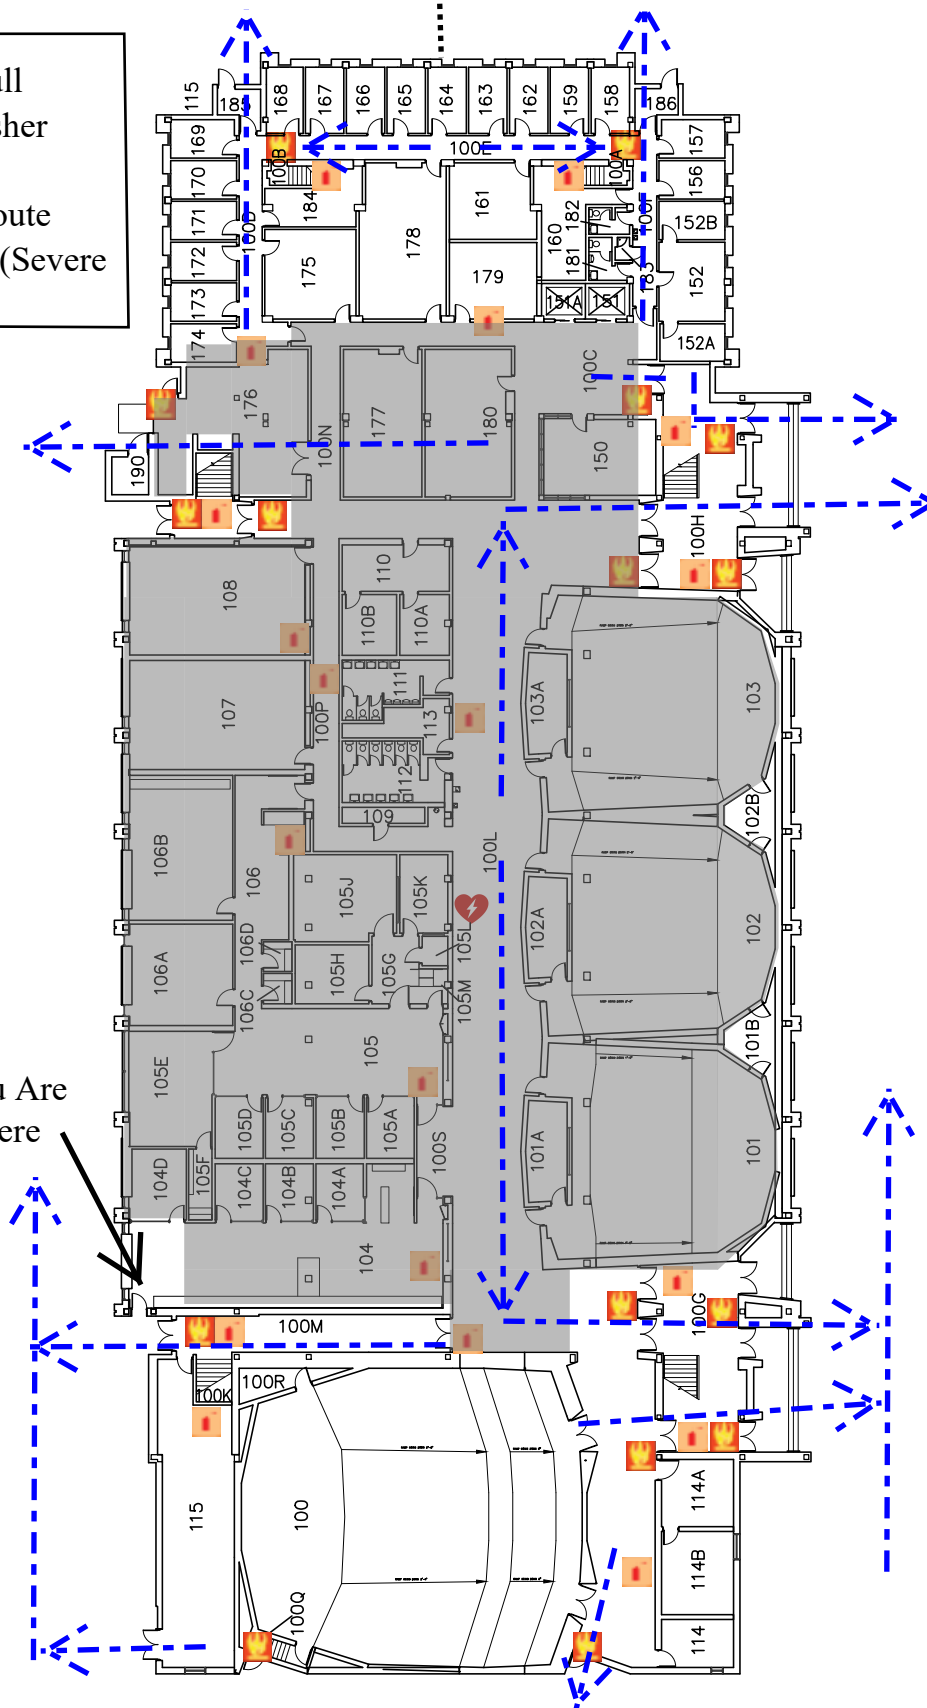

University of Wisconsin-Eau Claire

Facilities Planning

Hibbard Humanities Hall First Floor Plan

DATE:

July 2021

DWG NO:

3





Assembly Point- Hibbard
Parking Lot (Accross the street)



Fire Alarm Pull



Fire Extinguisher



AED




Evacuation Route



Shelter Areas (Severe
Weather)

You Are
Here

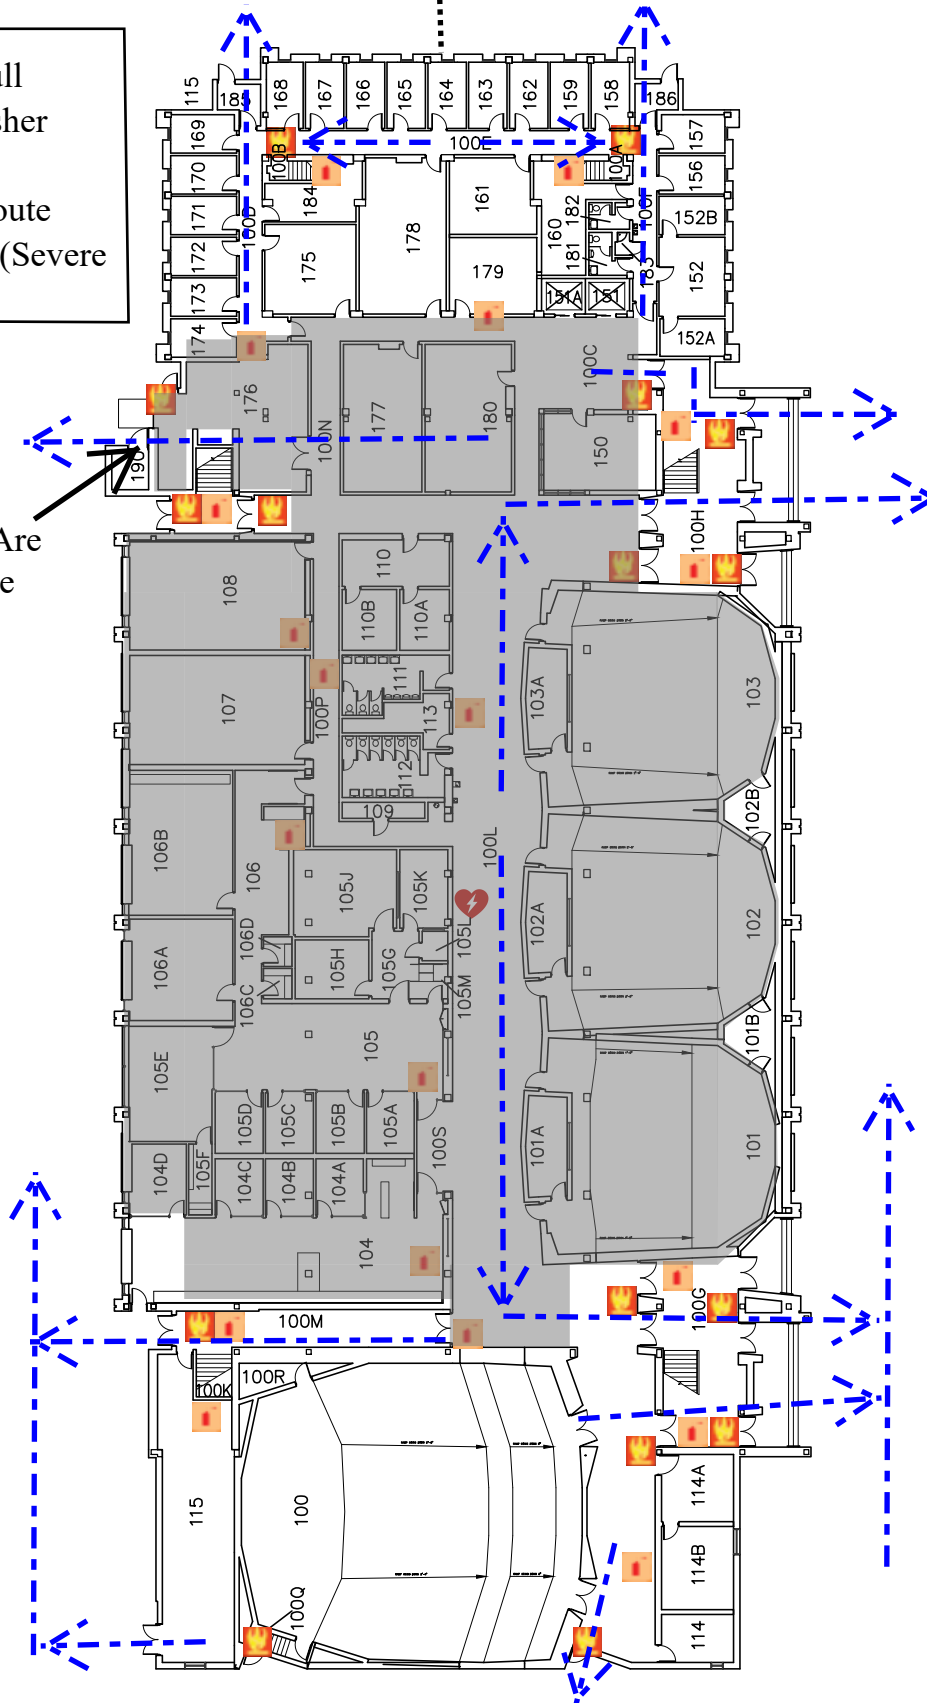

University of Wisconsin-Eau Claire

Facilities Planning

Hibbard Humanities Hall First Floor Plan

DATE:

July 2021

DWG NO:

4




 Fire Alarm Pull
 Fire Extinguisher
 AED
 Evacuation Route
 Shelter Areas (Severe Weather)

You Are Here



Assembly Point- Hibbard
Parking Lot (Accross the street)

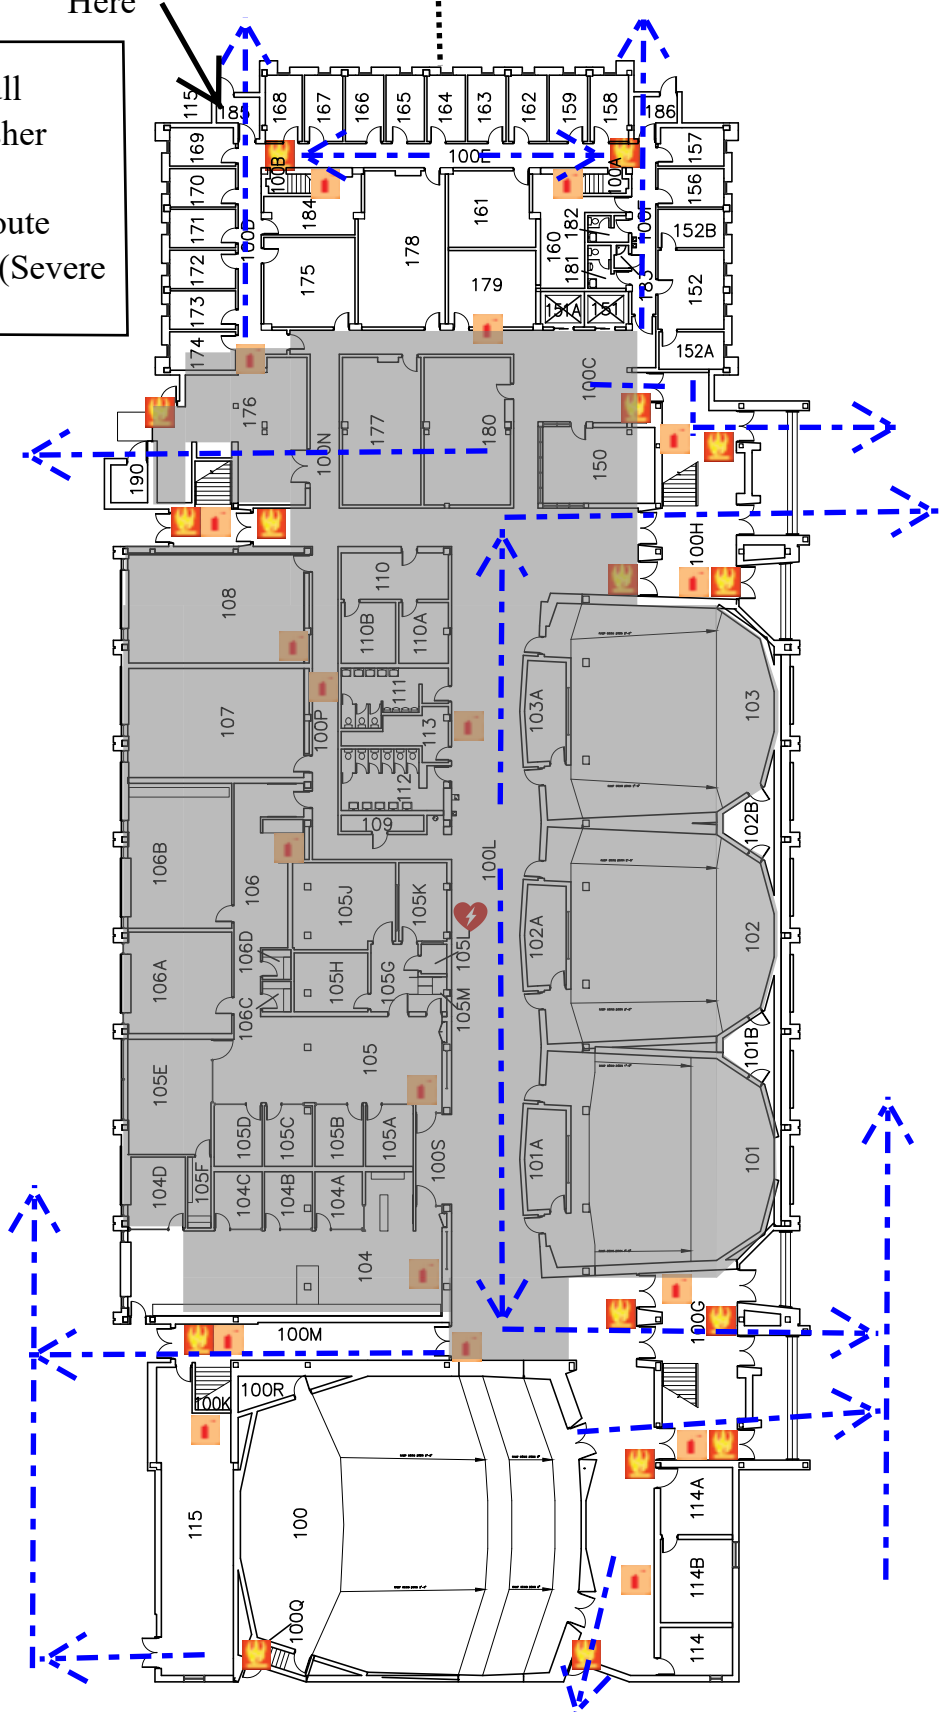



Assembly Point- Hibbard
Parking Lot (Accross the street)



Fire Alarm Pull



Fire Extinguisher




AED



Evacuation Route



Shelter Areas (Severe
Weather)

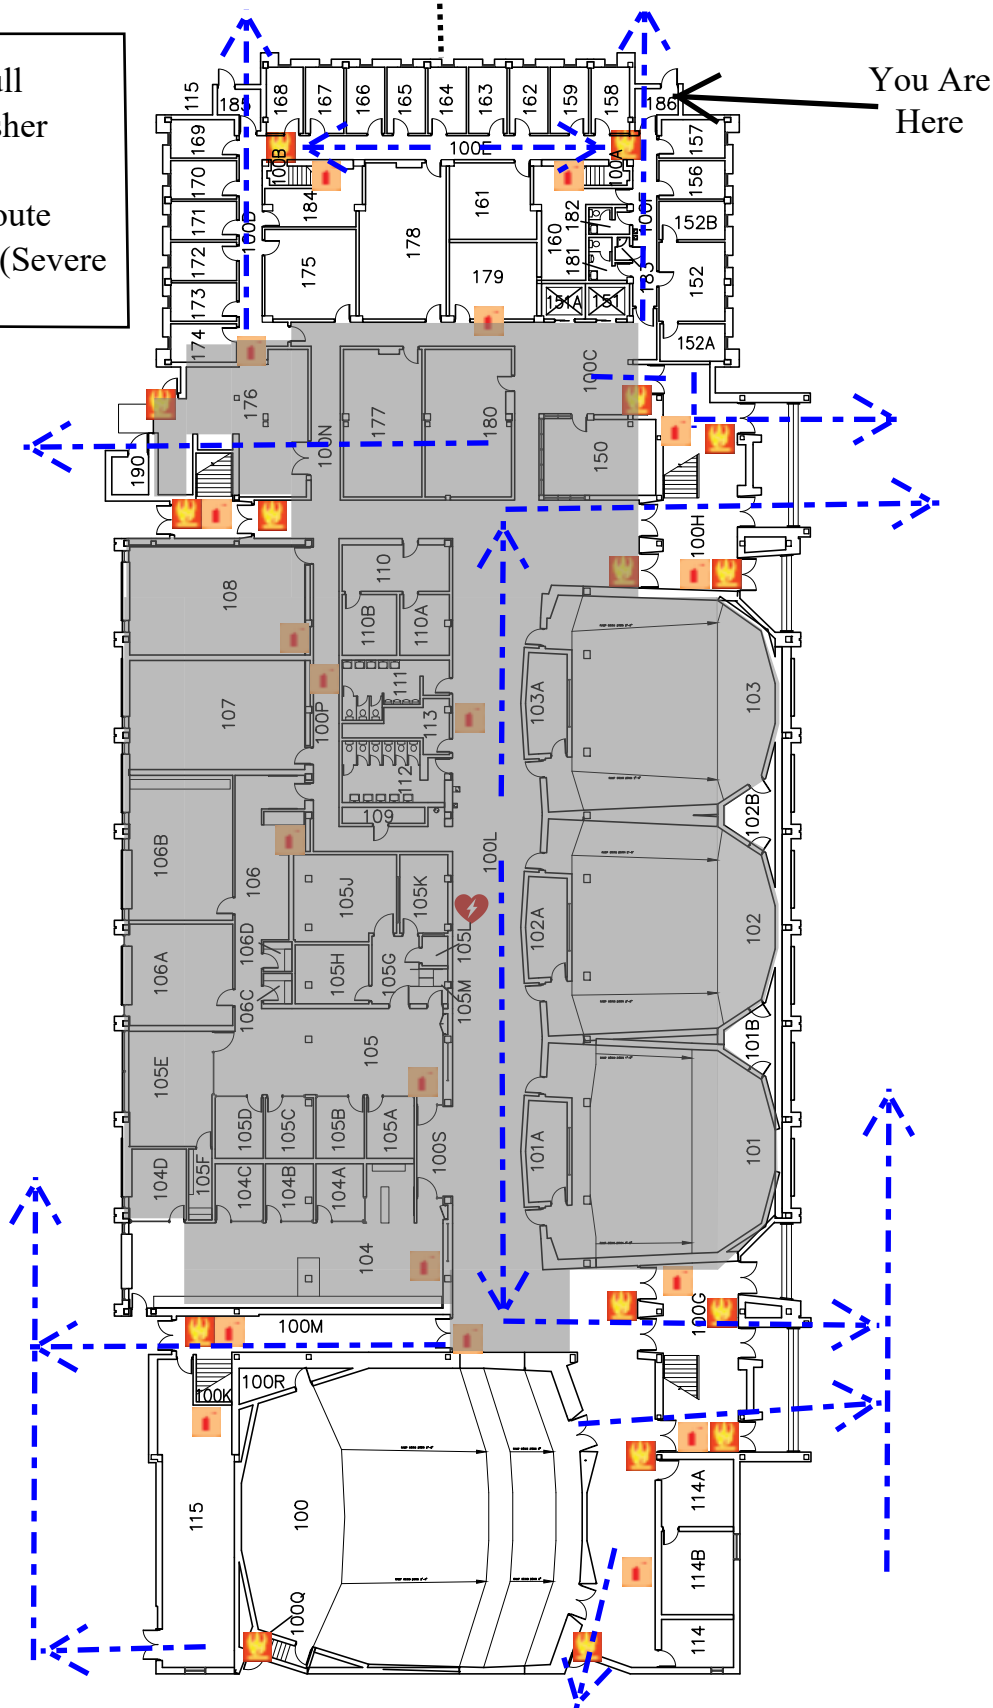

University of Wisconsin-Eau Claire

Facilities Planning

Hibbard Humanities Hall First Floor Plan




DATE:

July 2021

DWG NO:

 6



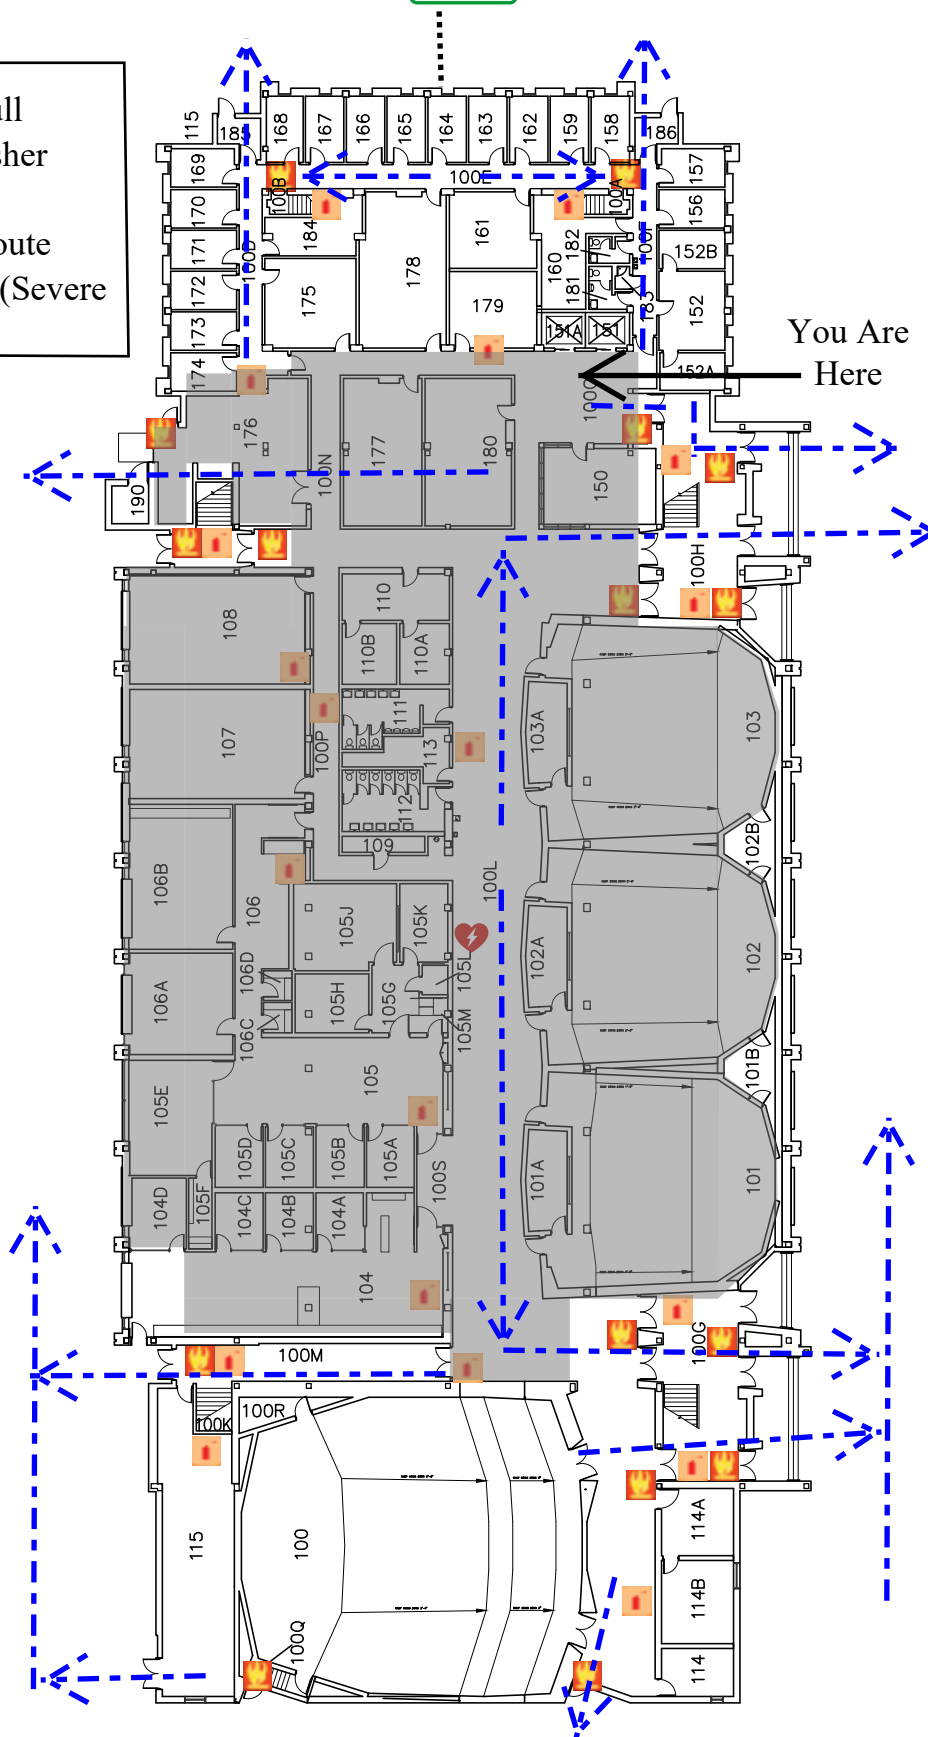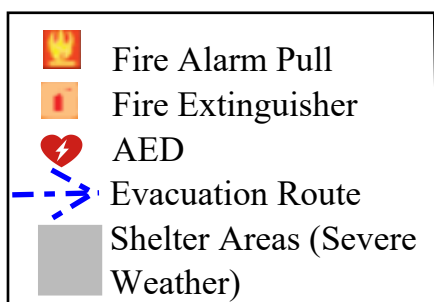

University of Wisconsin-Eau Claire

Facilities Planning

Hibbard Humanities Hall

First Floor Plan

DATE:

July 2021

DWG NO:

7





Assembly Point- Hibbard
Parking Lot (Accross the street)



Fire Alarm Pull



Fire Extinguisher




AED



Evacuation Route



Shelter Areas (Severe
Weather)

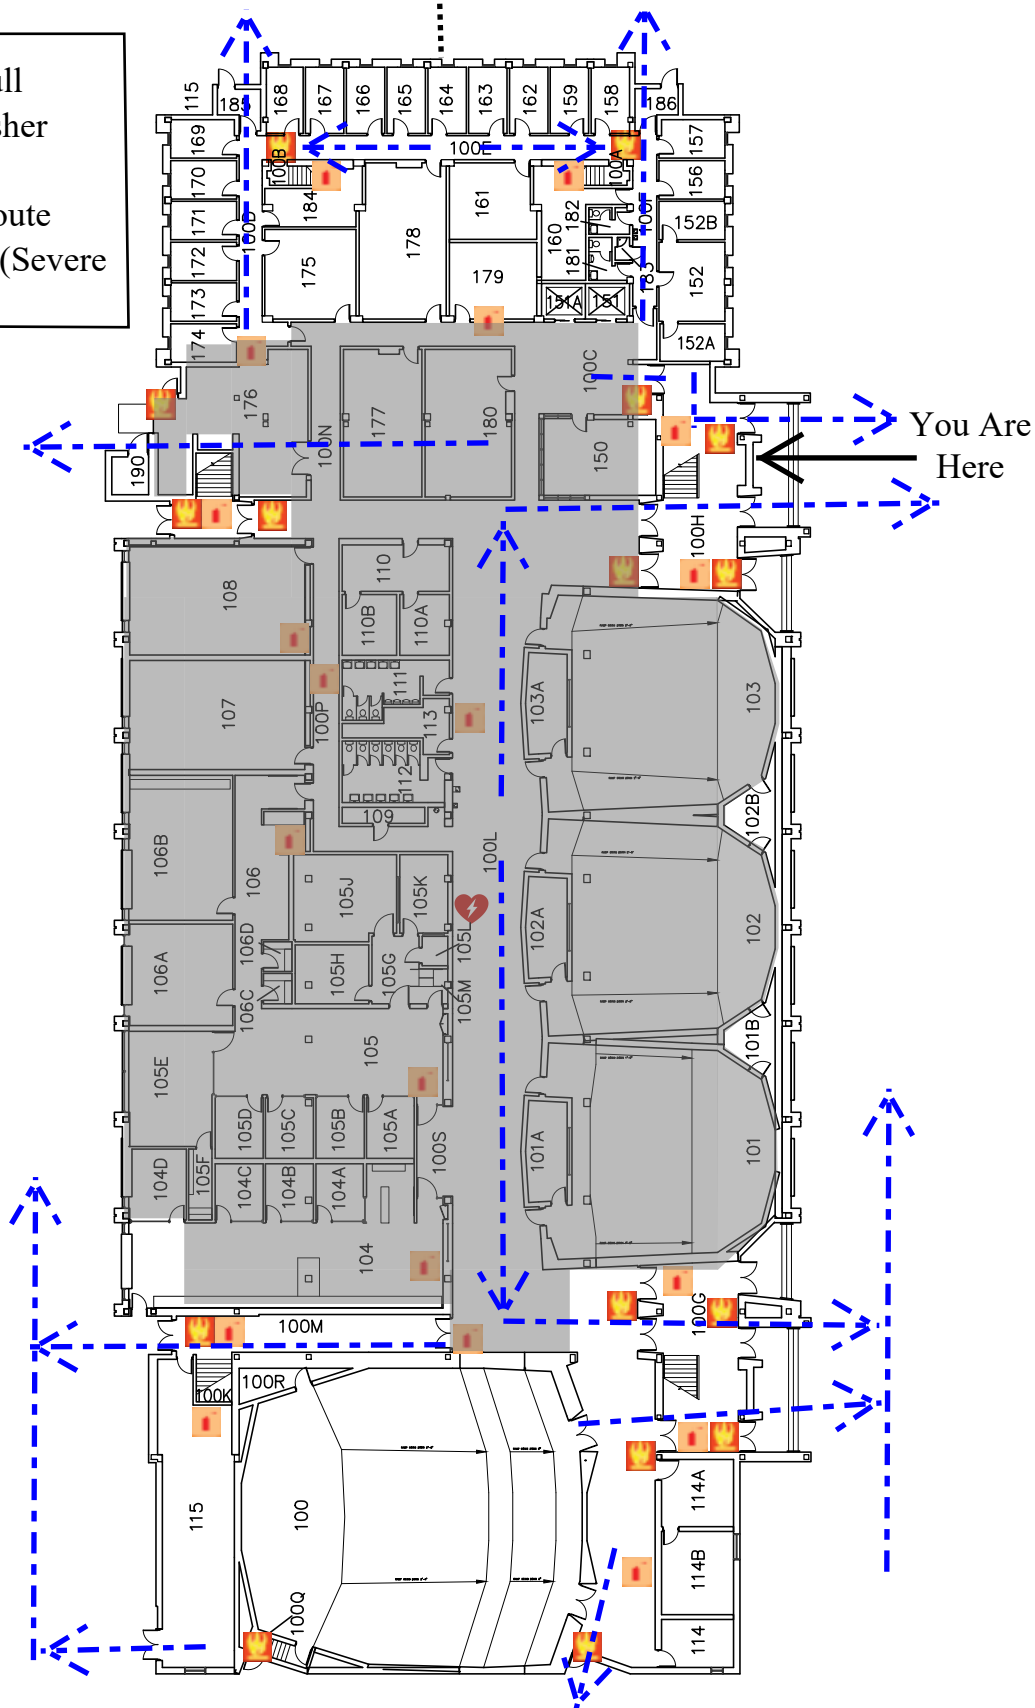

University of Wisconsin-Eau Claire Facilities Planning

Hibbard Humanities Hall First Floor Plan

DATE:

July 2021

DWG NO:


8





Assembly Point- Hibbard
Parking Lot (Accross the street)

- Fire Alarm Pull
- Fire Extinguisher
- AED
- Evacuation Route
- Shelter Areas (Severe Weather)

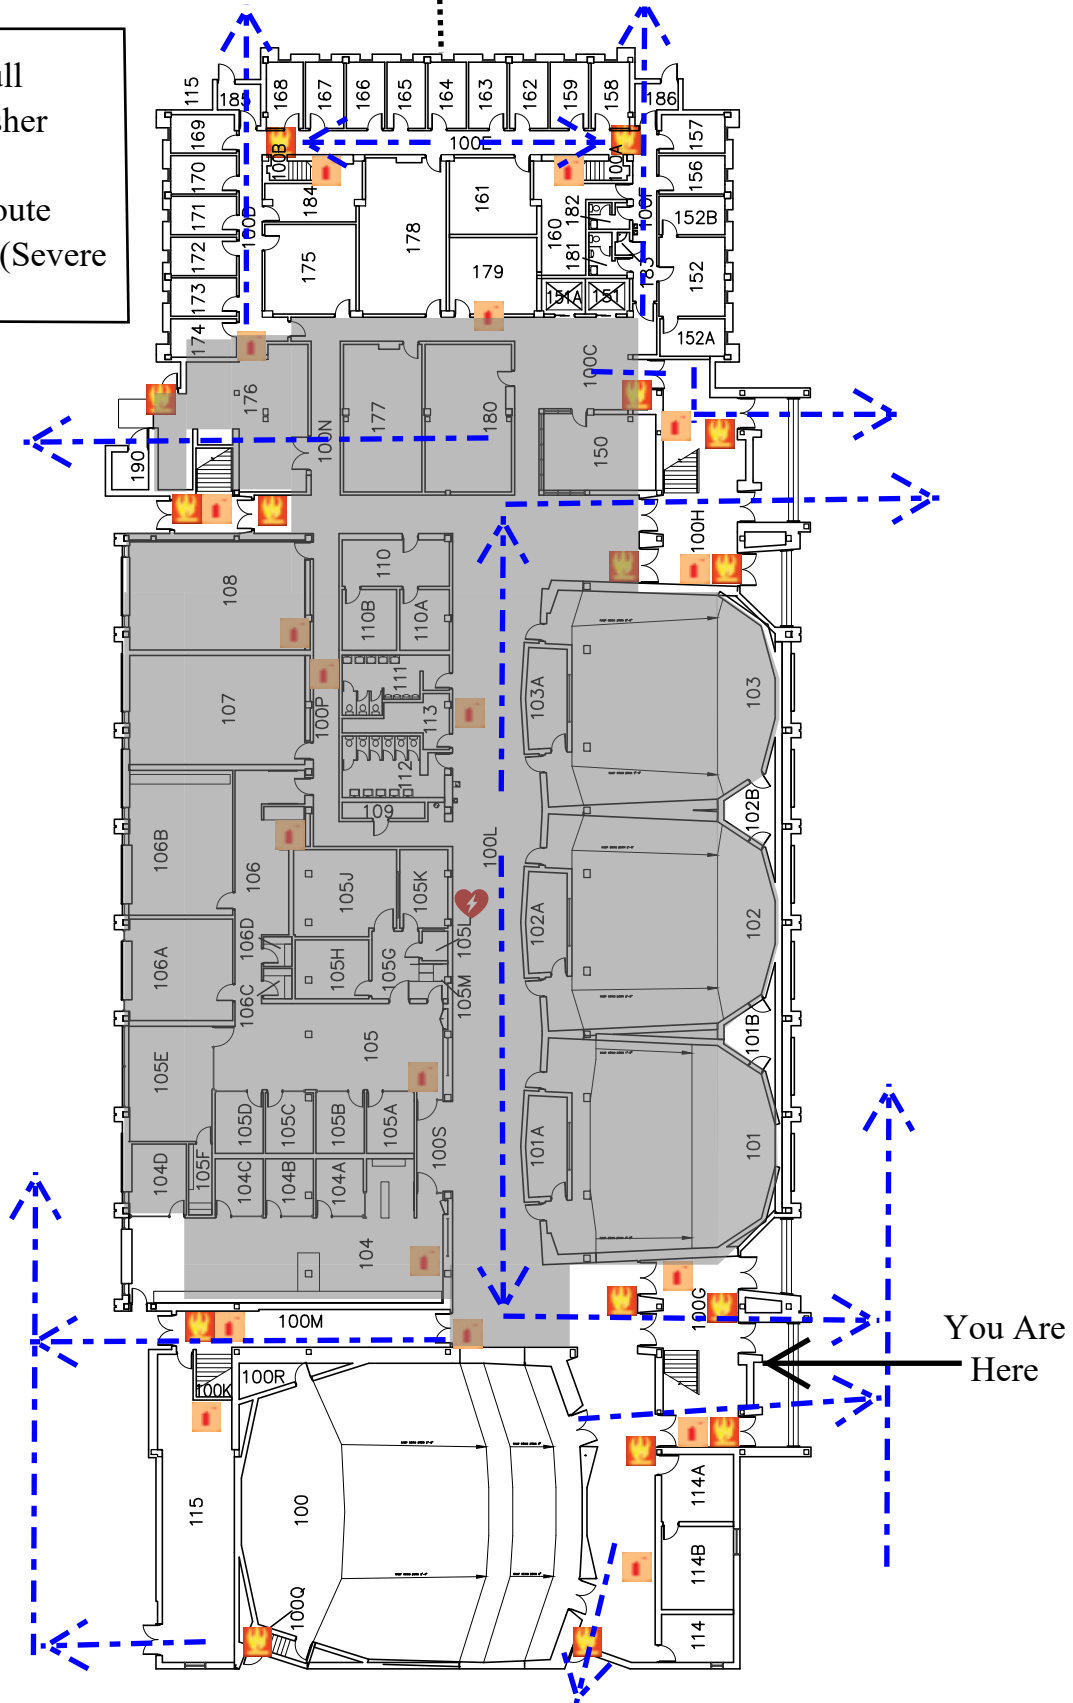


University of Wisconsin-Eau Claire Facilities Planning

Hibbard Humanities Hall First Floor Plan

DATE:
July 2021
DWG NO:
9




 Fire Alarm Pull
 Fire Extinguisher
 Evacuation Route

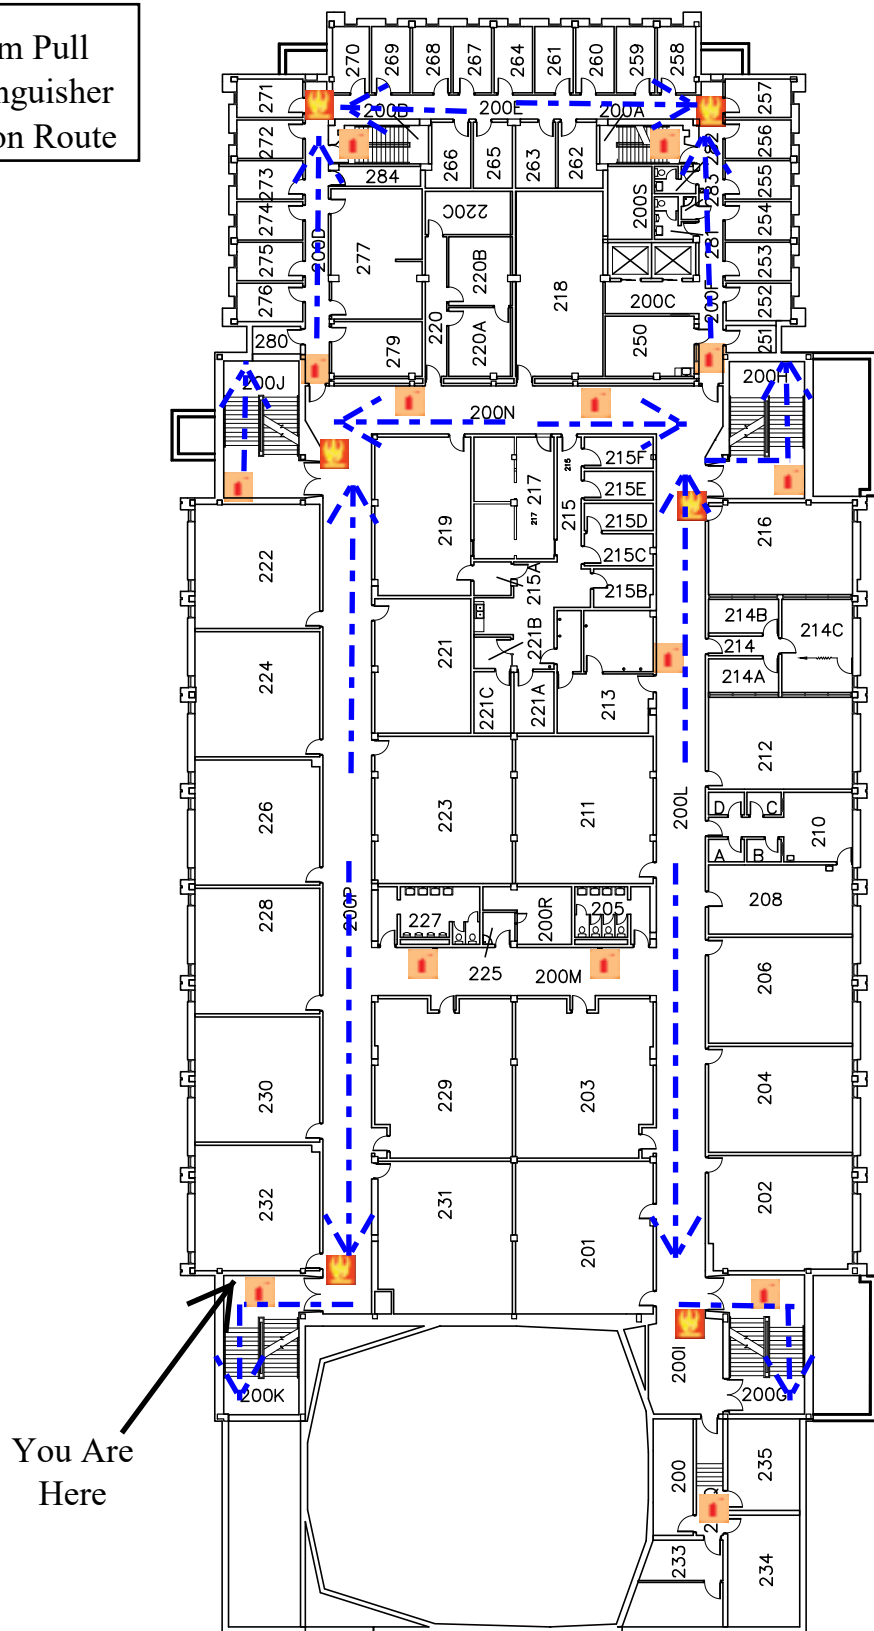


 Fire Alarm Pull
 Fire Extinguisher
 Evacuation Route

You Are Here

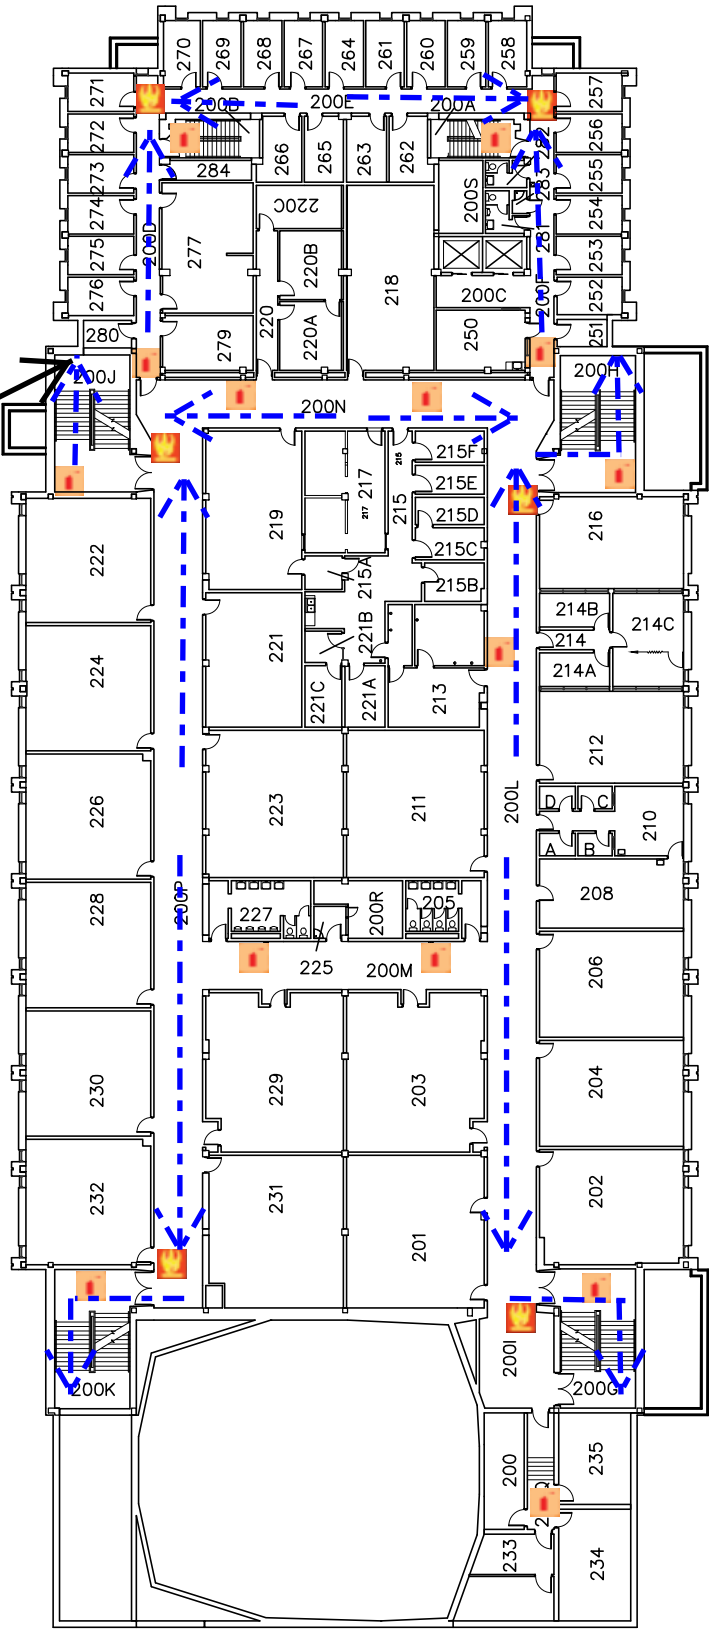

-  Fire Alarm Pull
-  Fire Extinguisher
-  Evacuation Route

You Are
Here

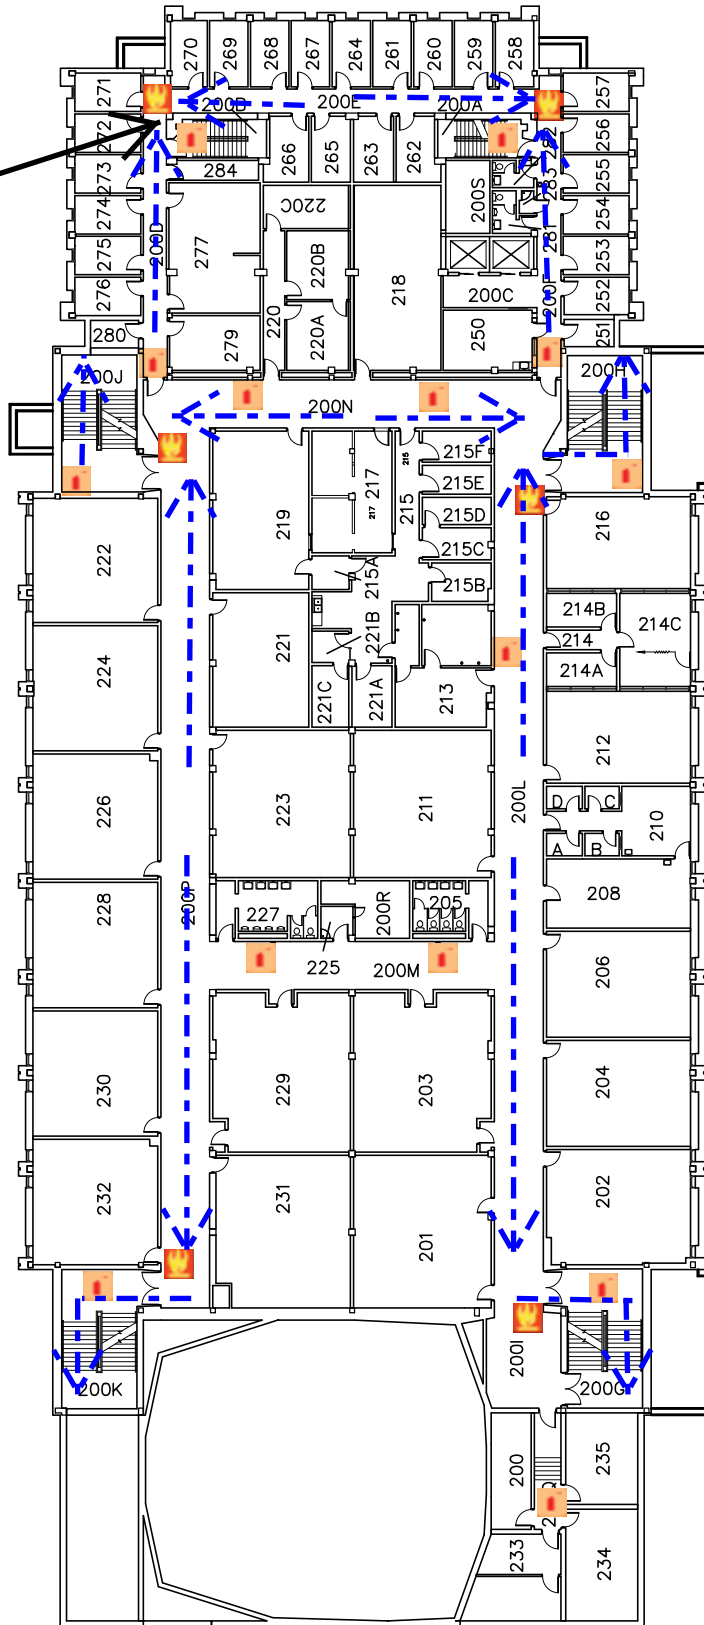


University of Wisconsin-Eau Claire Facilities Planning

Hibbard Humanities Hall Second Floor Plan


DATE:
April 2010
DWG NO:
3




 Fire Alarm Pull
 Fire Extinguisher
 Evacuation Route

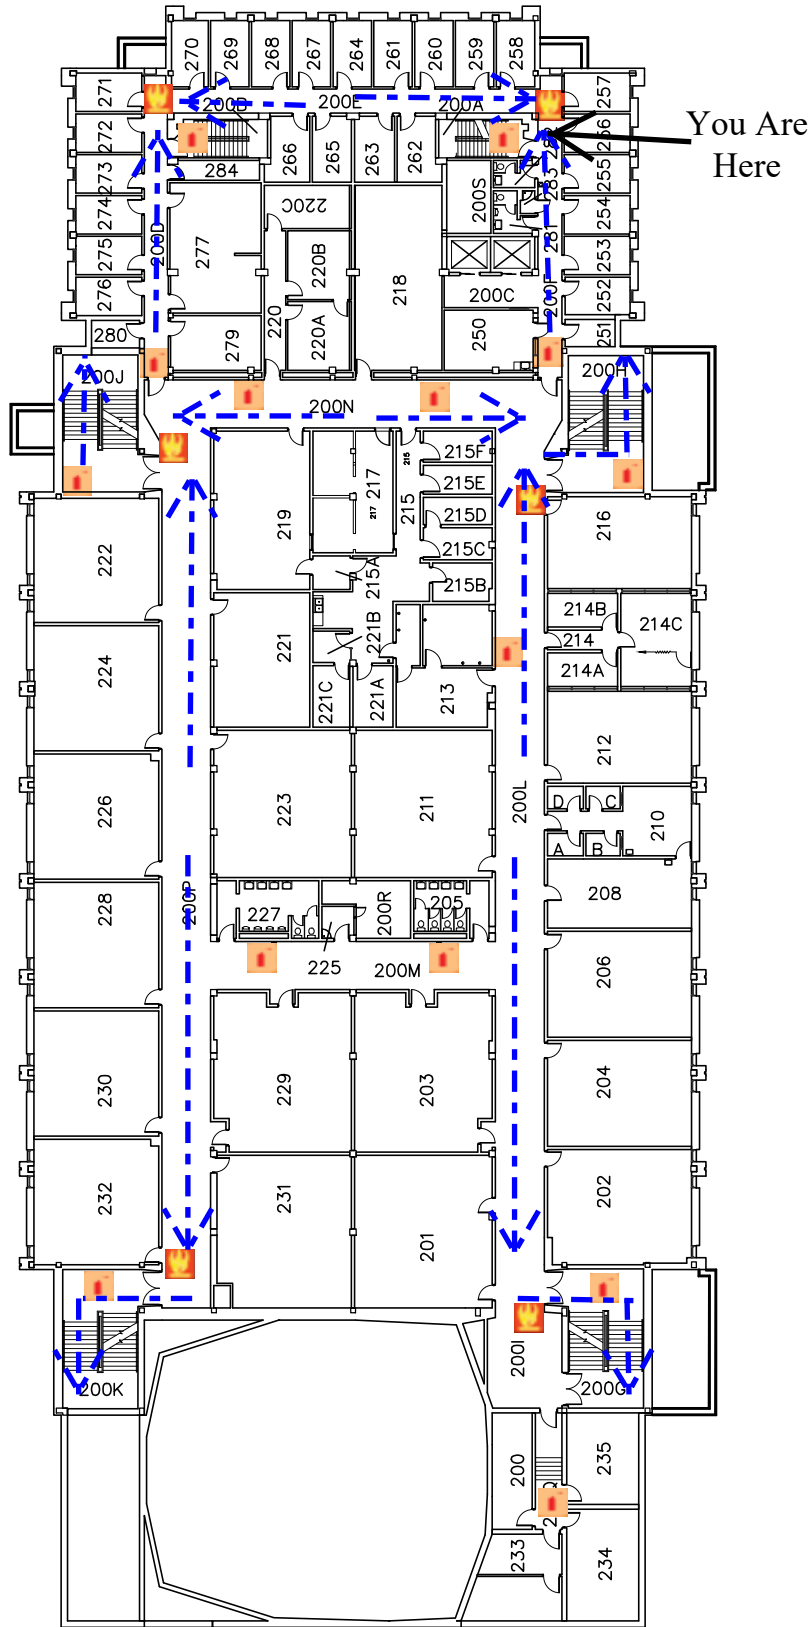


 Fire Alarm Pull
 Fire Extinguisher
 Evacuation Route

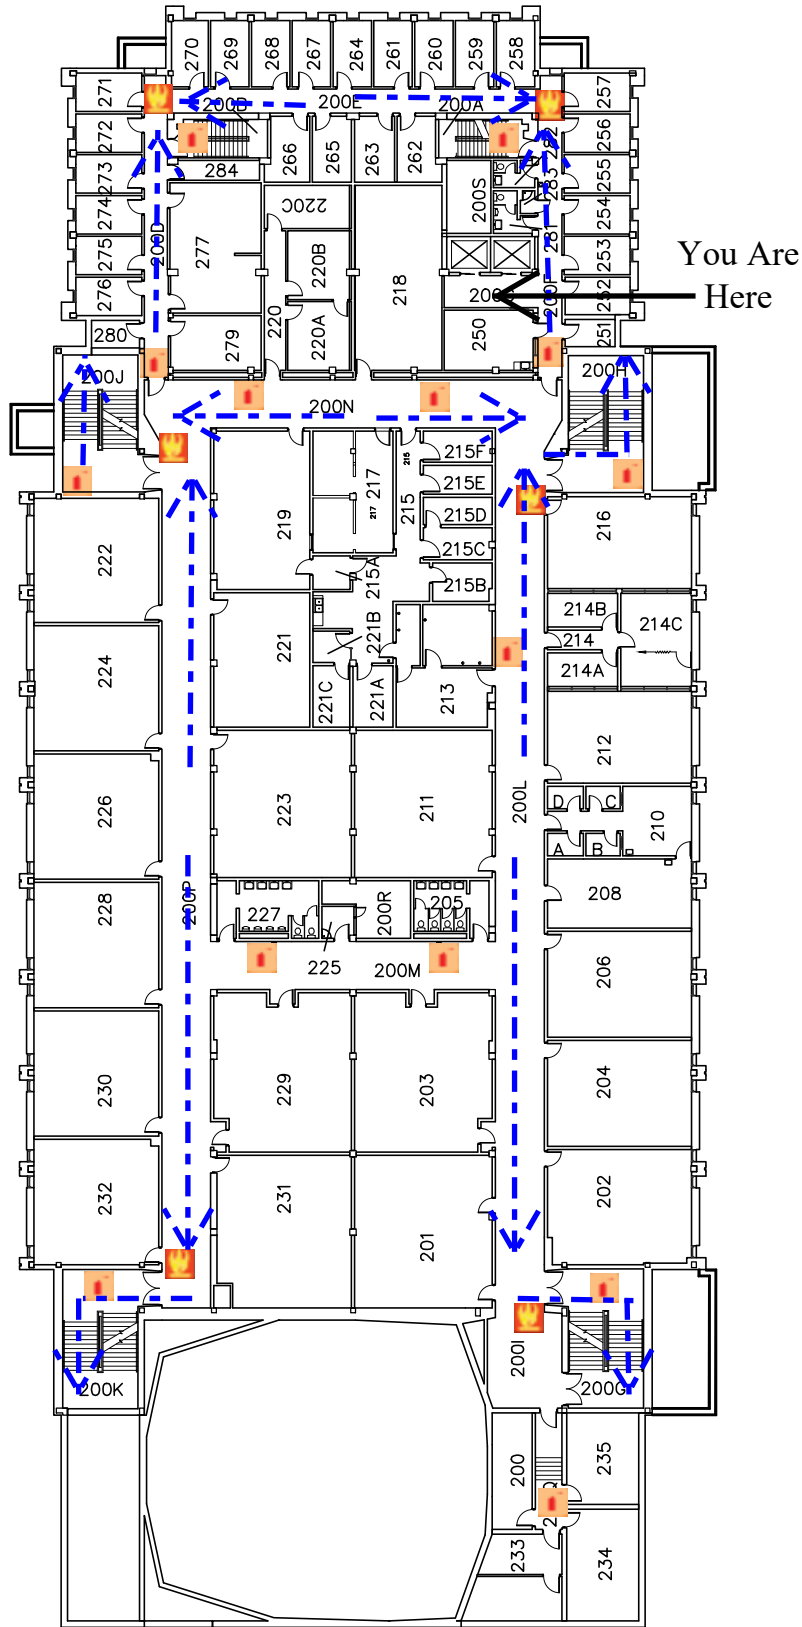


 Fire Alarm Pull
 Fire Extinguisher
 Evacuation Route

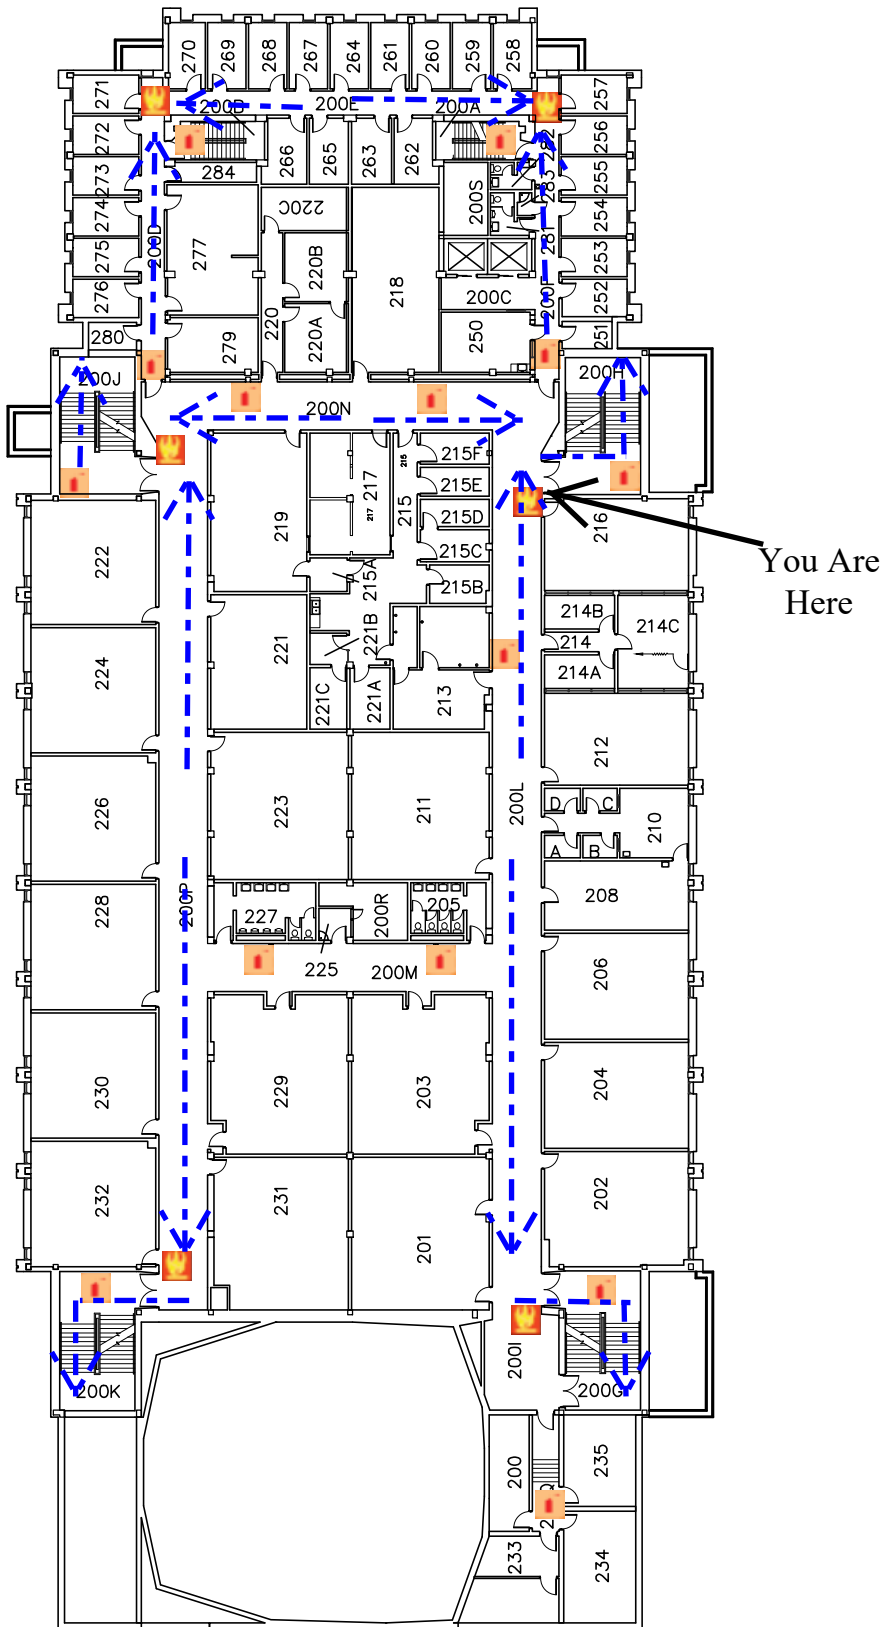


 Fire Alarm Pull
 Fire Extinguisher
 Evacuation Route

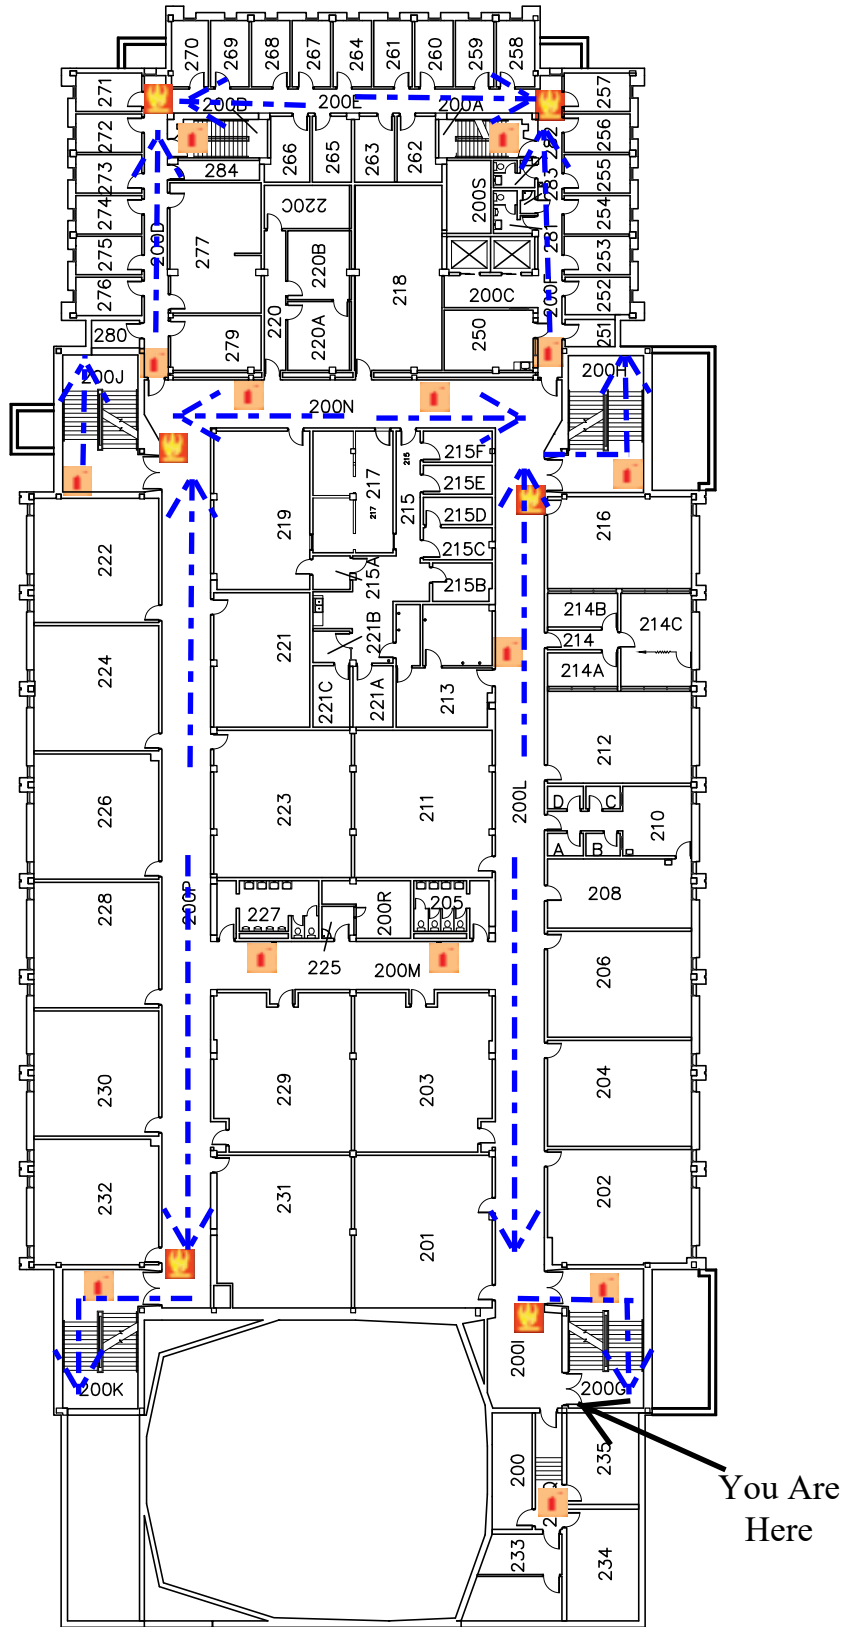

 Fire Alarm Pull
 Fire Extinguisher
 Evacuation Route

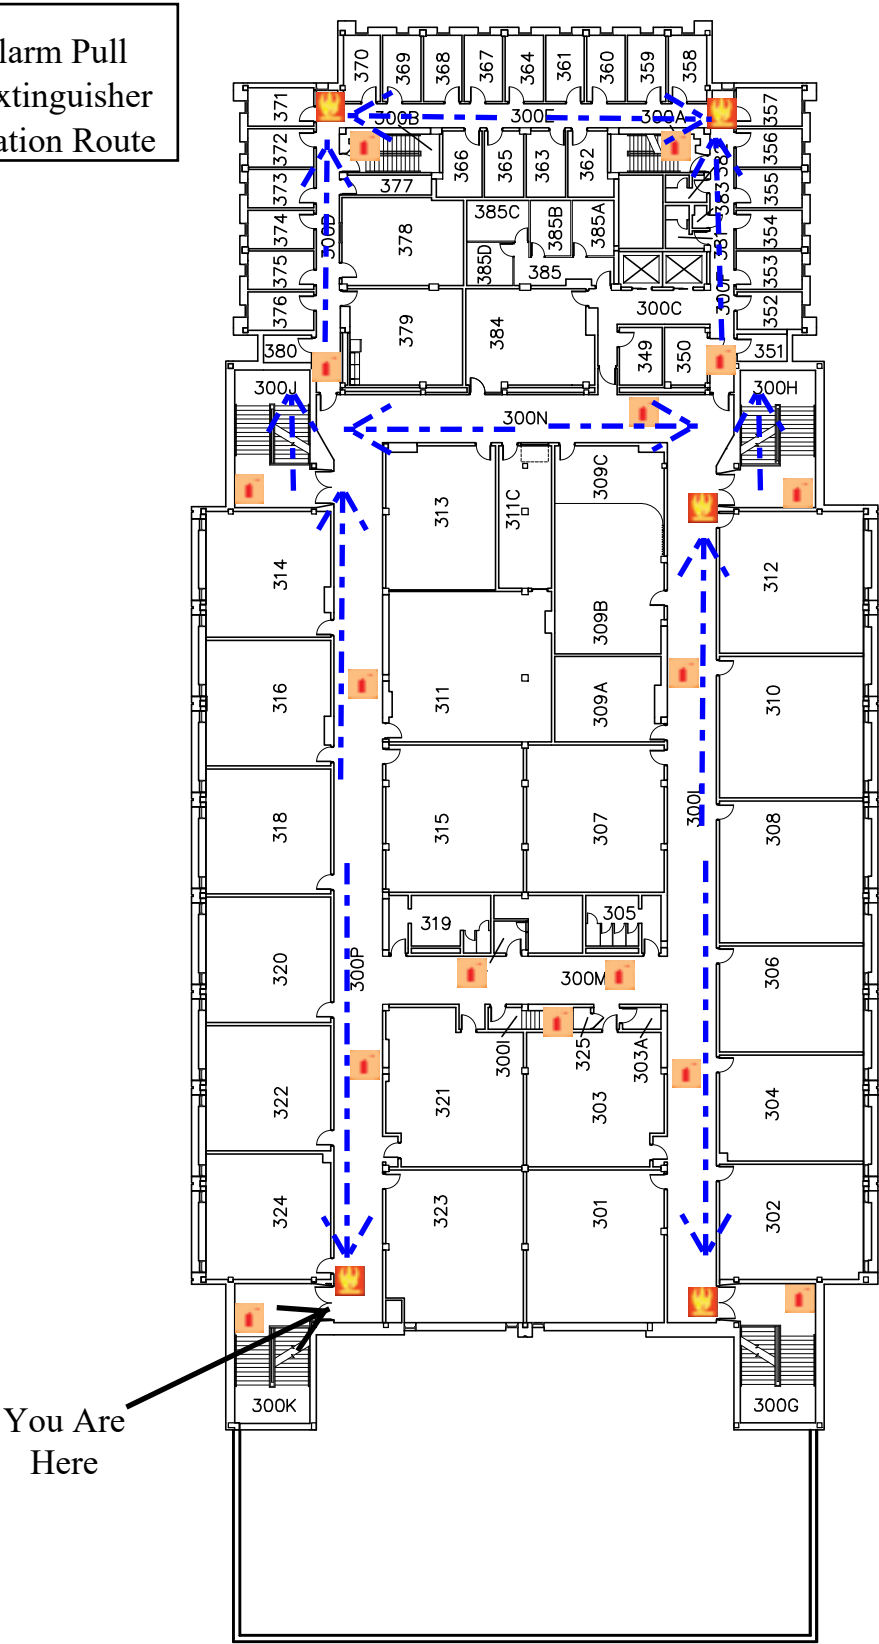


 Fire Alarm Pull
 Fire Extinguisher
 Evacuation Route

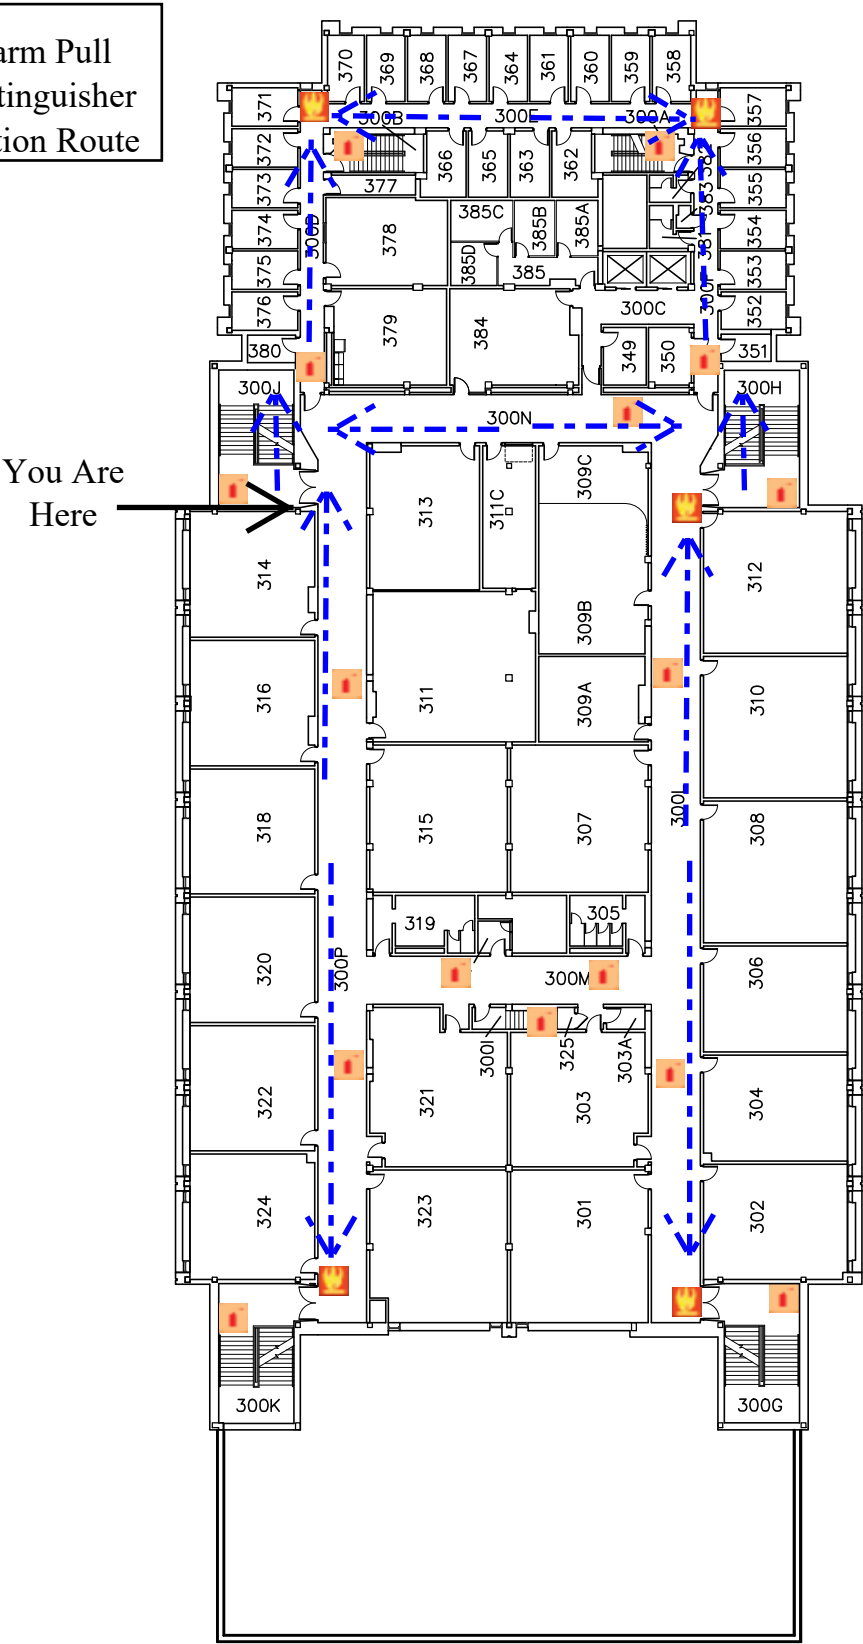

 Fire Alarm Pull
 Fire Extinguisher
 Evacuation Route


You Are Here

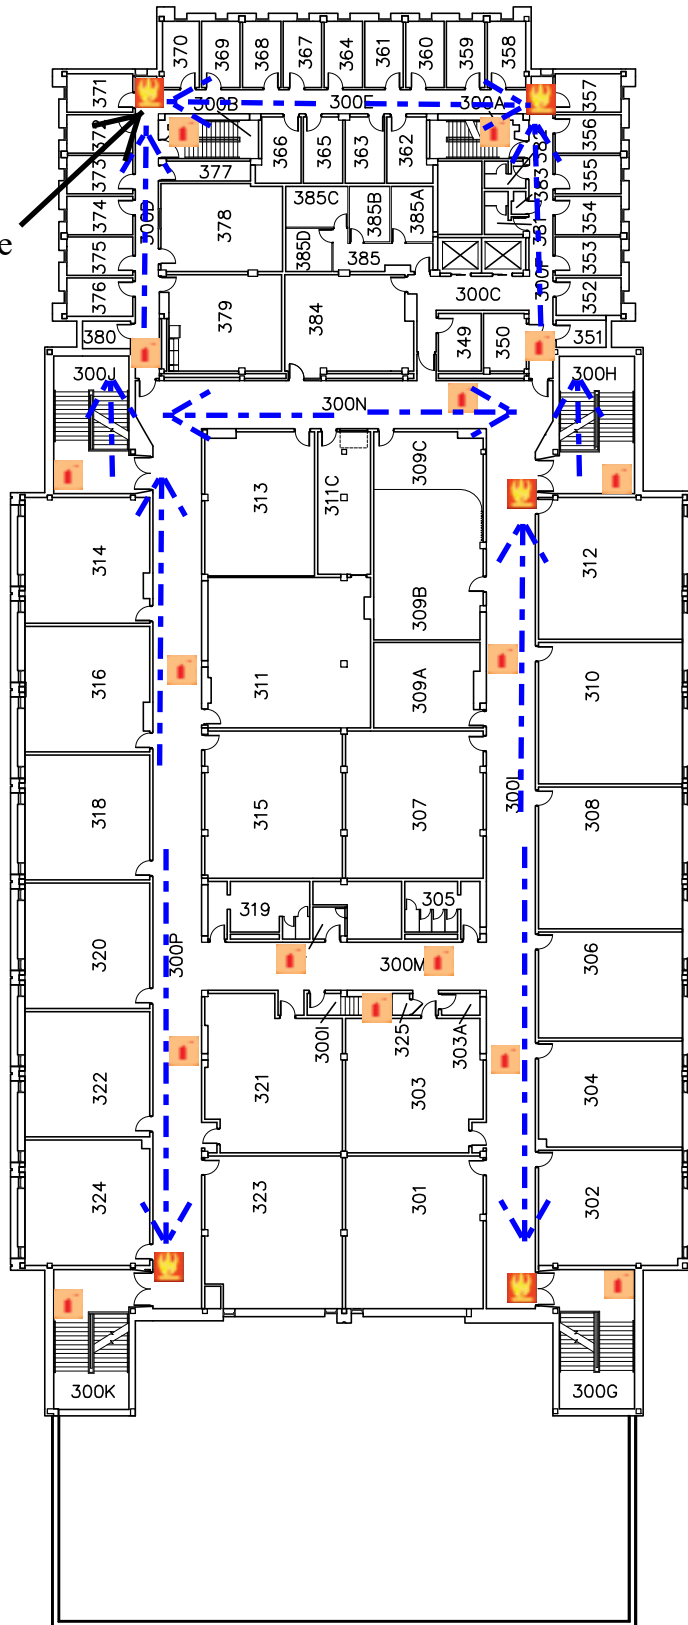


 Fire Alarm Pull
 Fire Extinguisher
 Evacuation Route



 Fire Alarm Pull
 Fire Extinguisher
 Evacuation Route

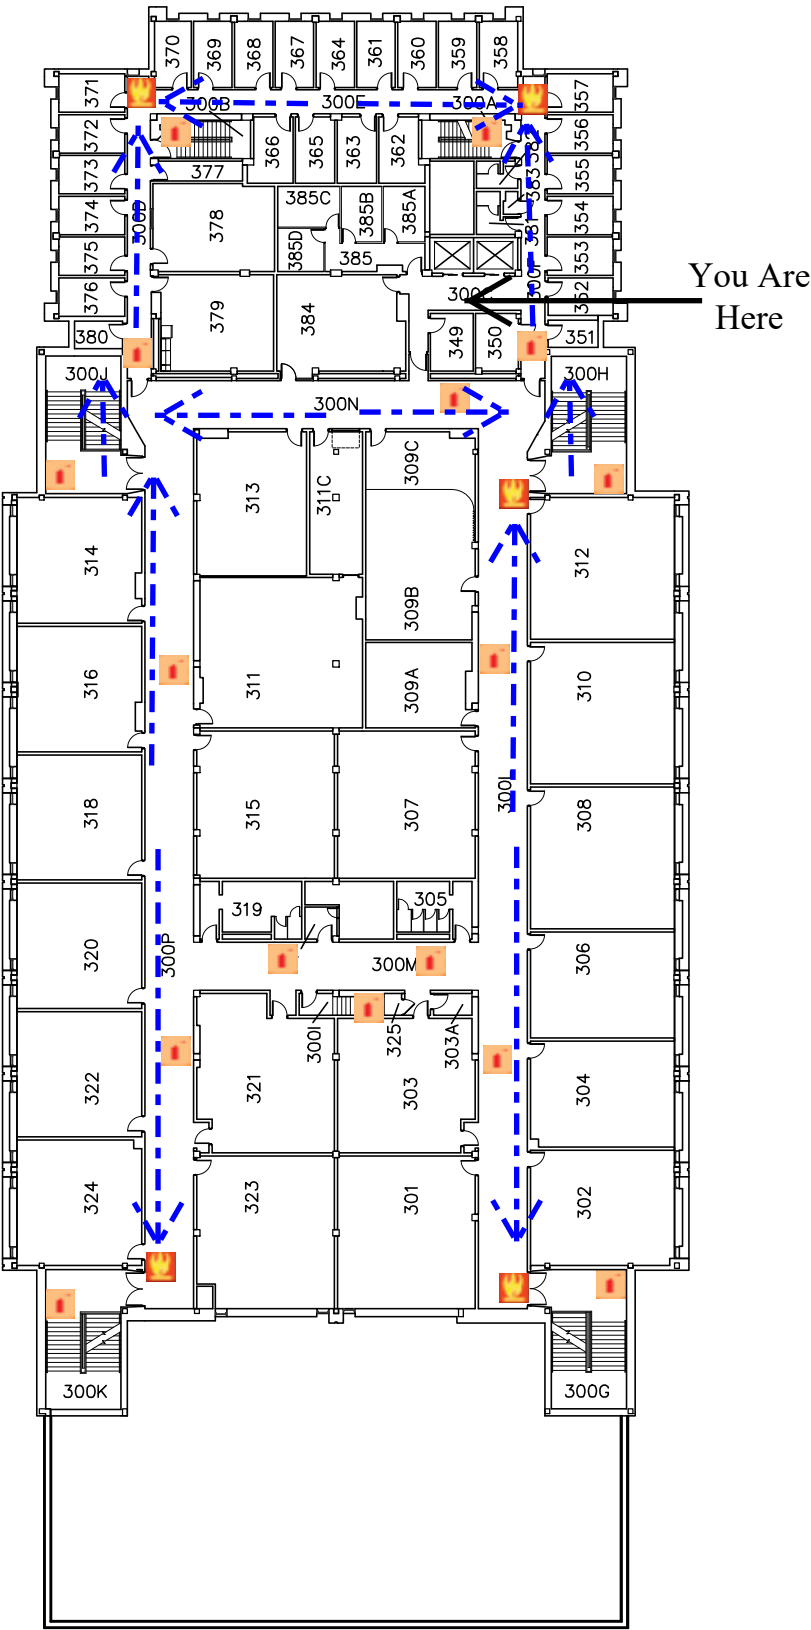

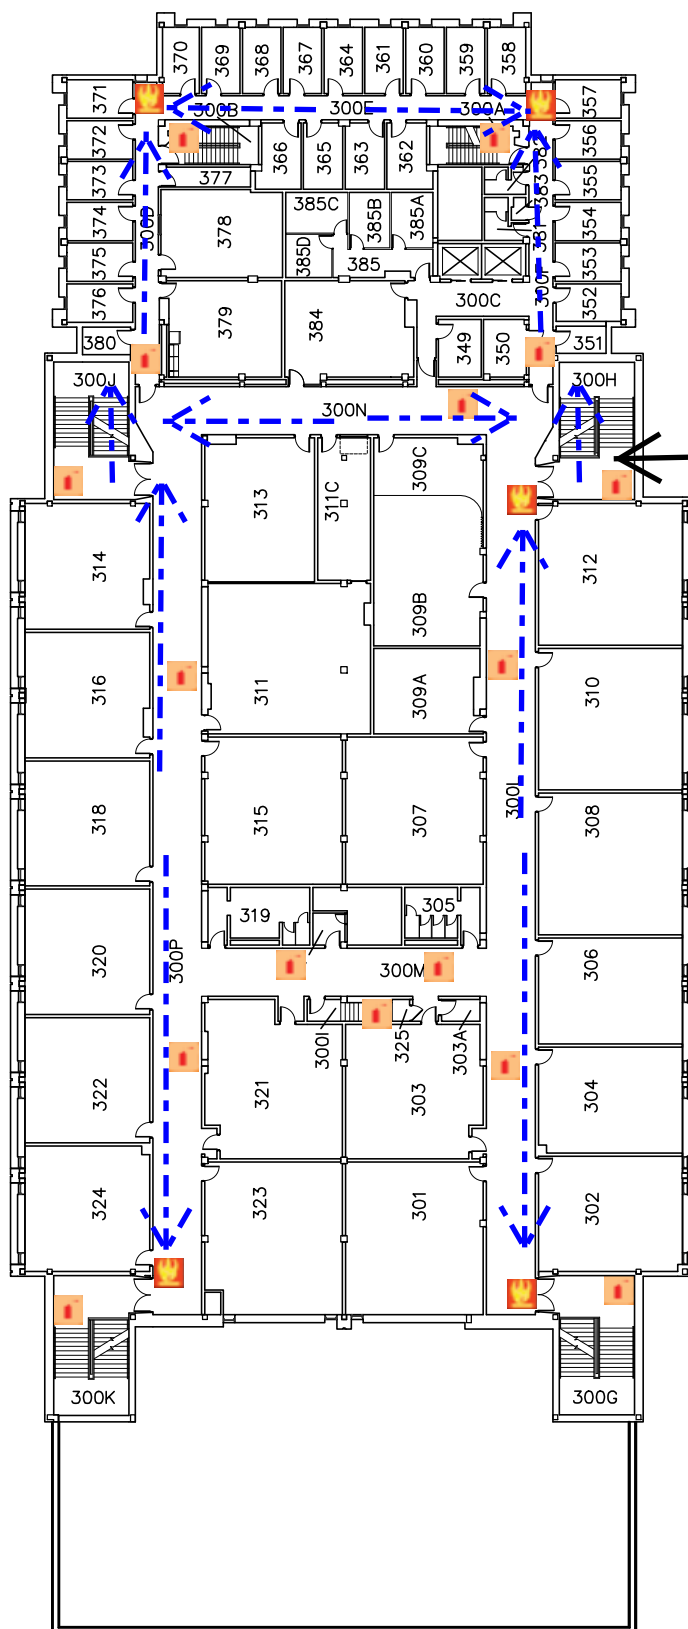


Hibbard Humanities Hall

Third Floor Plan


6



 Fire Alarm Pull
 Fire Extinguisher
 Evacuation Route

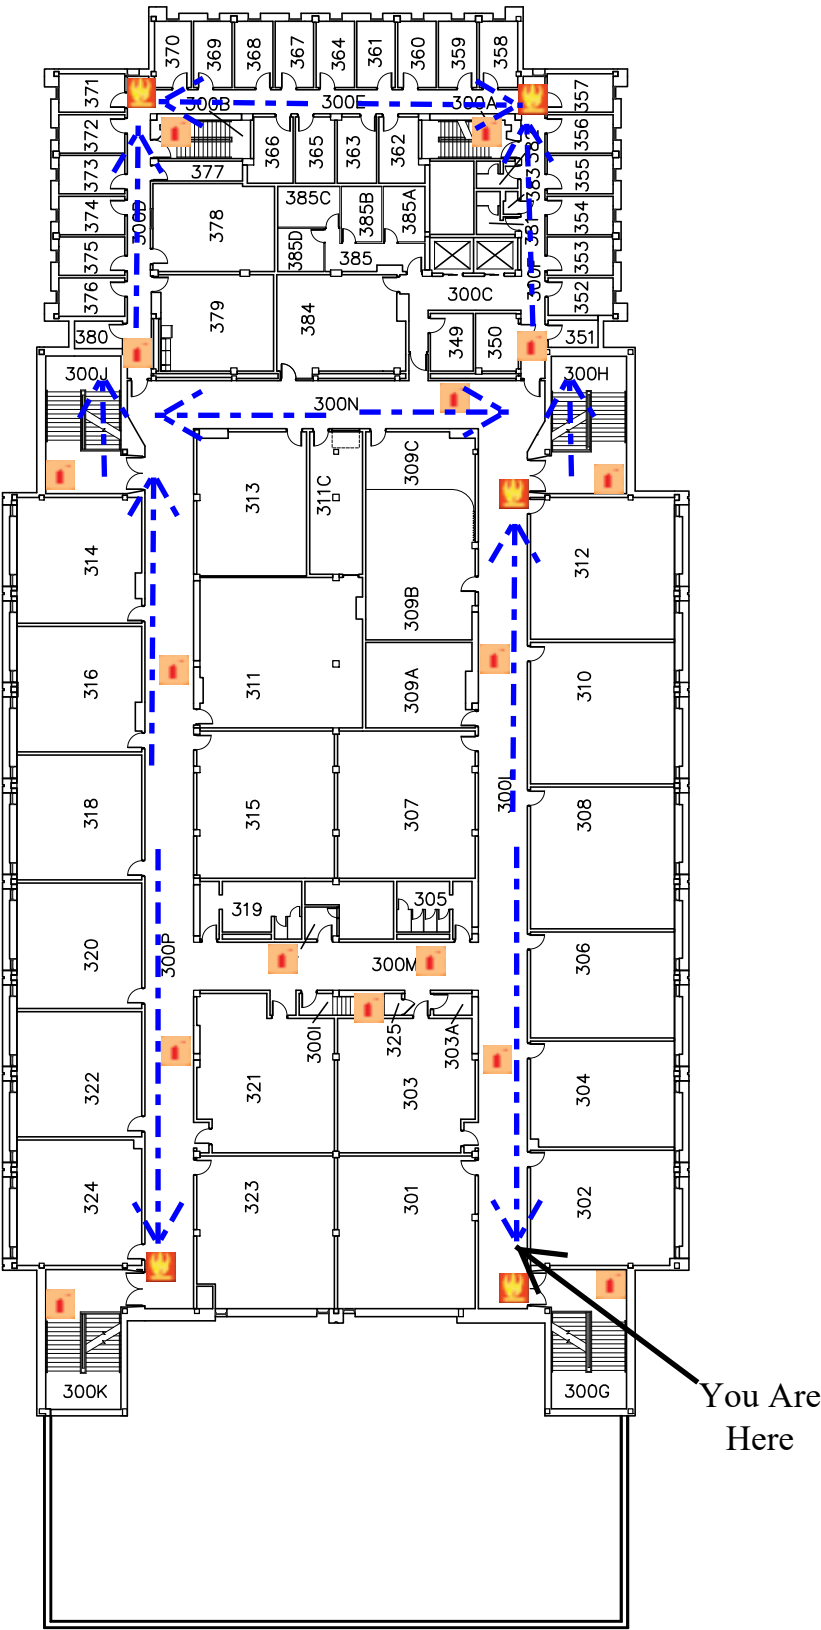

 Fire Alarm Pull
 Fire Extinguisher
 Evacuation Route

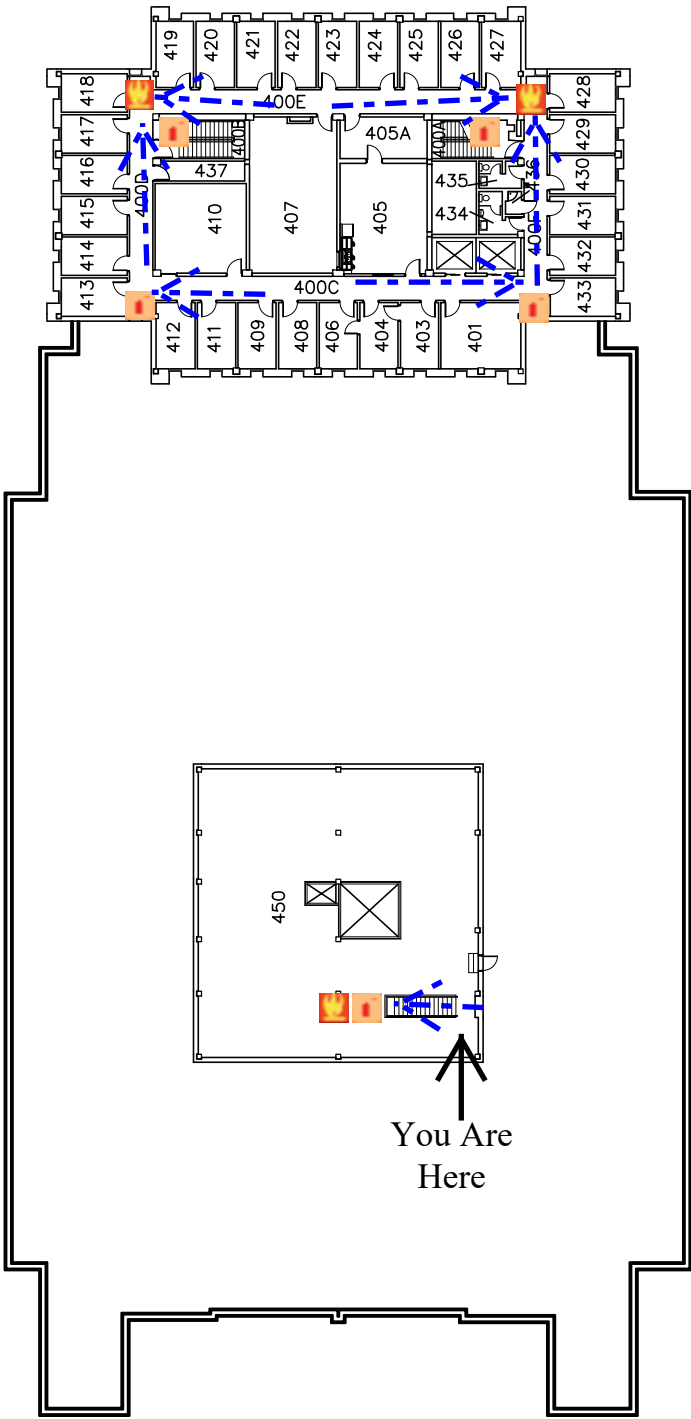

University of Wisconsin-Eau Claire Facilities Planning


Hibbard Humanities Hall
Fourth Floor Plan

DATE:
June 2014
DWG NO:
1




 Fire Alarm Pull
 Fire Extinguisher
 Evacuation Route

You Are Here

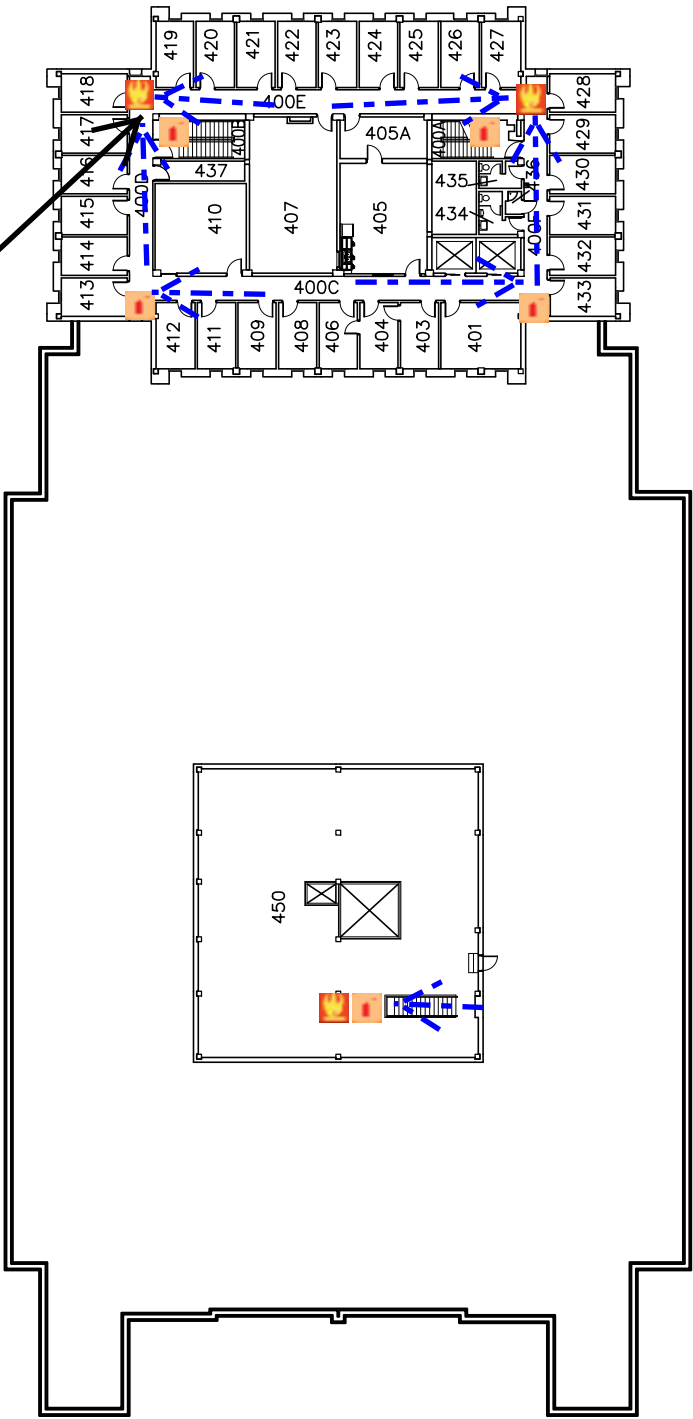

 Fire Alarm Pull
 Fire Extinguisher
 Evacuation Route

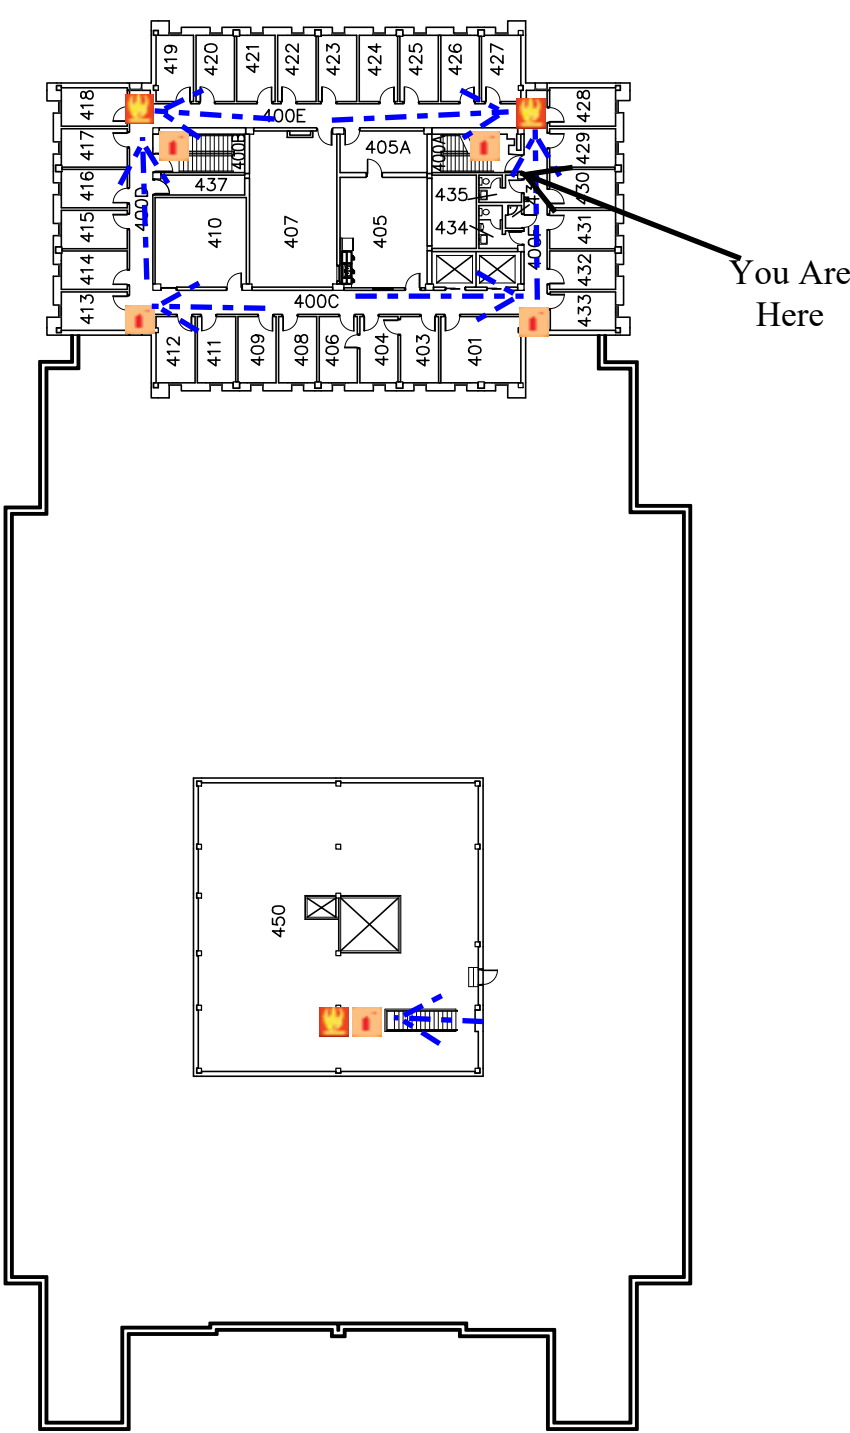


University of Wisconsin-Eau Claire Facilities Planning

Hibbard Humanities Hall
Fourth Floor Plan

DATE:
June 2014
DWG NO:
3




 Fire Alarm Pull
 Fire Extinguisher
 Evacuation Route

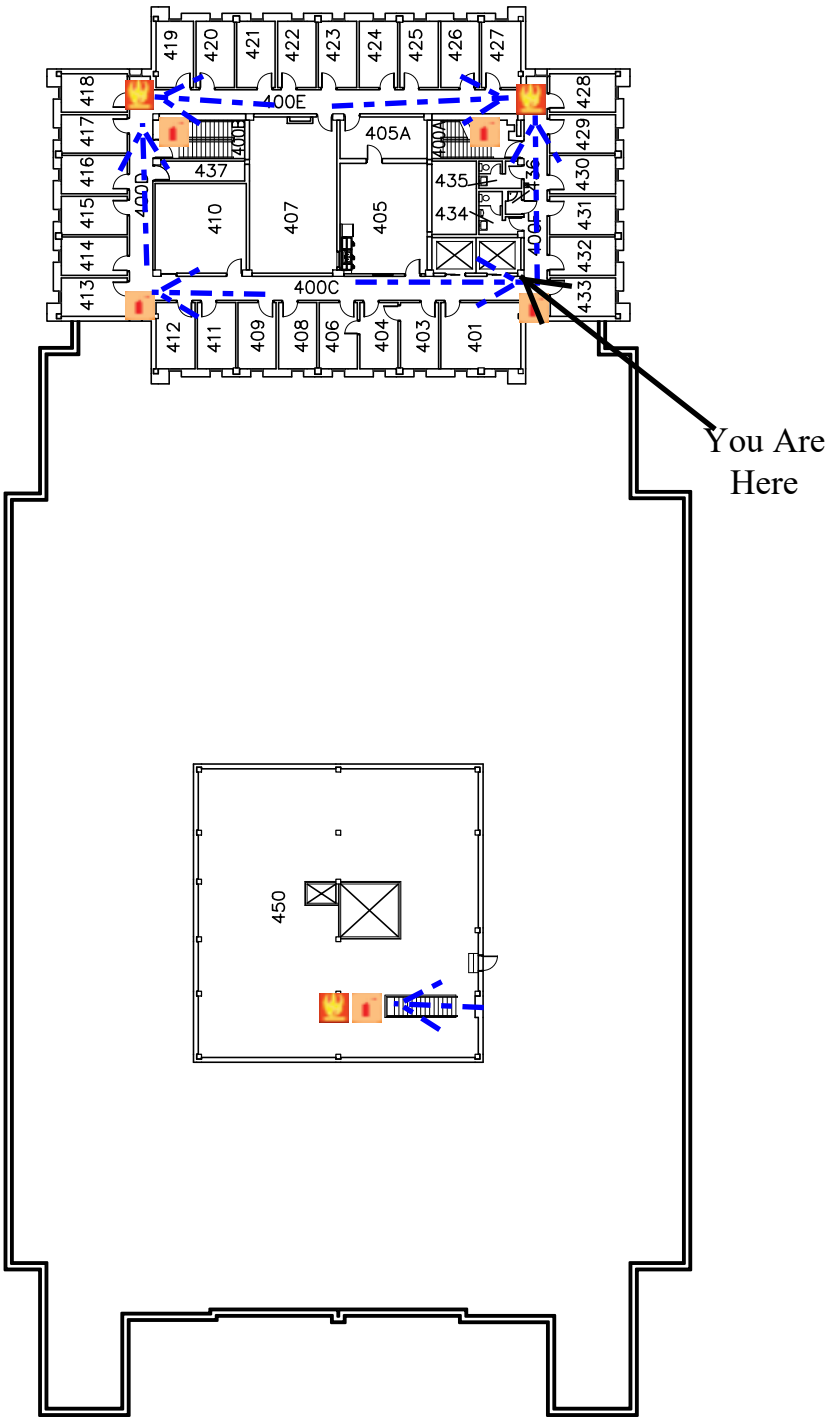

 Fire Alarm Pull
 Fire Extinguisher
 Evacuation Route

You Are Here

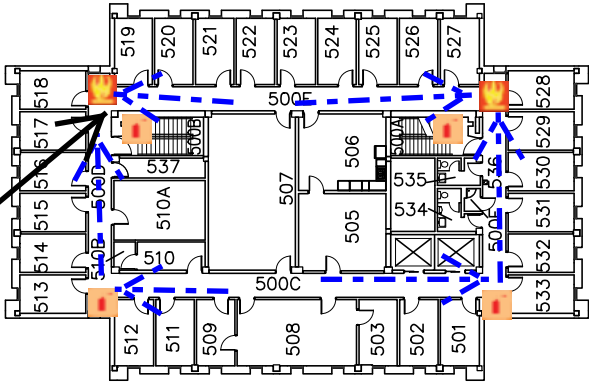

University of Wisconsin-Eau Claire
 Facilities Planning

Hibbard Humanities Hall
 Fifth Floor Plan

DATE:


Nov. 2011

DWG NO:

1




 Fire Alarm Pull
 Fire Extinguisher
 Evacuation Route

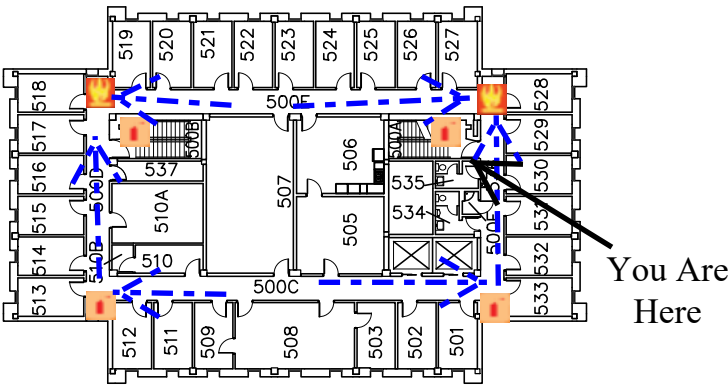


Fire Alarm Pull



Fire Extinguisher


Evacuation Route

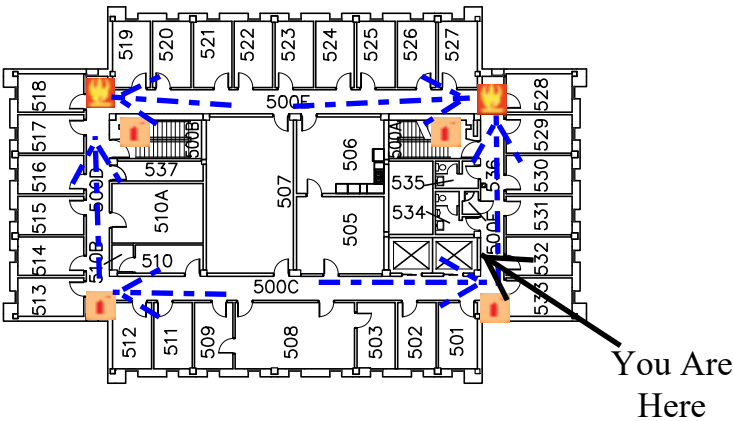


 Fire Alarm Pull
 Fire Extinguisher
 Evacuation Route

You Are Here

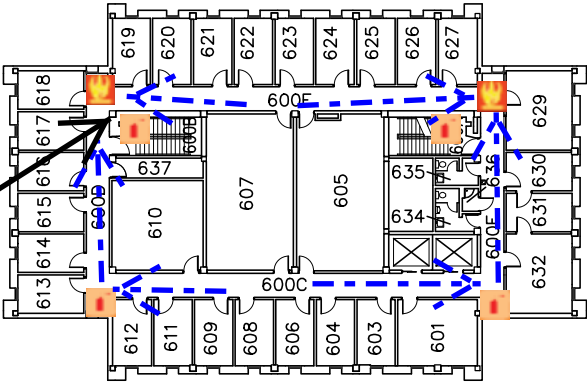


 Fire Alarm Pull
 Fire Extinguisher
 Evacuation Route

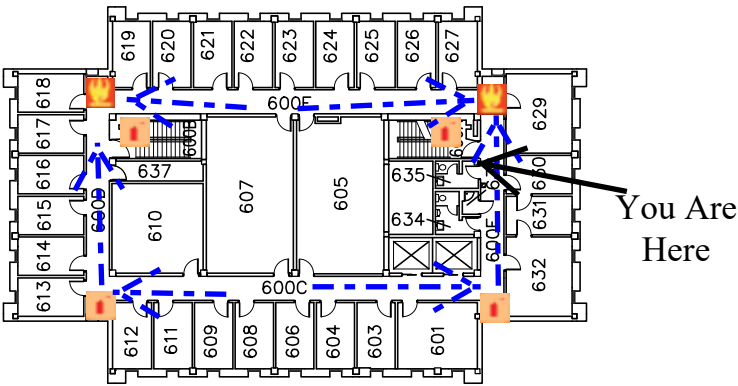


Fire Alarm Pull



Fire Extinguisher


Evacuation Route

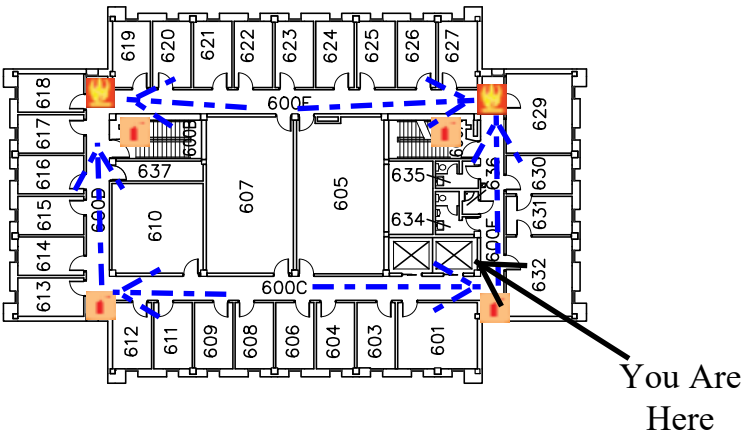

 Fire Alarm Pull
 Fire Extinguisher
 Evacuation Route

You Are Here

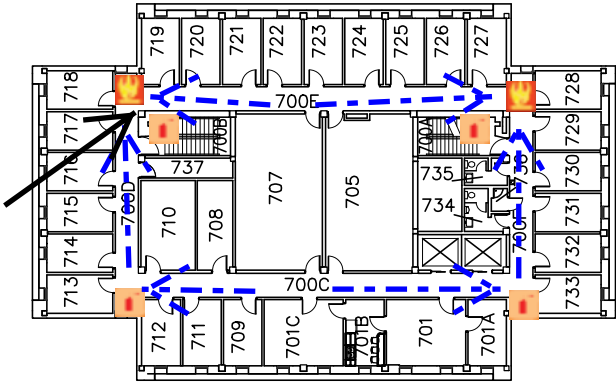


University of Wisconsin-Eau Claire Facilities Planning

Hibbard Humanities Hall
Seventh Floor Plan

DATE:
April 2010
DWG NO:
1



 Fire Alarm Pull
 Fire Extinguisher
 Evacuation Route

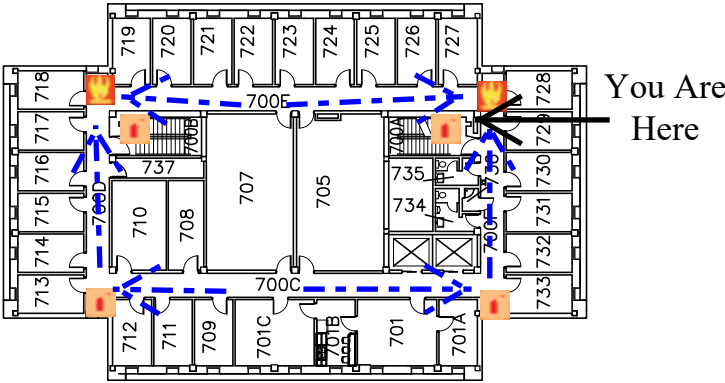


University of Wisconsin-Eau Claire Facilities Planning

Hibbard Humanities Hall
Seventh Floor Plan


DATE:
April 2010
DWG NO:
2



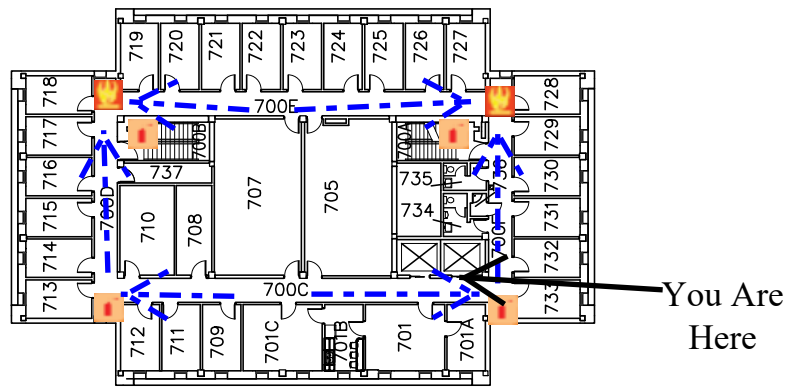

 Fire Alarm Pull
 Fire Extinguisher
 Evacuation Route

You Are Here

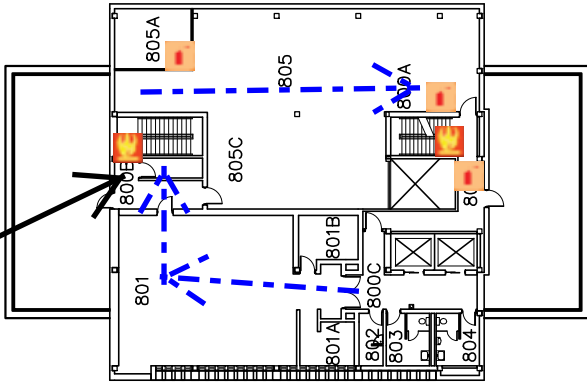

University of Wisconsin-Eau Claire Facilities Planning

Hibbard Humanities Hall
Penthouse Plan


DATE:
May 2010
DWG NO:
1




Fire Alarm Pull


Fire Extinguisher



Evacuation Route

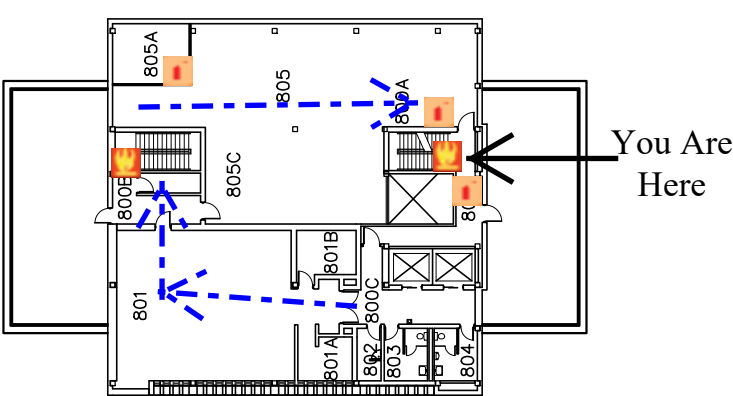


Fire Alarm Pull


Fire Extinguisher


Evacuation Route

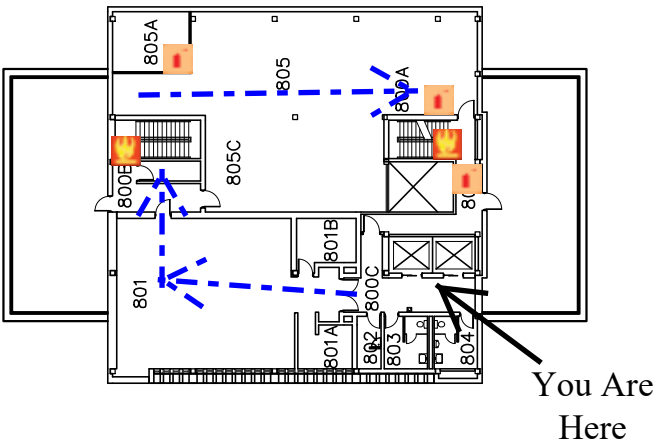

University of Wisconsin-Eau Claire Facilities Planning

Hibbard Humanities Hall
Penthouse Plan

DATE:
May 2010
DWG NO:
3



 Fire Alarm Pull
  Fire Extinguisher
  Evacuation Route

