


	Fire Alarm Pull
	Fire Extinguisher
	AED
	Evacuation Route
	Shelter Areas (Severe Weather)

  
**Assembly Point-  
 Nursing Parking Lot**

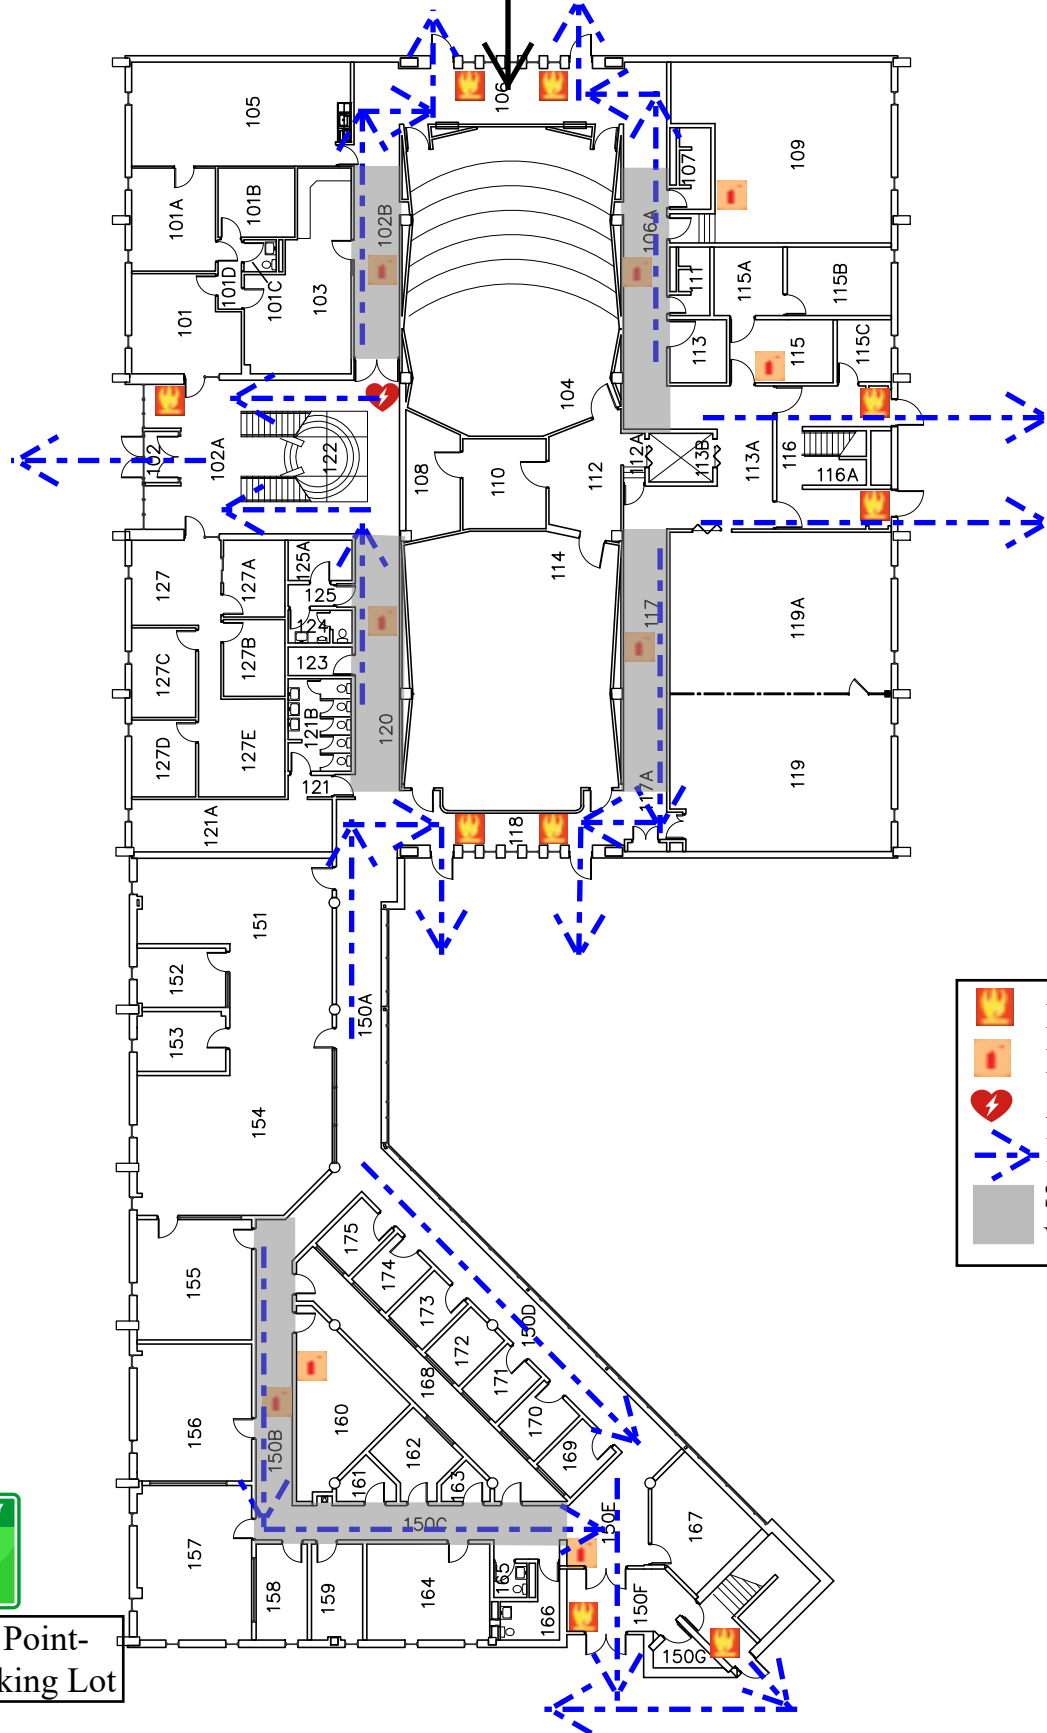

You Are Here



	Fire Alarm Pull
	Fire Extinguisher
	AED
	Evacuation Route
	Shelter Areas (Severe Weather)

  
**Assembly Point-  
 Nursing Parking Lot**




University of Wisconsin-Eau Claire Facilities Planning






**School of Nursing  
 First Floor Plan**

DATE:  
 Oct 2021

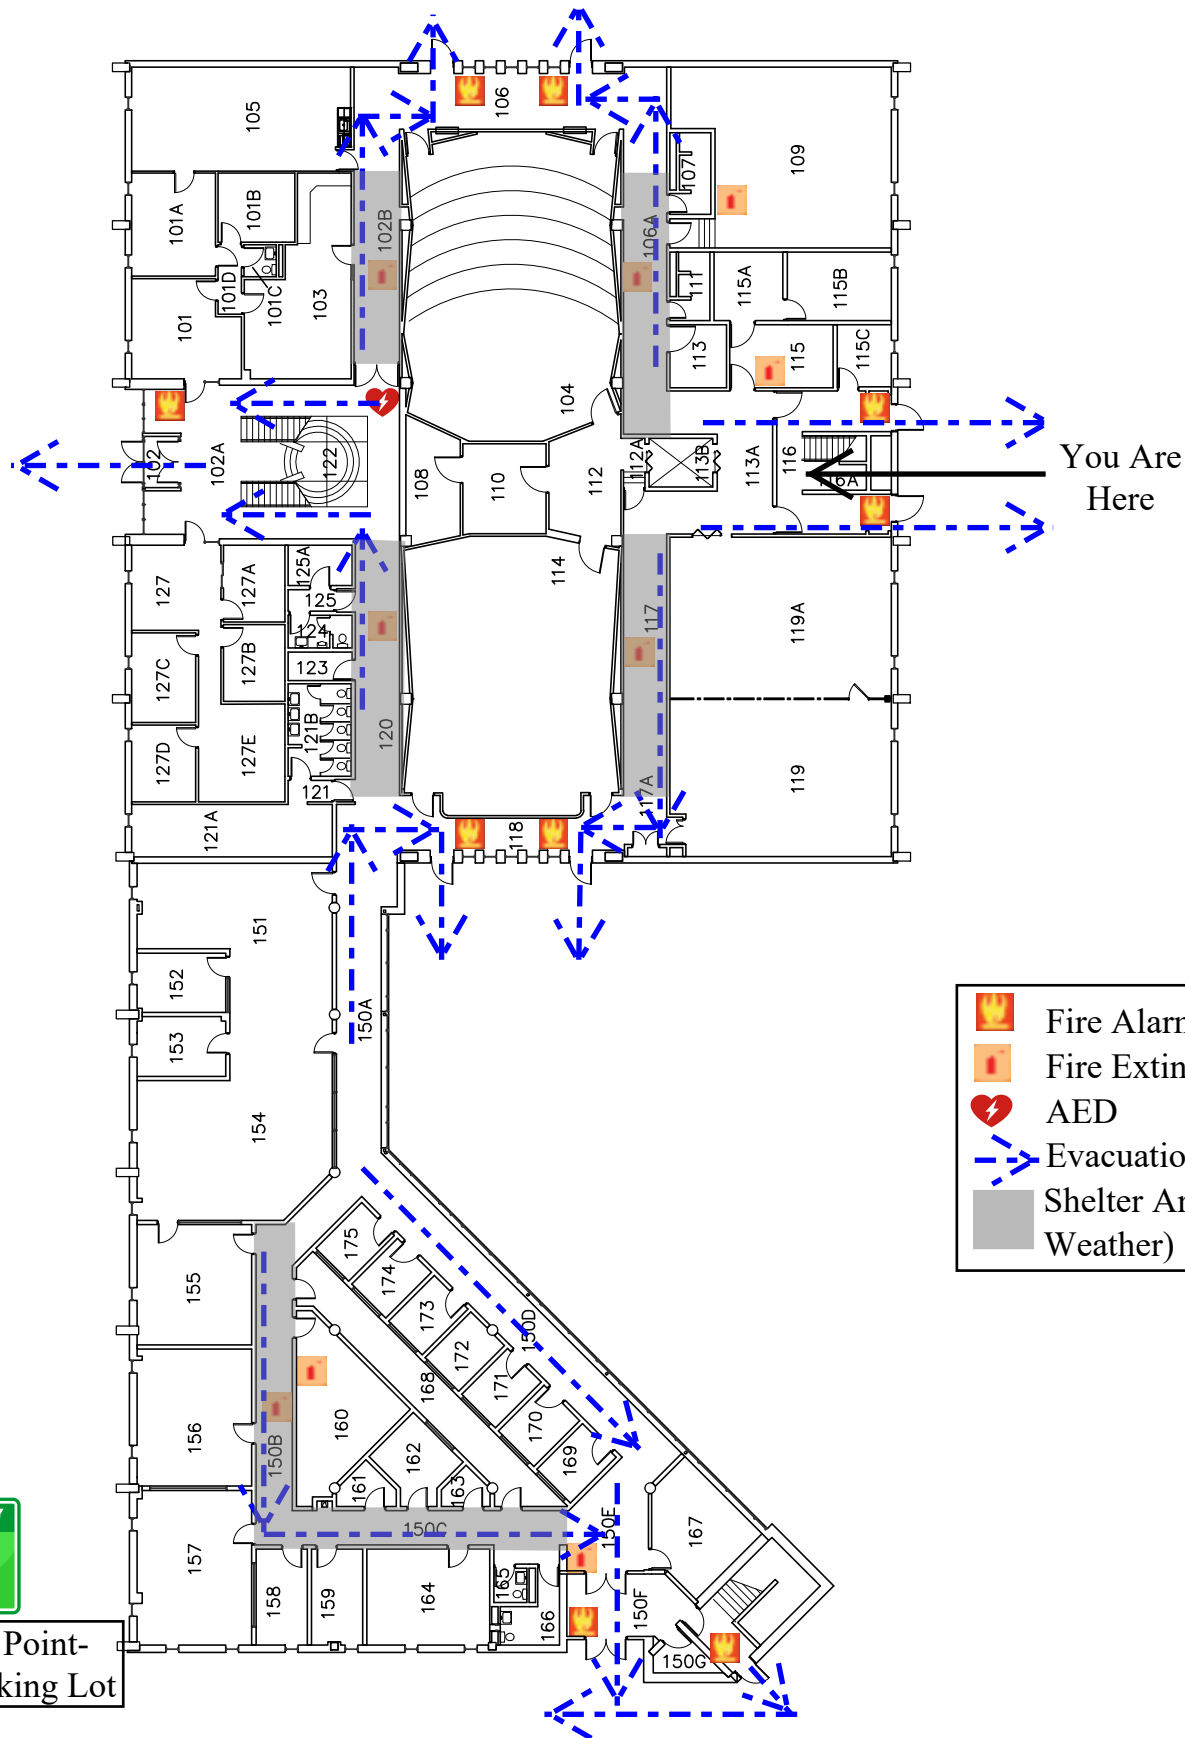DWG NO:  
 2





-  Fire Alarm Pull
-  Fire Extinguisher
-  AED
-  Evacuation Route
-  Shelter Areas (Severe Weather)




Assembly Point-Nursing Parking Lot








University of Wisconsin-Eau Claire Facilities Planning  
**School of Nursing**  
**First Floor Plan**

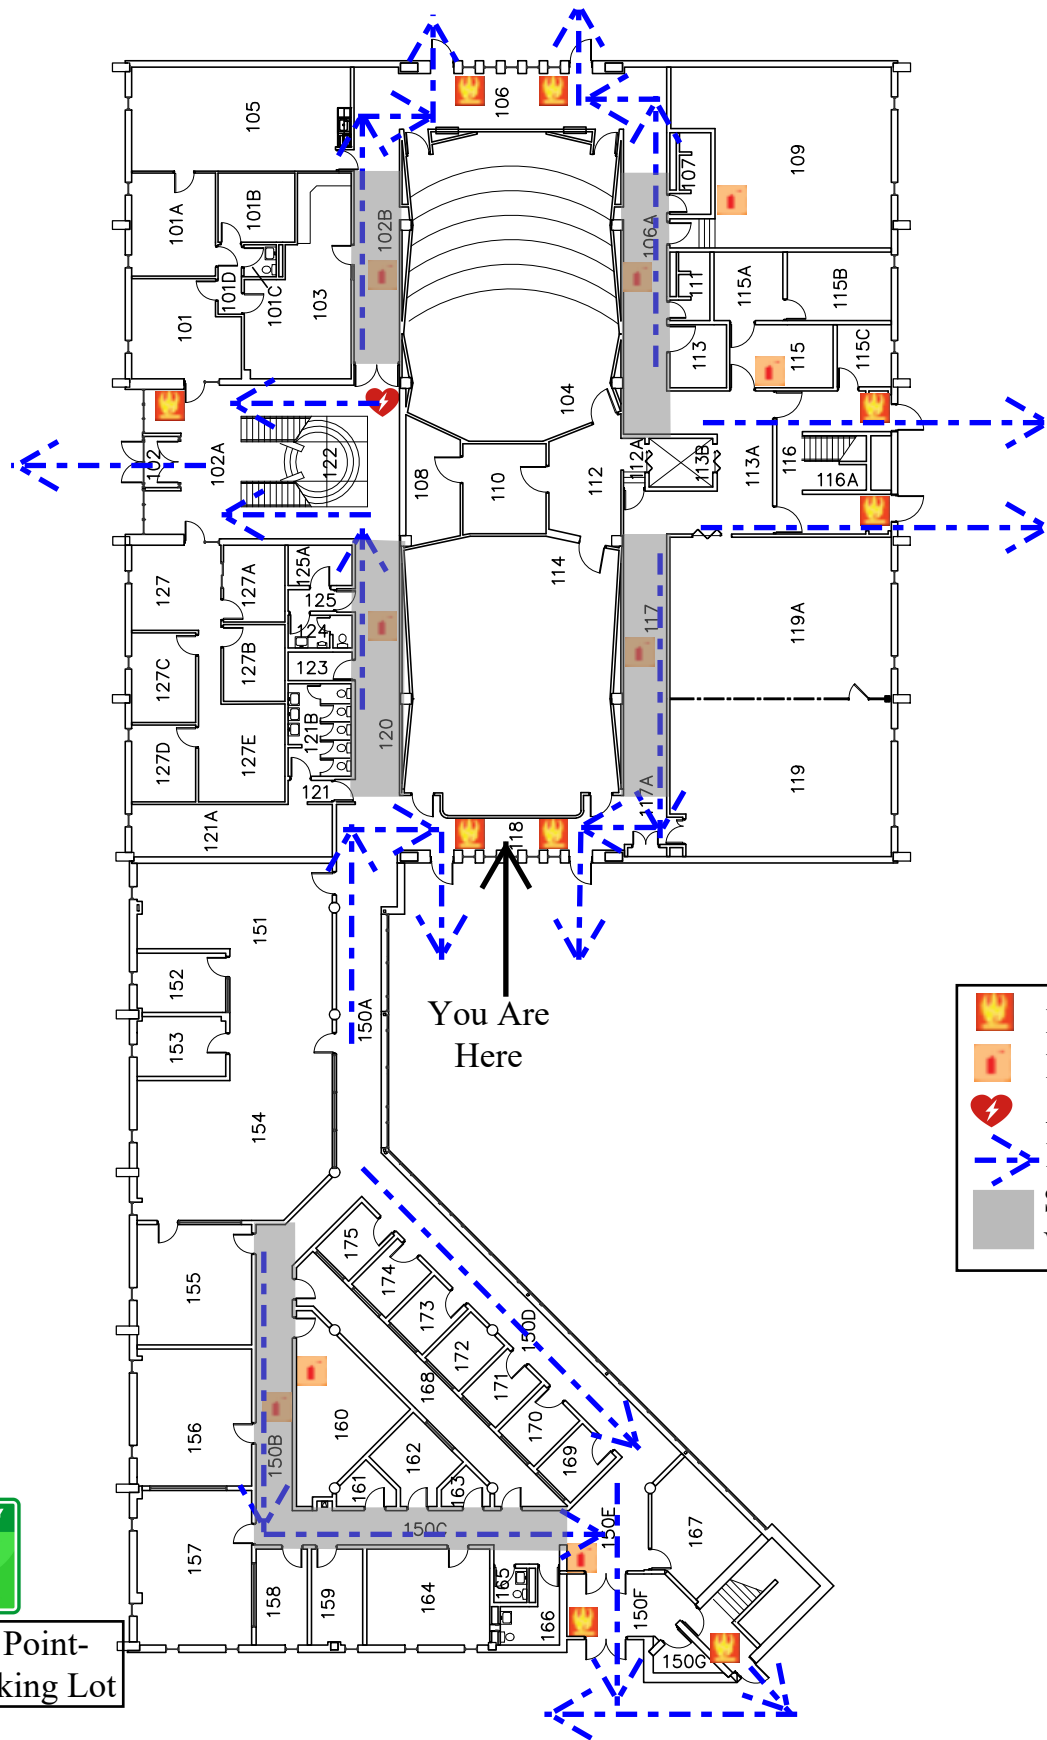DATE:  
 Oct 2021  
 DWG NO:  
 3





-  Fire Alarm Pull
-  Fire Extinguisher
-  AED
-  Evacuation Route
-  Shelter Areas (Severe Weather)



Assembly Point -  
Nursing Parking Lot




University of Wisconsin-Eau Claire Facilities Planning

# School of Nursing First Floor Plan

DATE:
Oct 2021
DWG NO:
4



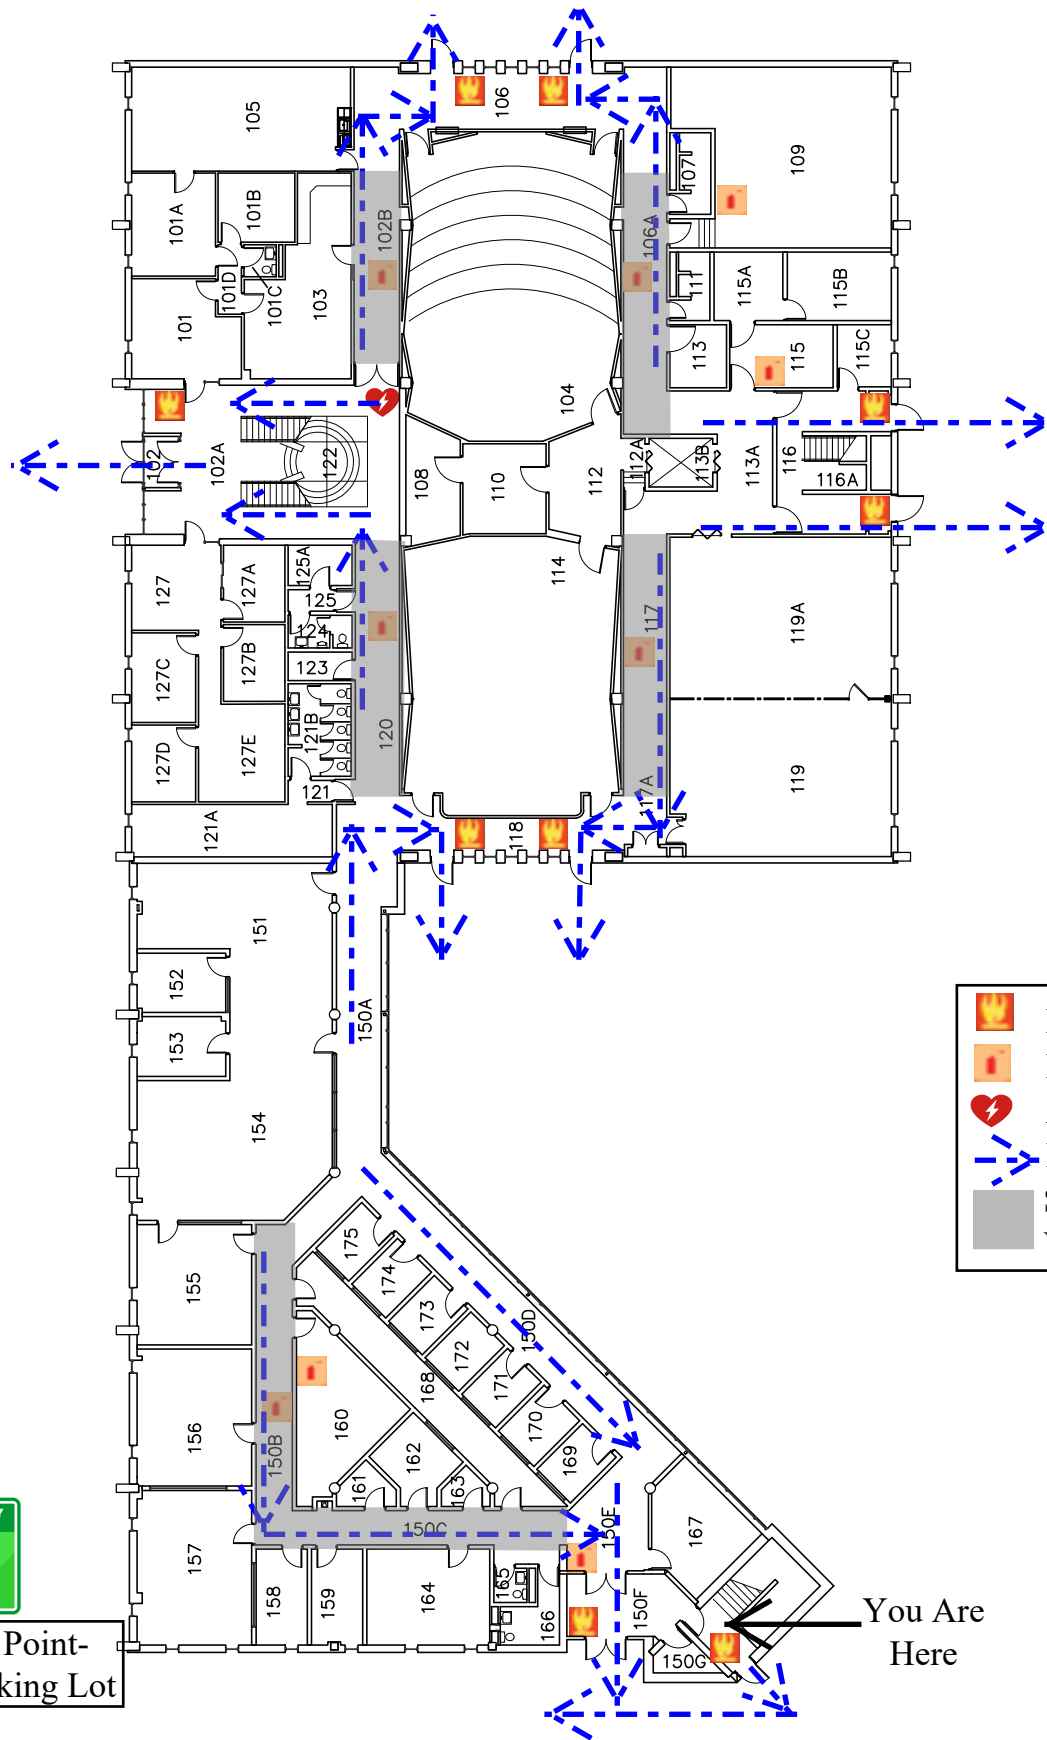

	Fire Alarm Pull
	Fire Extinguisher
	AED
	Evacuation Route
	Shelter Areas (Severe Weather)



Assembly Point-  
Nursing Parking Lot

You Are  
Here




University of Wisconsin-Eau Claire Facilities Planning

# School of Nursing First Floor Plan

DATE:	Oct 2021
DWG NO:	5



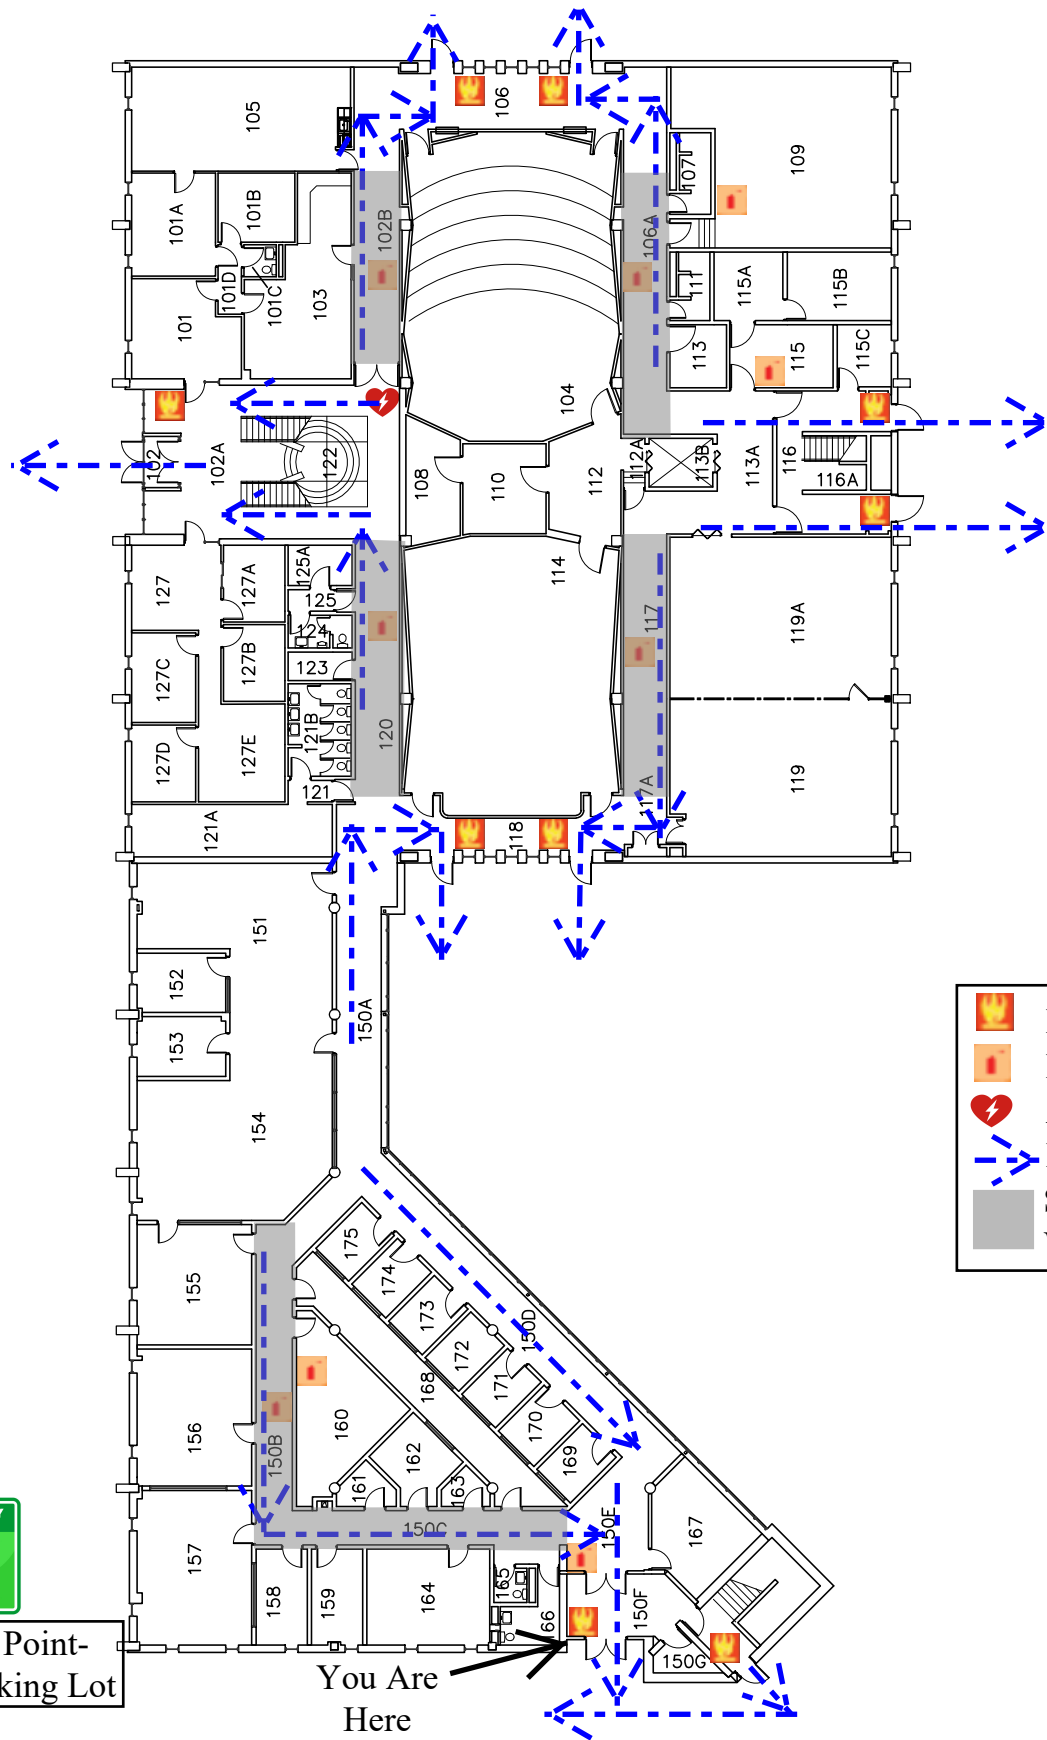

	Fire Alarm Pull
	Fire Extinguisher
	AED
	Evacuation Route
	Shelter Areas (Severe Weather)



Assembly Point-  
Nursing Parking Lot

You Are  
Here







University of Wisconsin-Eau Claire Facilities Planning

# School of Nursing First Floor Plan

DATE:  
Oct 2021  
DWG NO:  
6

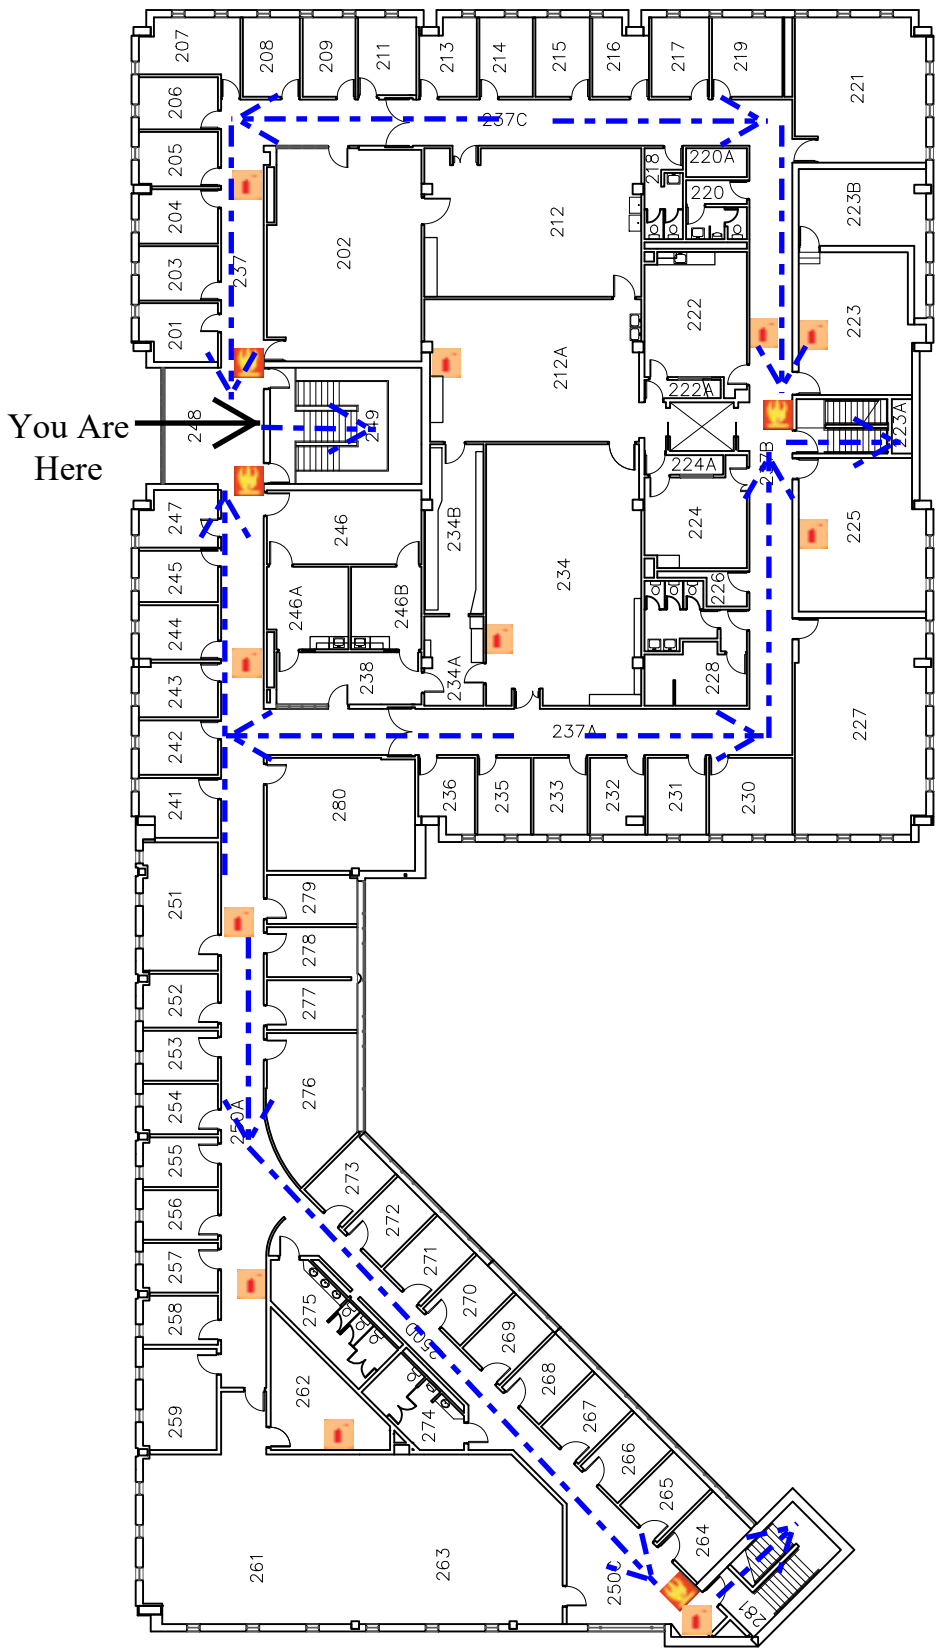



-  Fire Alarm Pull
-  Fire Extinguisher
-  Evacuation Route



University of Wisconsin-Eau Claire

Facilities Planning

# School of Nursing Second Floor Plan


DATE:

Oct 2021




DWG NO:

1

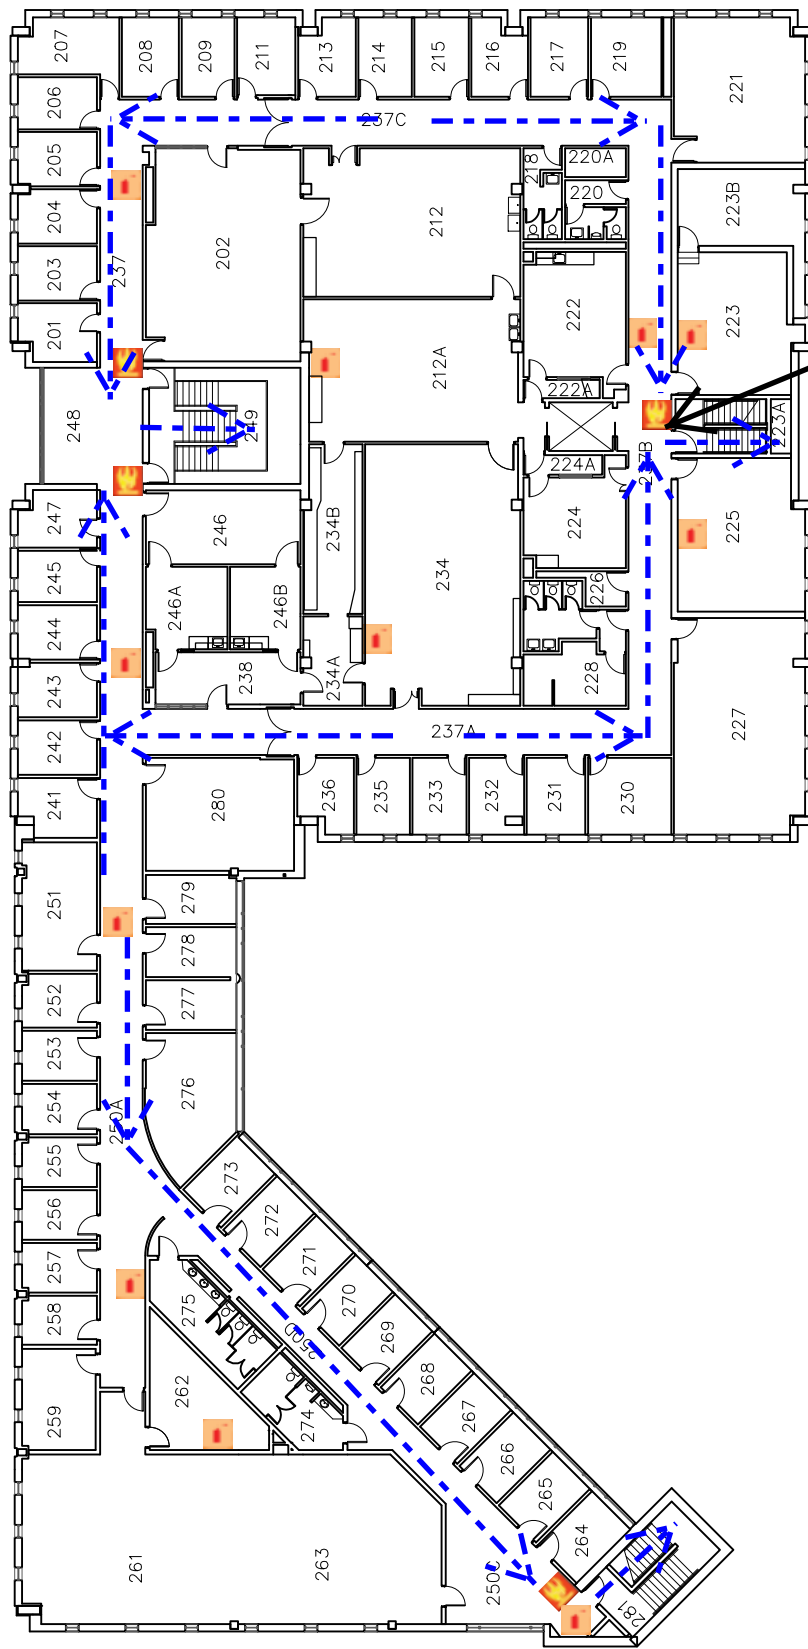



You Are Here

-  Fire Alarm Pull
-  Fire Extinguisher
-  Evacuation Route



University of Wisconsin-Eau Claire

Facilities Planning

# School of Nursing Second Floor Plan

DATE:


Oct 2021




DWG NO:

2



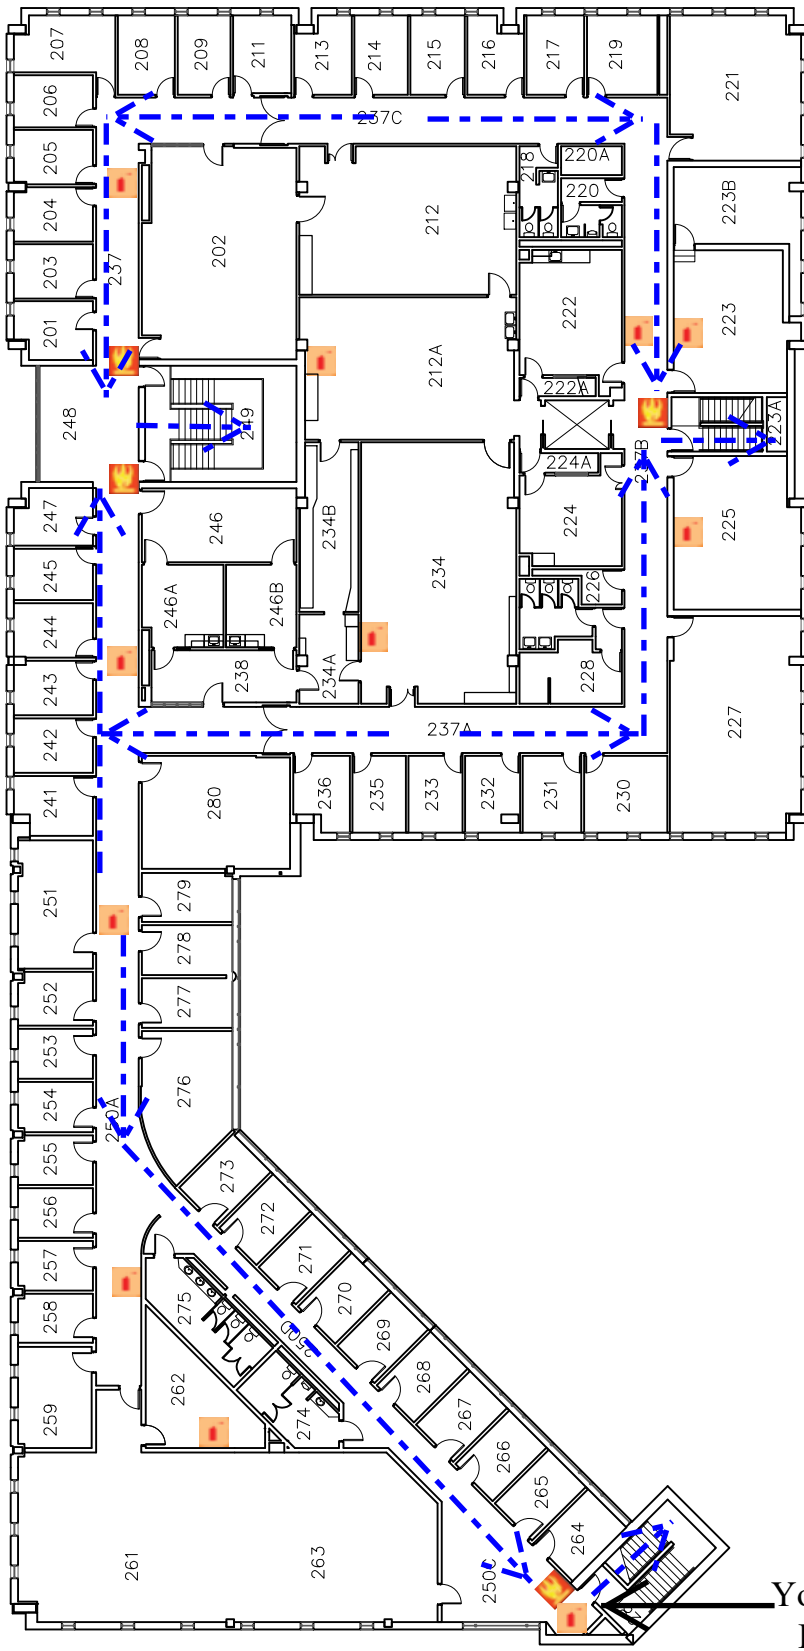



-  Fire Alarm Pull
-  Fire Extinguisher
-  Evacuation Route

You Are Here



University of Wisconsin-Eau Claire

Facilities Planning

# School of Nursing Second Floor Plan

DATE:

Oct 2021

DWG NO:

3

