






You Are Here

	Fire Alarm Pull
	Fire Extinguisher
	Evacuation Route
	Shelter Areas (Severe Weather)





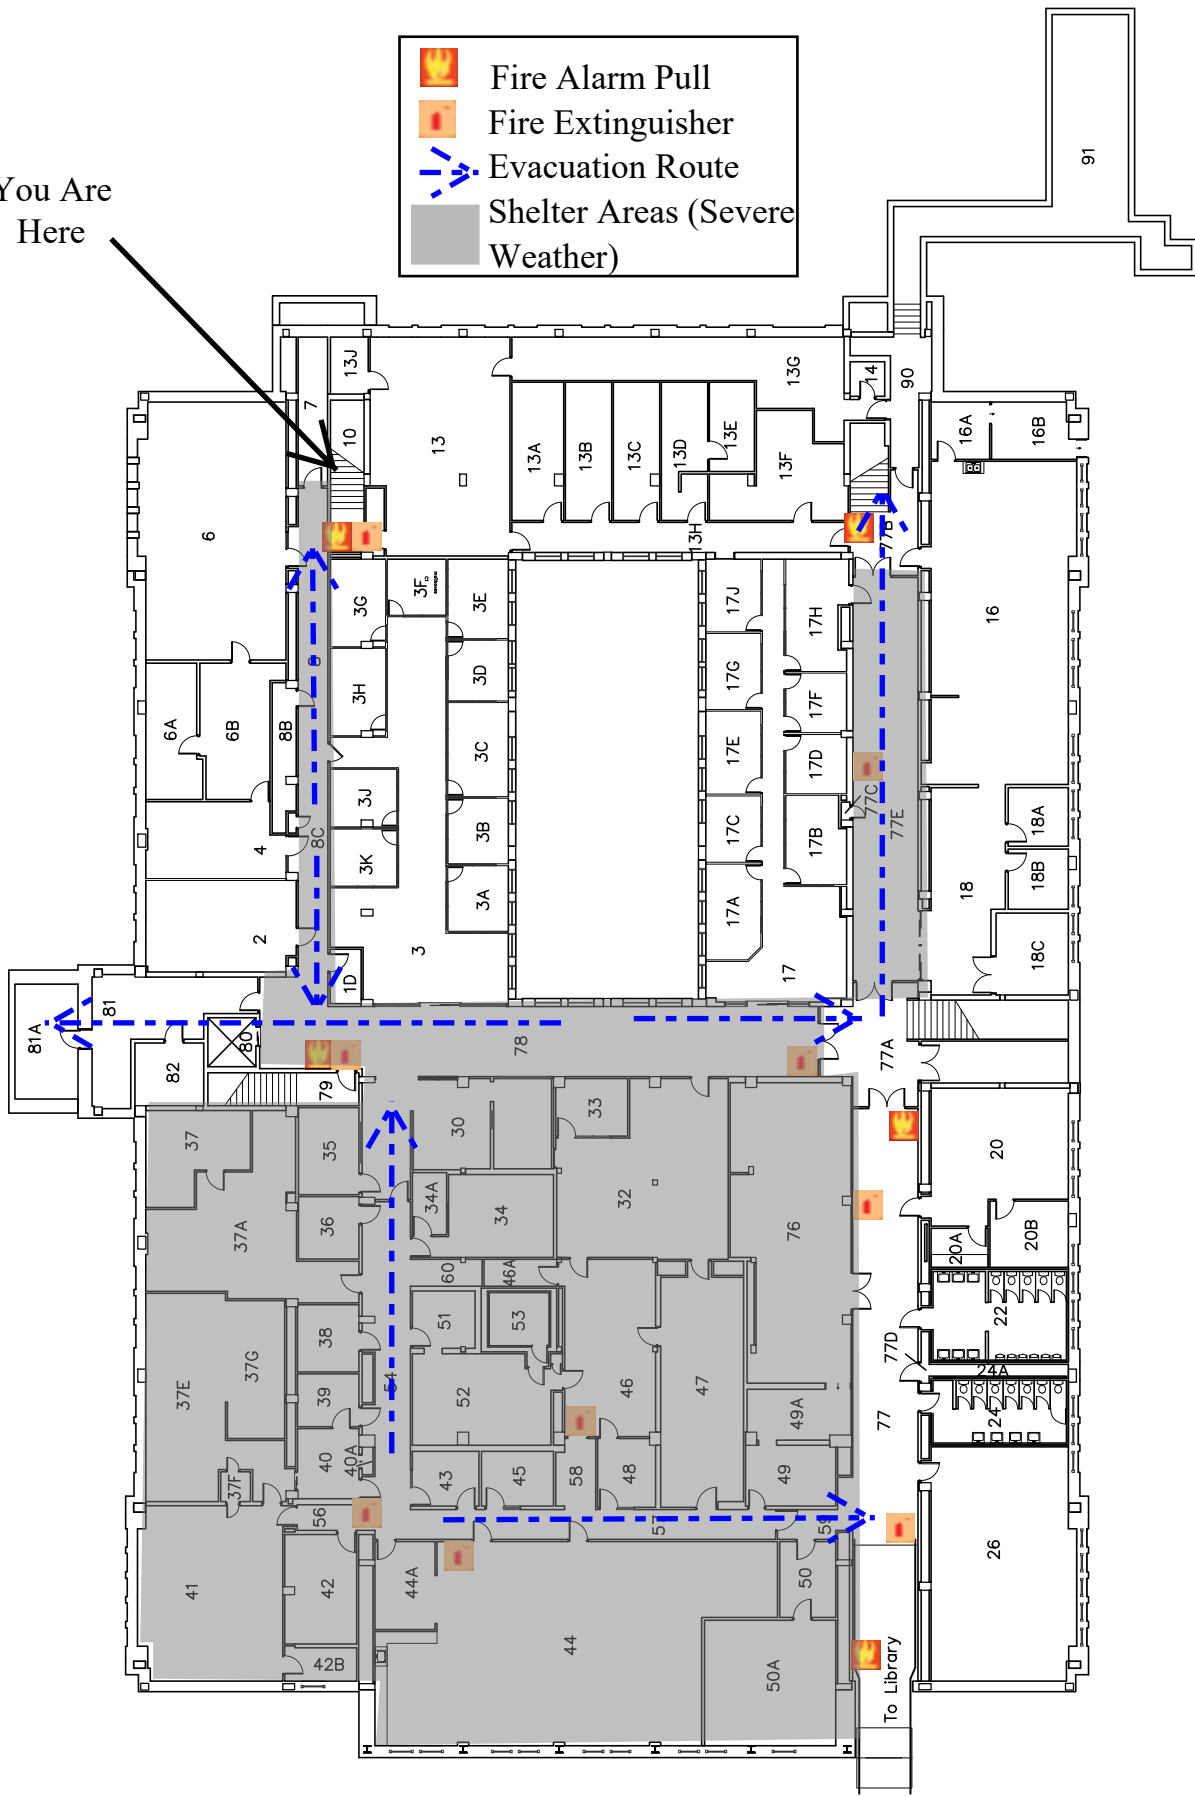


University of Wisconsin-Eau Claire Facilities Planning

Schofield Hall Basement Floor Plan

DATE:
Dec. 2021
DWG NO:
1



-  Fire Alarm Pull
-  Fire Extinguisher
-  Evacuation Route
-  Shelter Areas (Severe Weather)

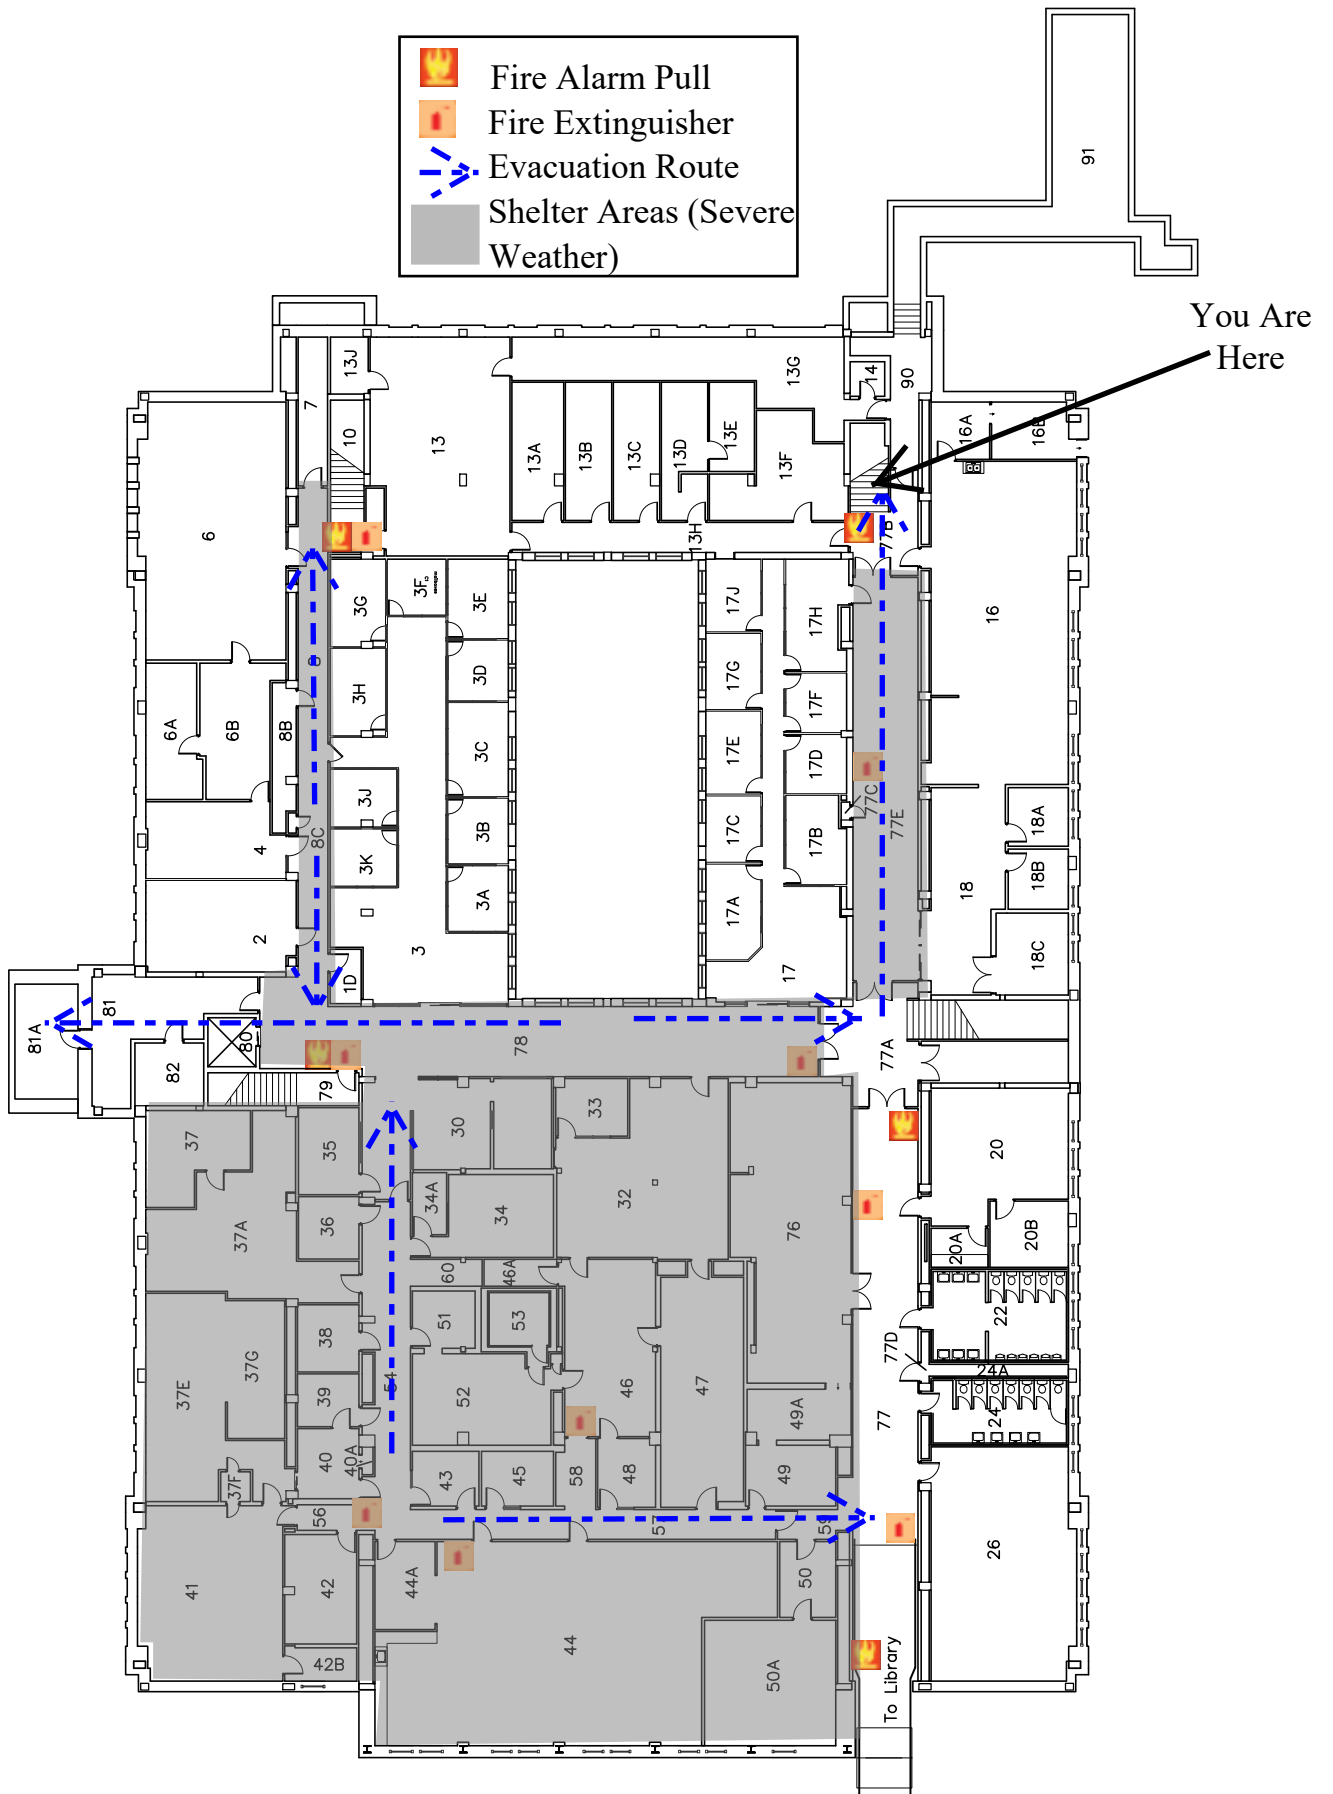






University of Wisconsin-Eau Claire Facilities Planning

Schofield Hall
Basement Floor Plan

DATE:
Dec. 2021
DWG NO:
2



-  Fire Alarm Pull
-  Fire Extinguisher
-  Evacuation Route
-  Shelter Areas (Severe Weather)

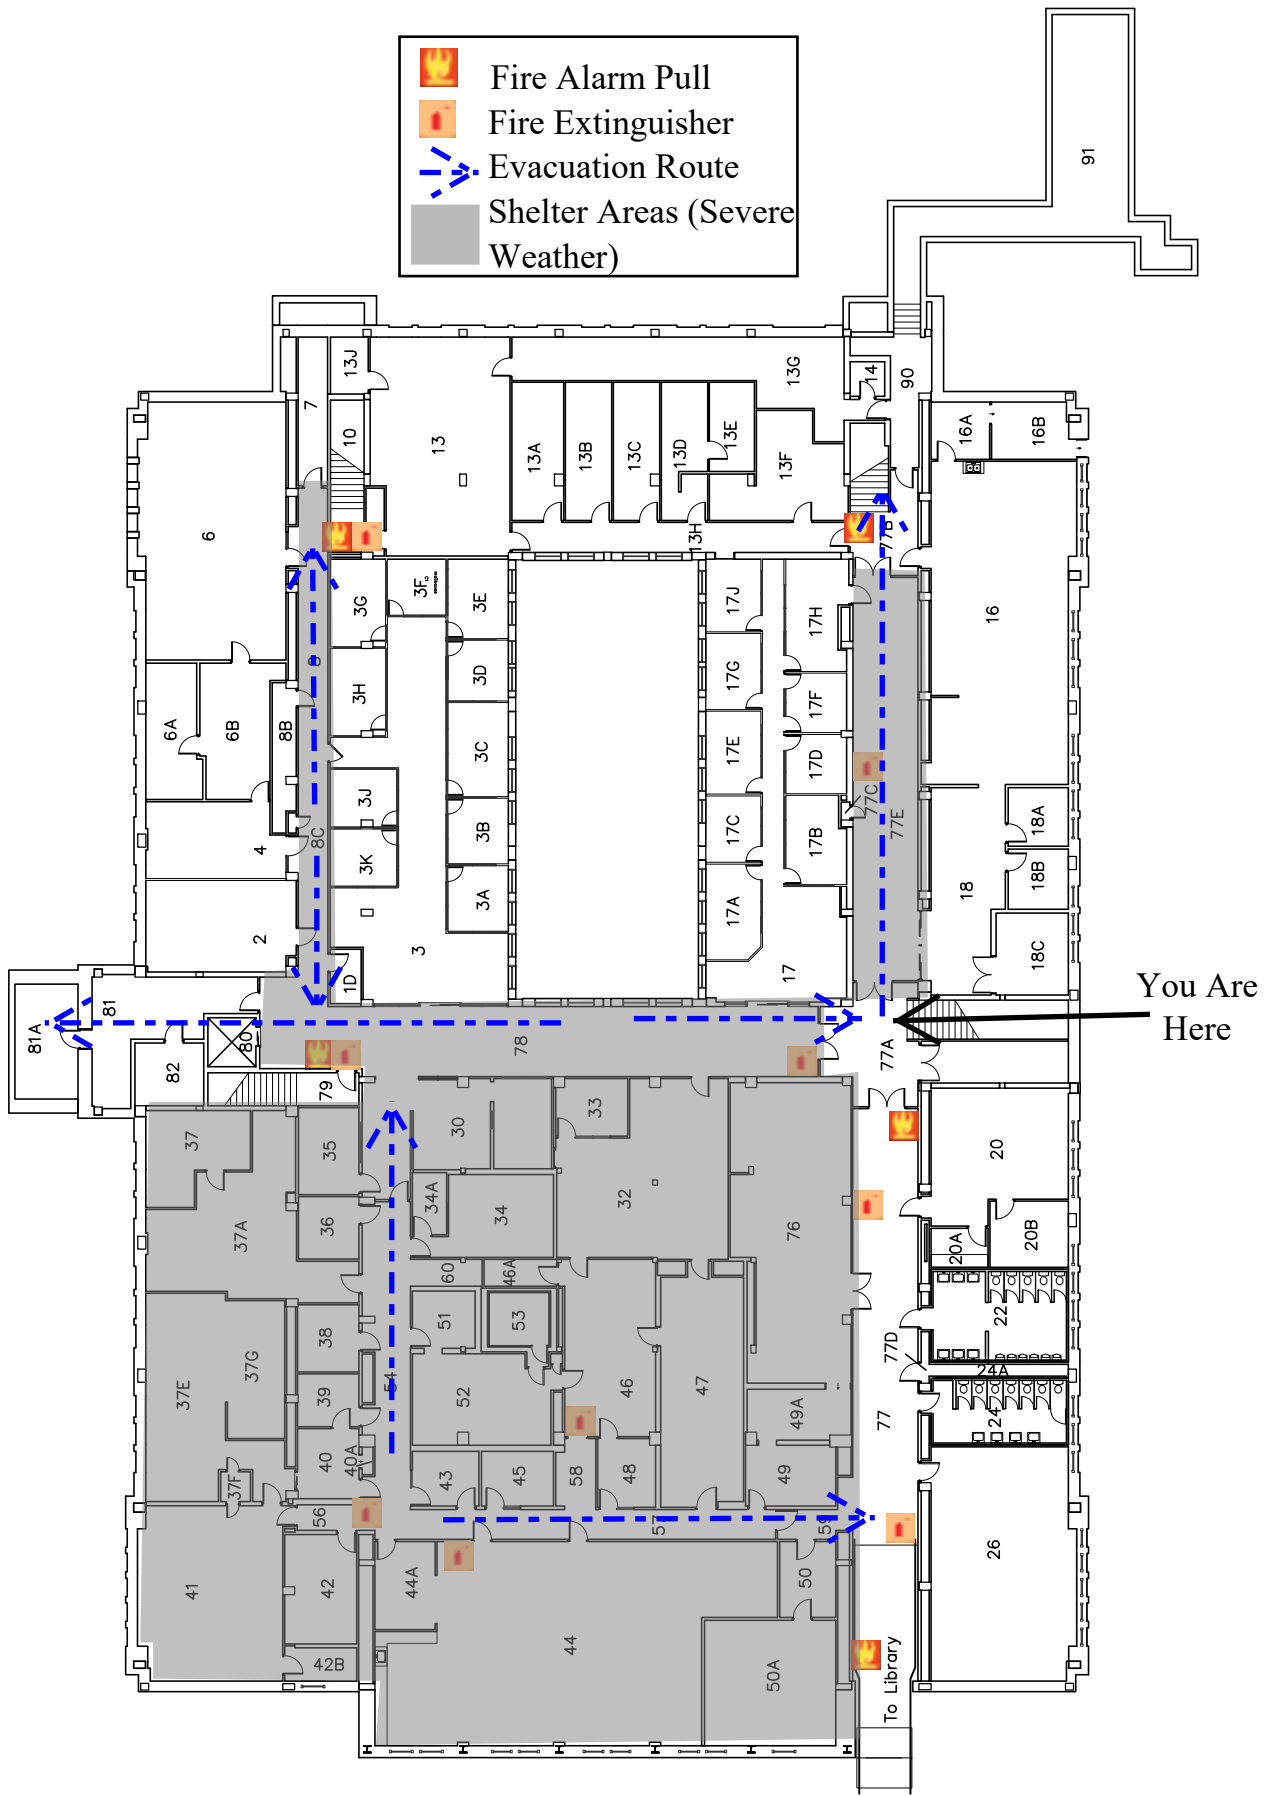

You Are Here








University of Wisconsin-Eau Claire Facilities Planning

Schofield Hall Basement Floor Plan

DATE:
Dec. 2021
DWG NO:
3



-  Fire Alarm Pull
-  Fire Extinguisher
-  Evacuation Route
-  Shelter Areas (Severe Weather)

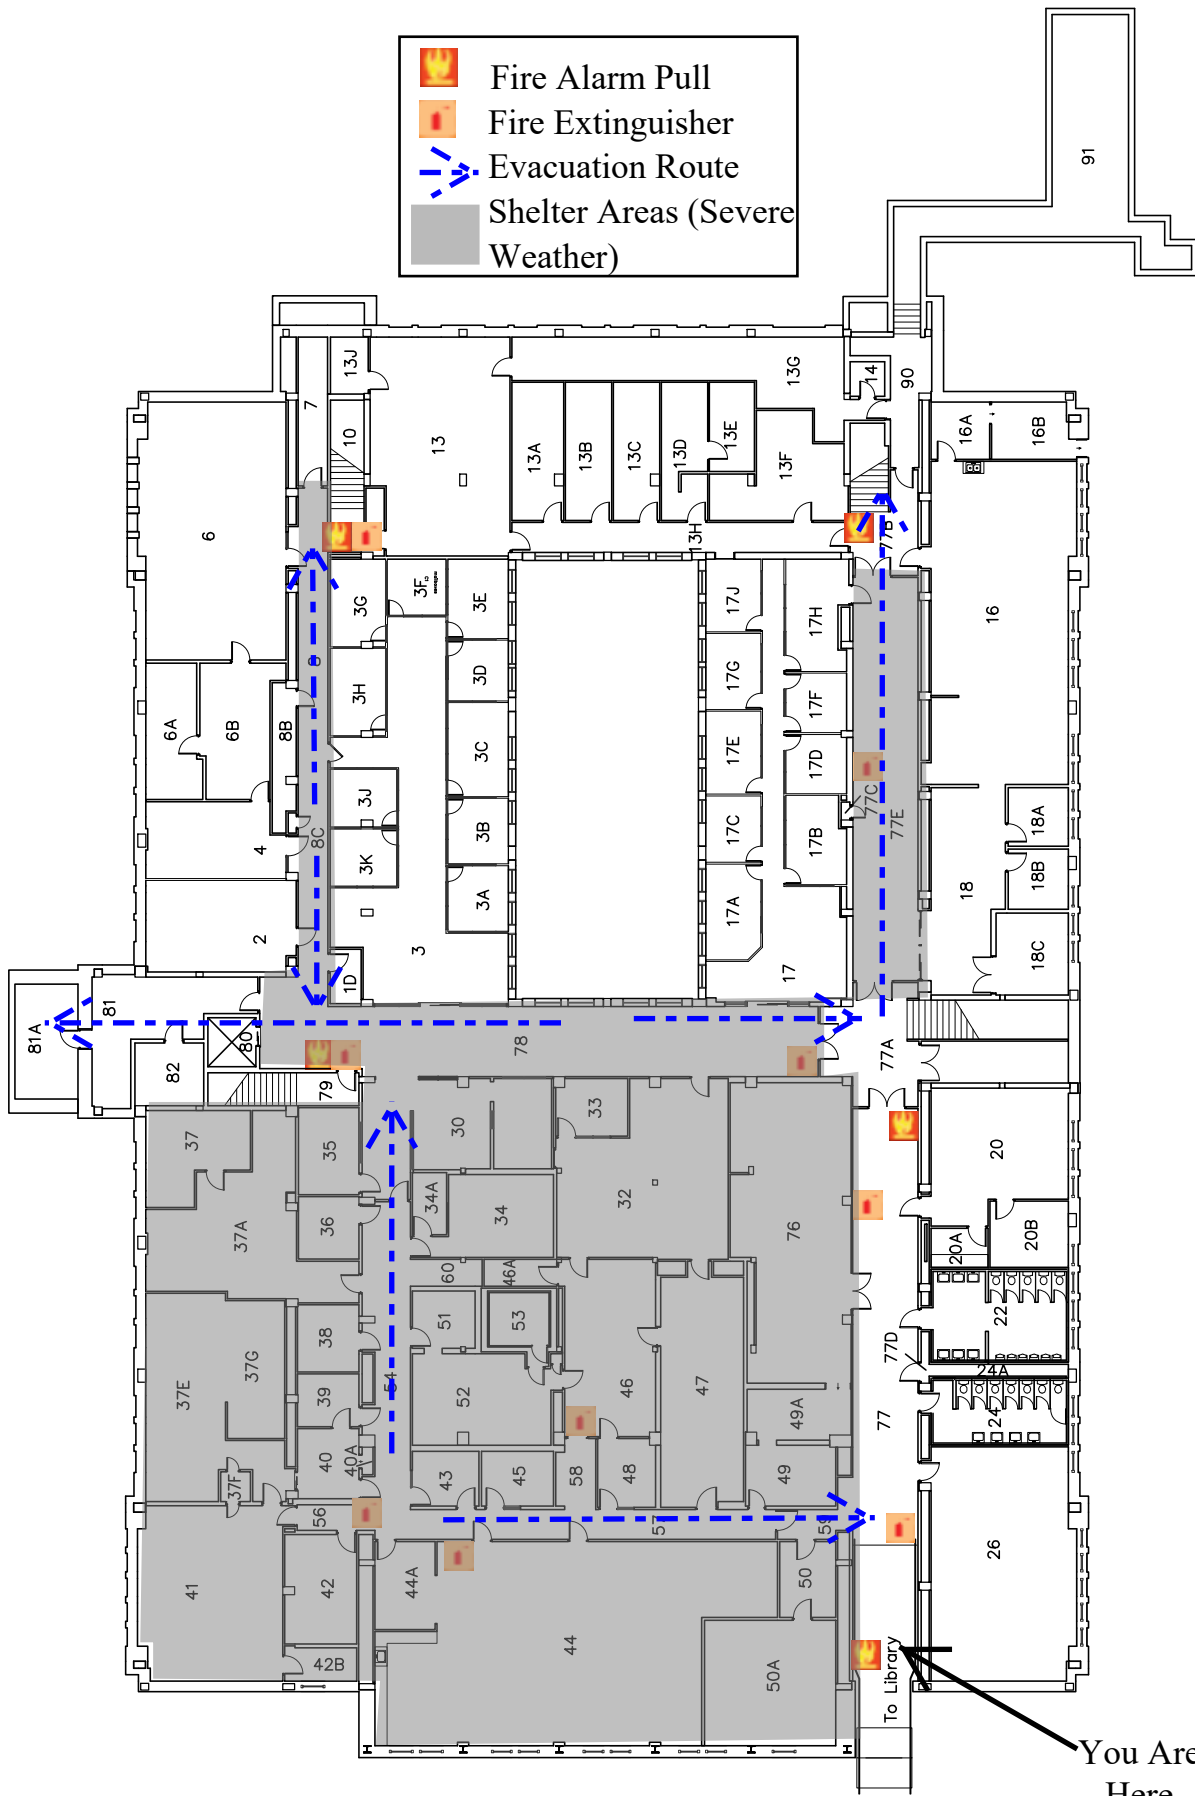






University of Wisconsin-Eau Claire Facilities Planning

Schofield Hall Basement Floor Plan

DATE:
Dec. 2021
DWG NO:
4



	Fire Alarm Pull
	Fire Extinguisher
	Evacuation Route
	Shelter Areas (Severe Weather)

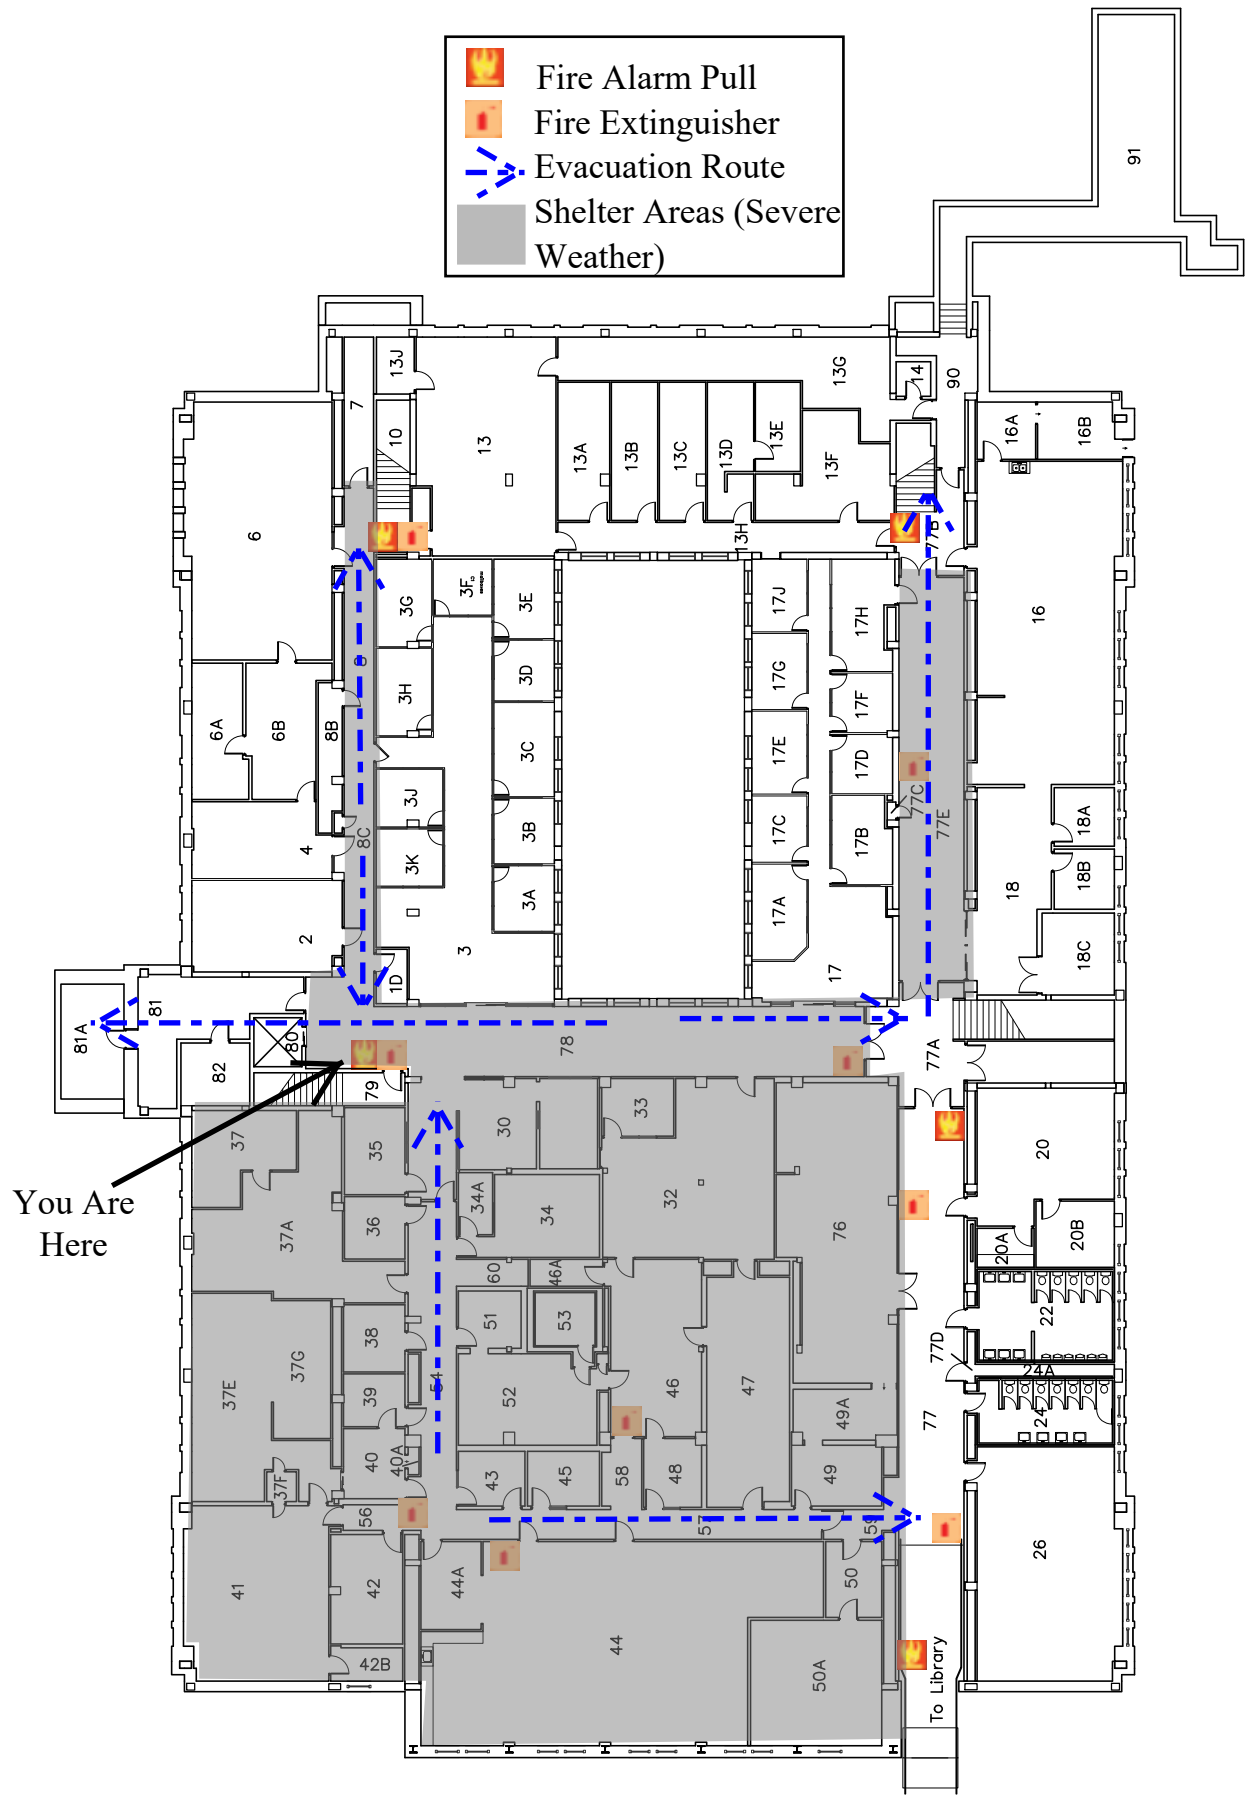





University of Wisconsin-Eau Claire Facilities Planning

Schofield Hall Basement Floor Plan

DATE:
Dec. 2021

DWG NO:
5




-  Fire Alarm Pull
-  Fire Extinguisher
-  AED
-  Evacuation Route

You Are Here



Assembly Point-
Outdoor
Theater near
Walking Bridge

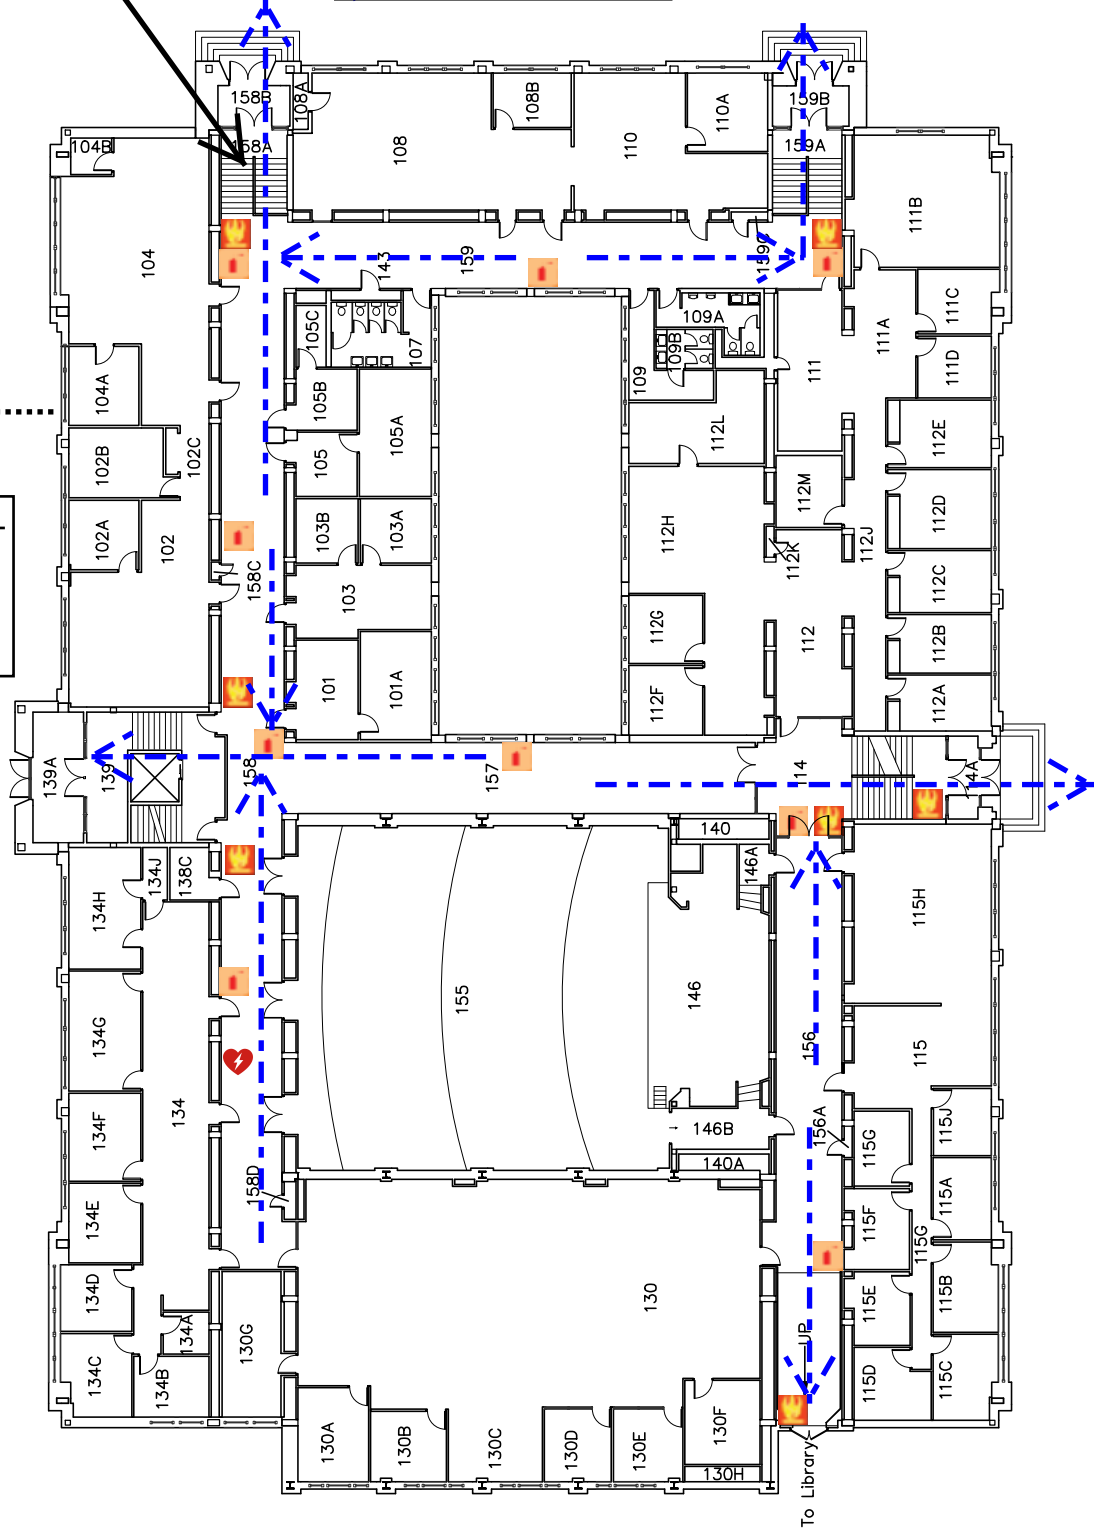





University of Wisconsin-Eau Claire Facilities Planning

Schofield Hall First Floor Plan

DATE:
Dec. 2021

DWG NO:
1




-  Fire Alarm Pull
-  Fire Extinguisher
-  AED
-  Evacuation Route

You Are Here



Assembly Point-
Outdoor
Theater near
Walking Bridge

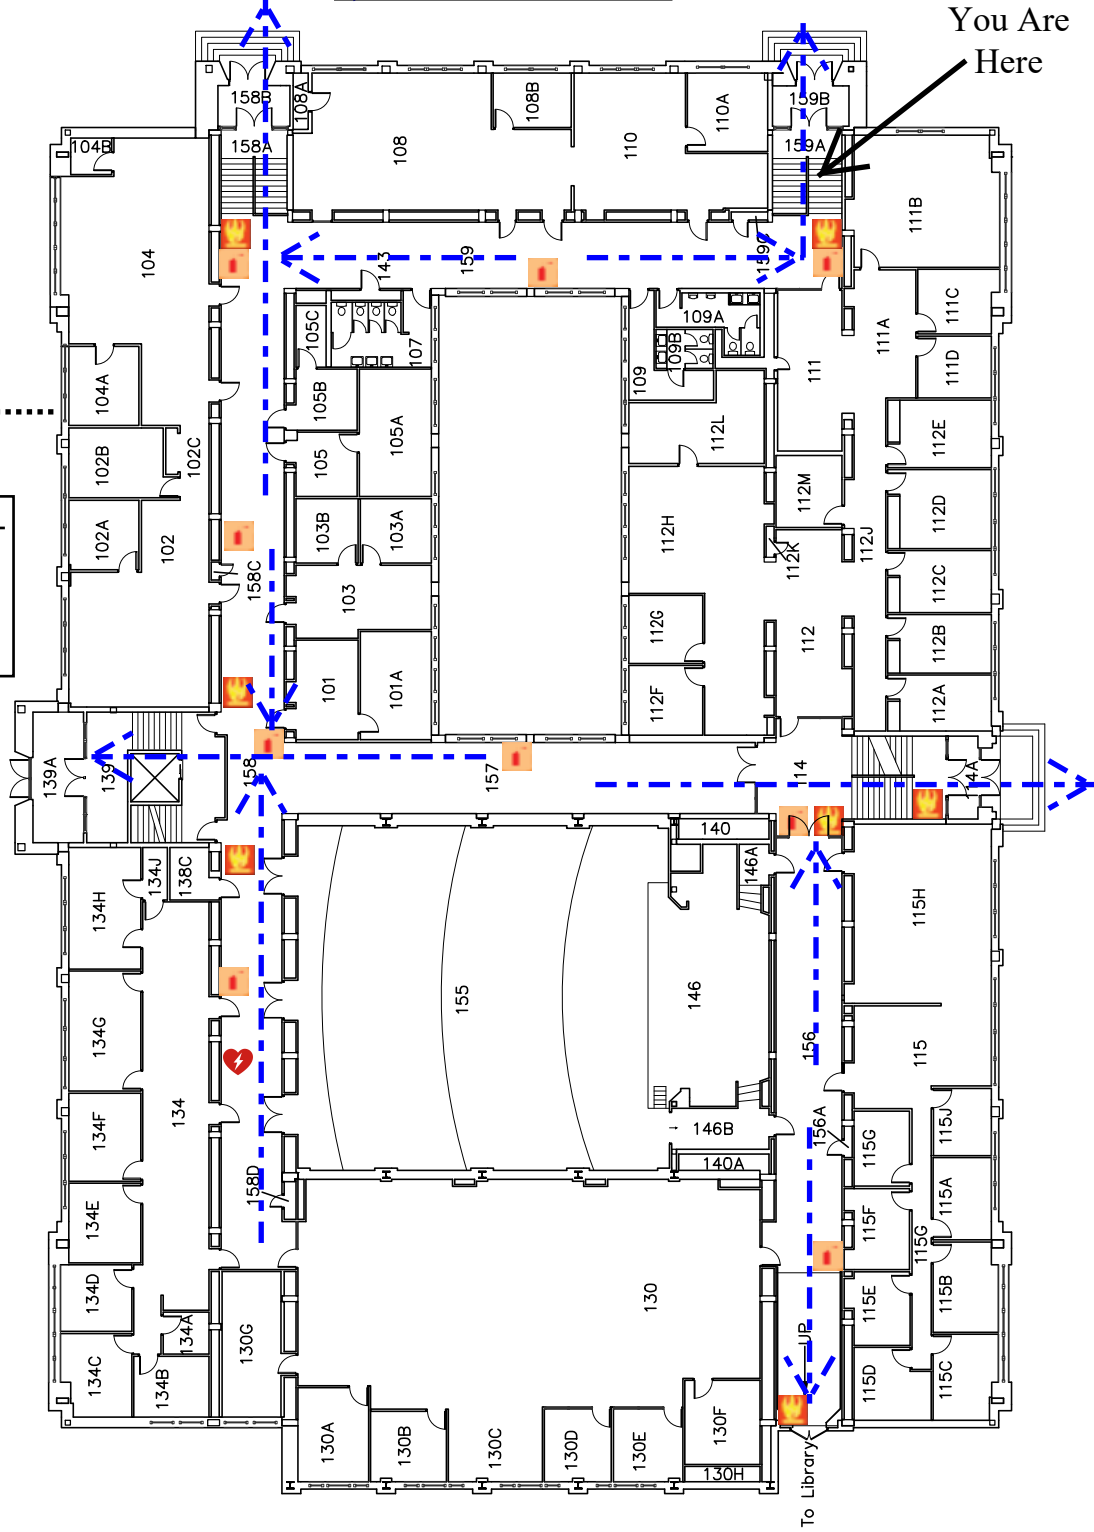





University of Wisconsin-Eau Claire Facilities Planning

Schofield Hall First Floor Plan

DATE:
Dec. 2021


DWG NO:
2



-  Fire Alarm Pull
-  Fire Extinguisher
-  AED
-  Evacuation Route



Assembly Point-
Outdoor
Theater near
Walking Bridge

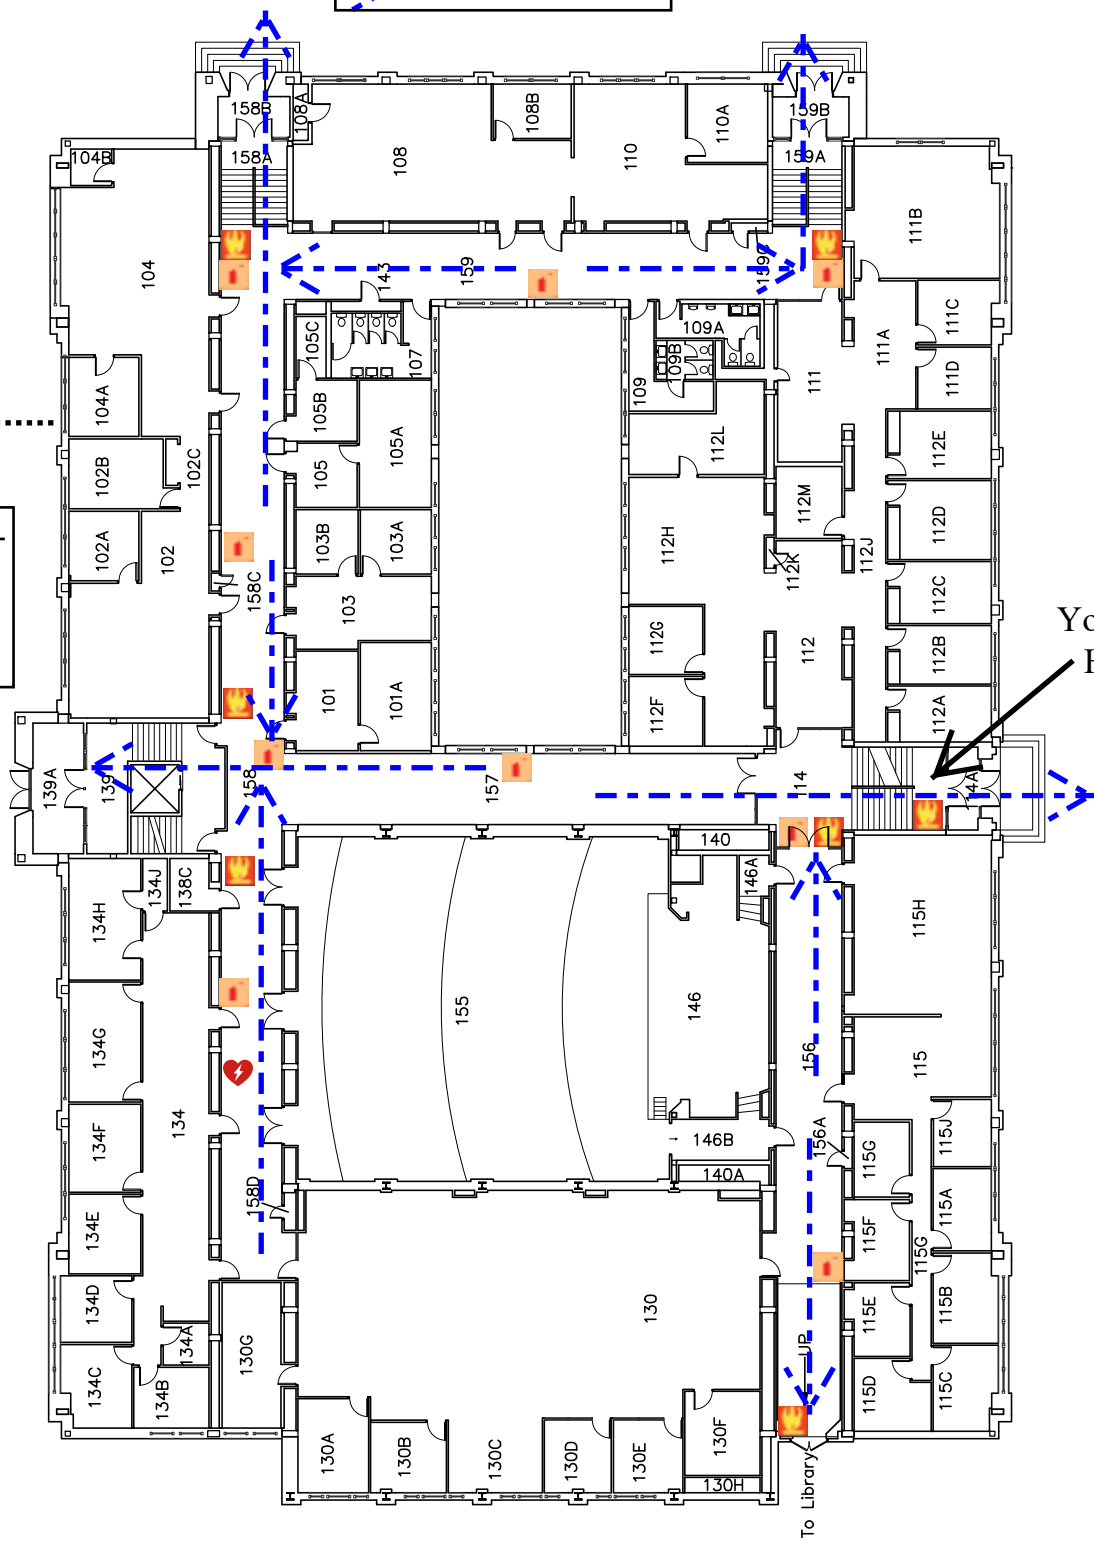

You Are Here





To Library



University of Wisconsin-Eau Claire Facilities Planning
**Schofield Hall
First Floor Plan**


DATE:
Dec. 2021
DWG NO:
3



-  Fire Alarm Pull
-  Fire Extinguisher
-  AED
-  Evacuation Route



Assembly Point-
Outdoor
Theater near
Walking Bridge

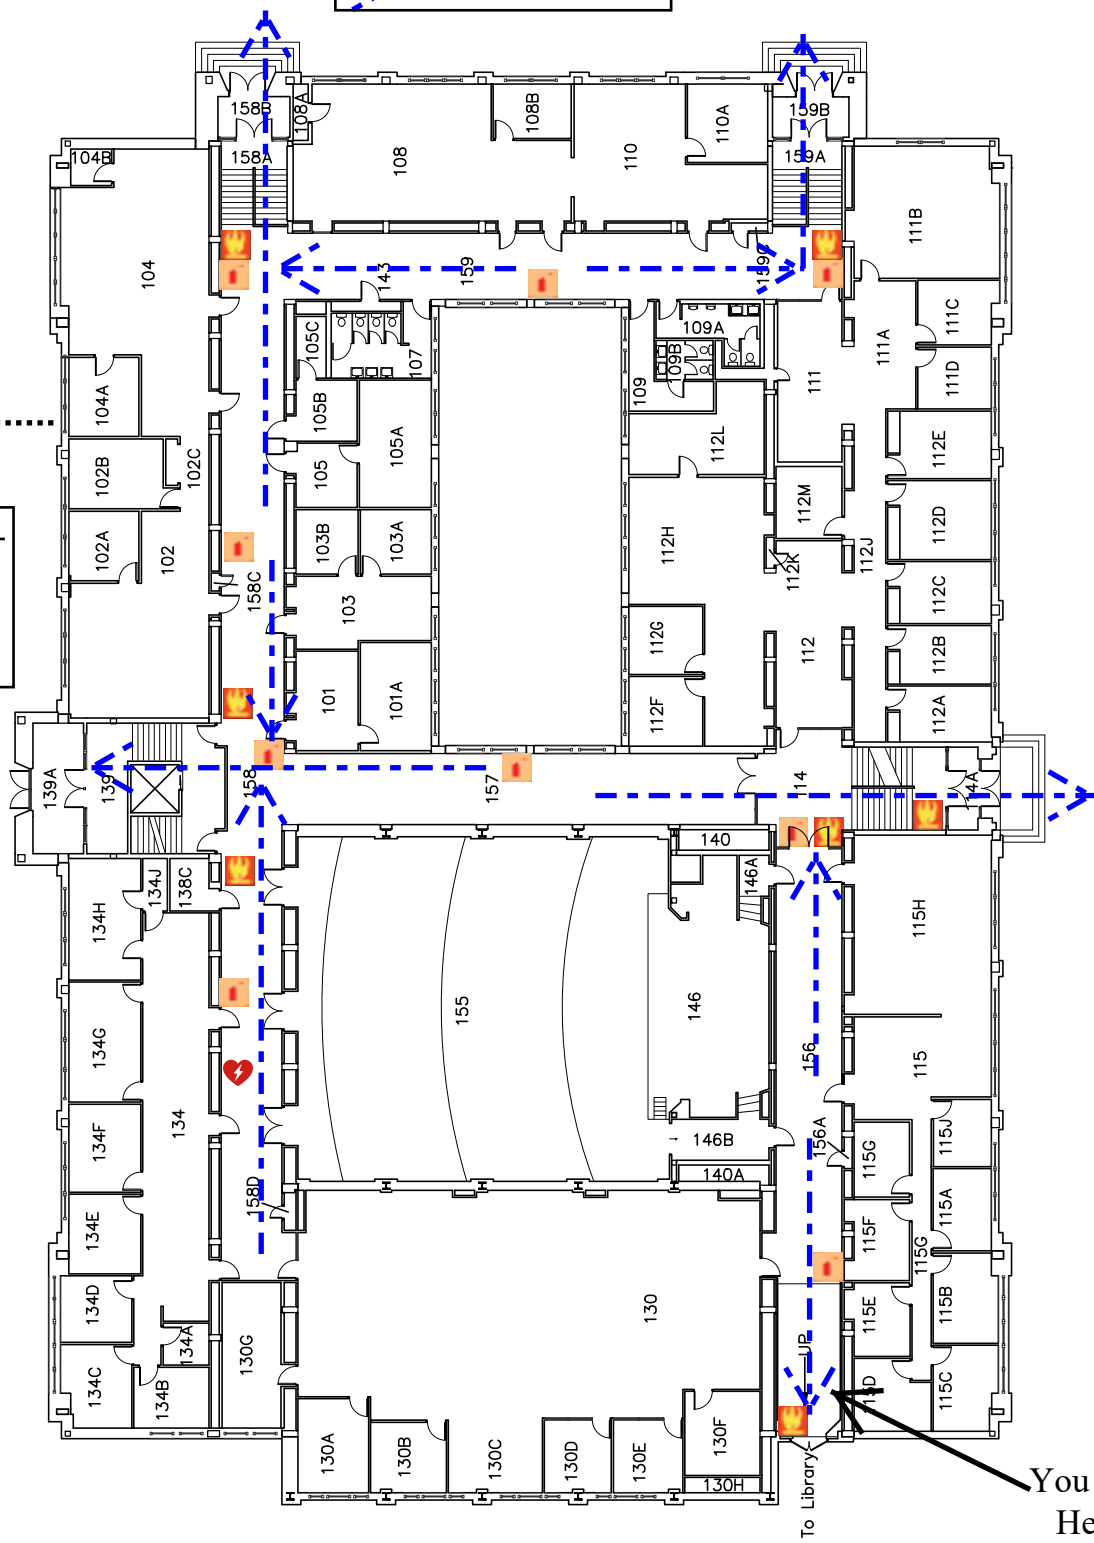





University of Wisconsin-Eau Claire Facilities Planning

Schofield Hall First Floor Plan

DATE:
Dec. 2021

DWG NO:
4




-  Fire Alarm Pull
-  Fire Extinguisher
-  AED
-  Evacuation Route



Assembly Point-
Outdoor
Theater near
Walking Bridge

You Are
Here

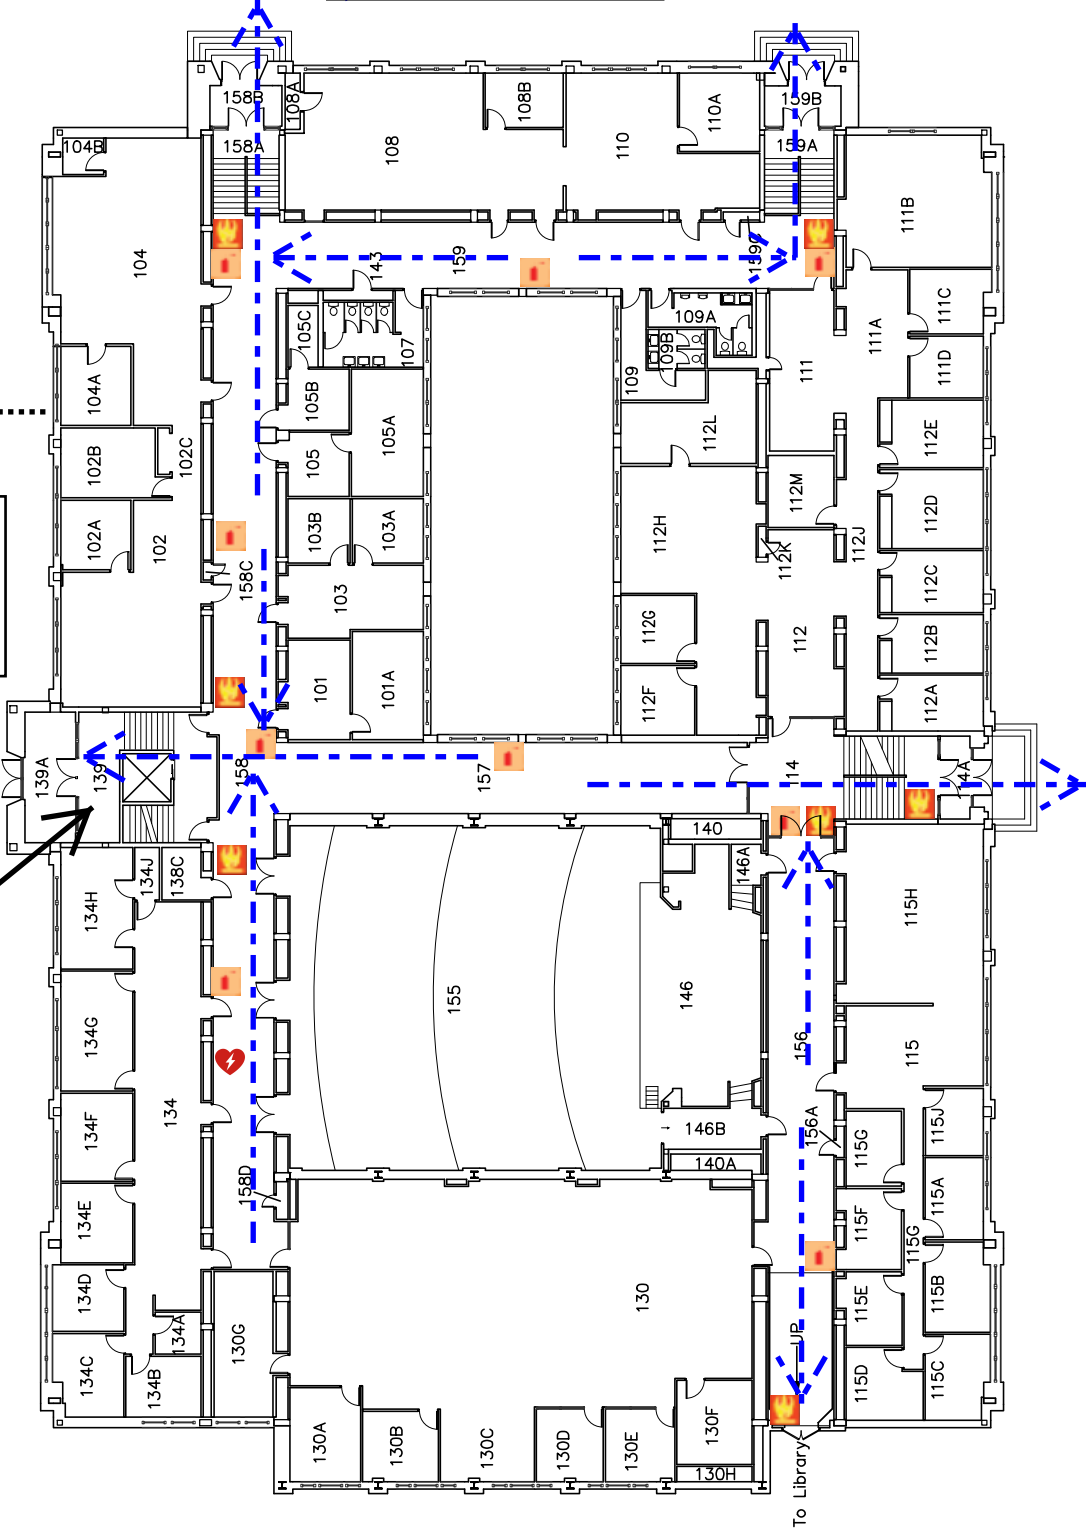





University of Wisconsin-Eau Claire Facilities Planning

Schofield Hall First Floor Plan

DATE:
Dec. 2021

DWG NO:
5




-  Fire Alarm Pull
-  Fire Extinguisher
-  AED
-  Evacuation Route



Assembly Point-
Outdoor
Theater near
Walking Bridge

You Are
Here

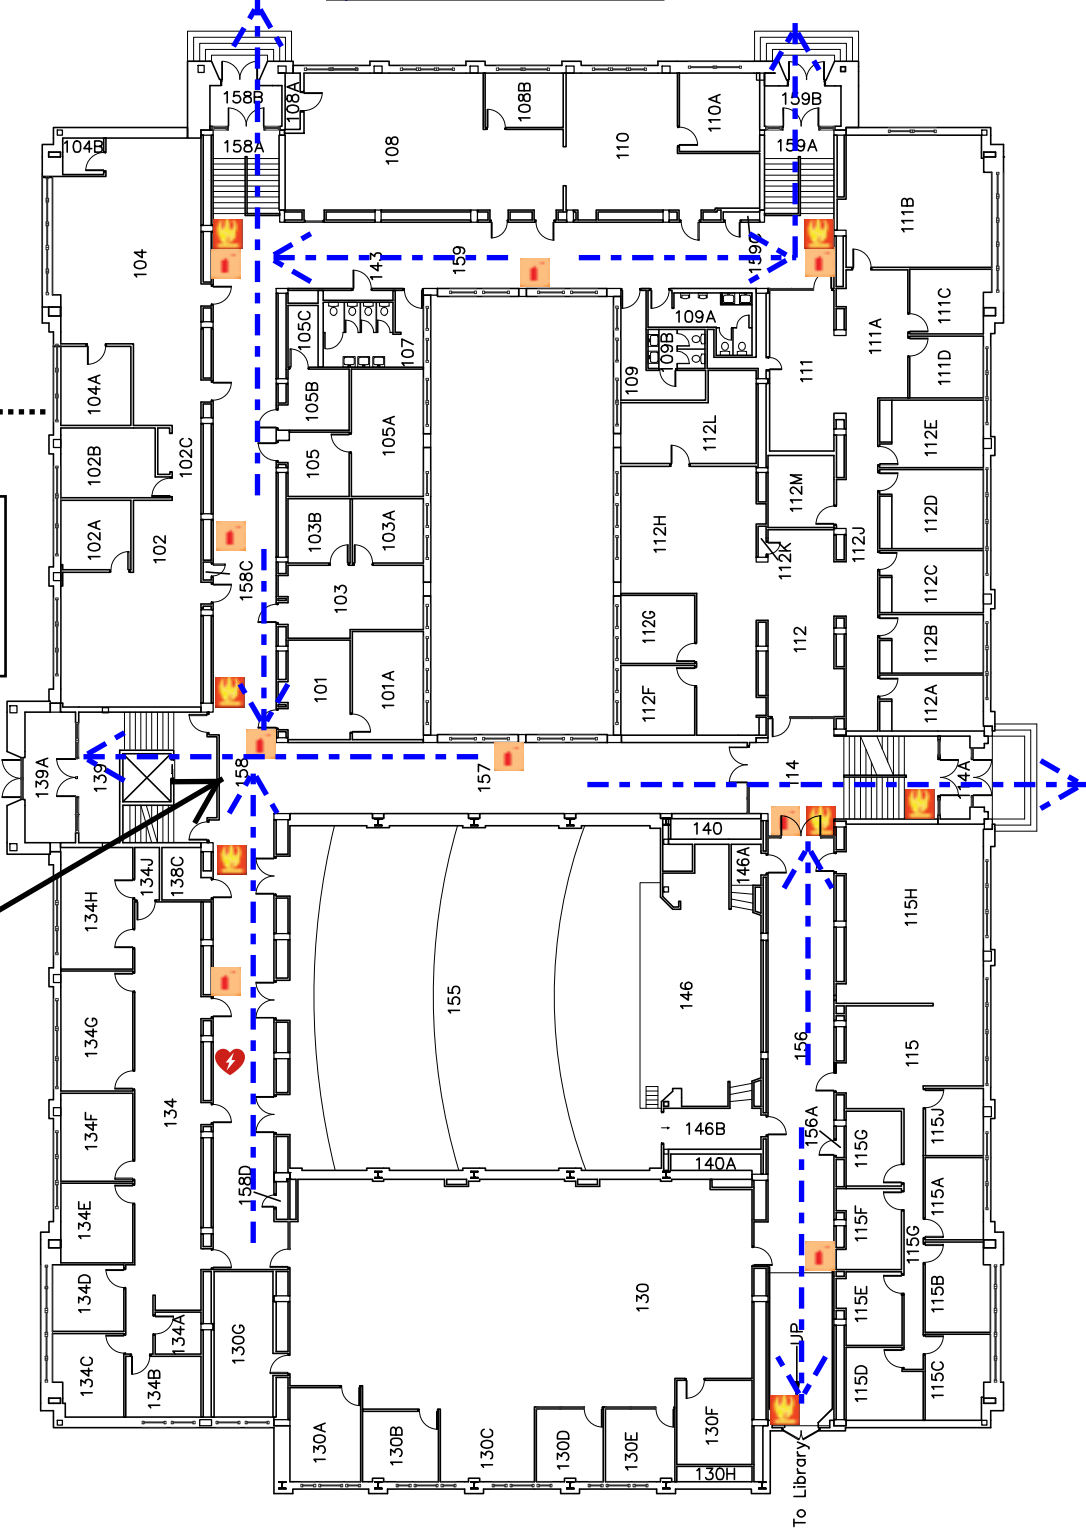




University of Wisconsin-Eau Claire Facilities Planning


Schofield Hall First Floor Plan

DATE:
Dec. 2021

DWG NO:
6



	Fire Alarm Pull
	Fire Extinguisher
	Evacuation Route

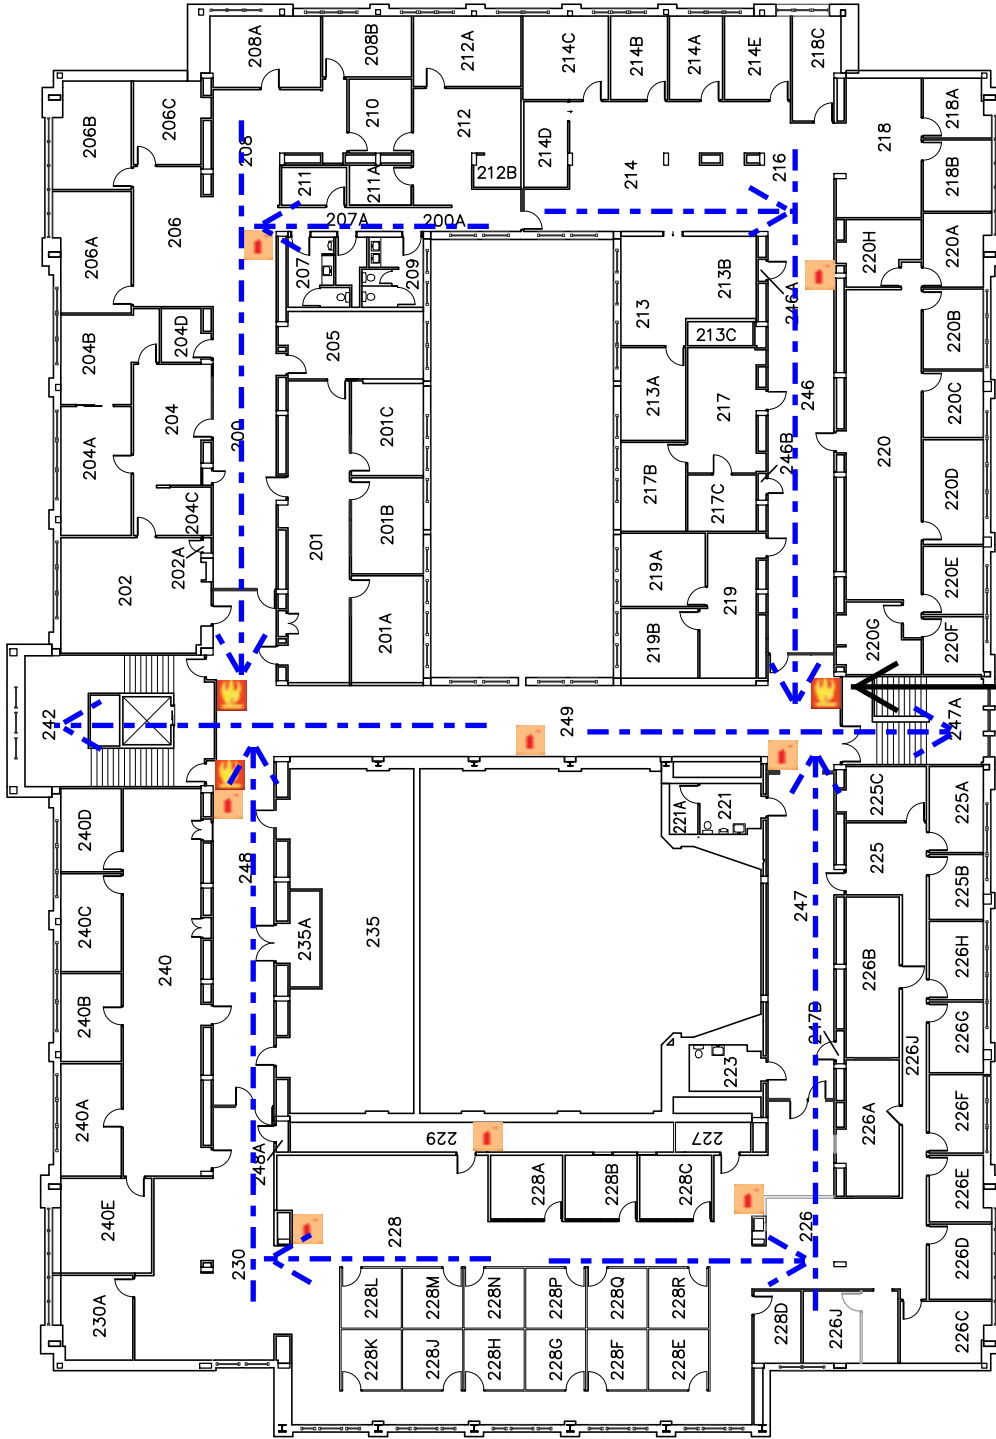

You Are Here






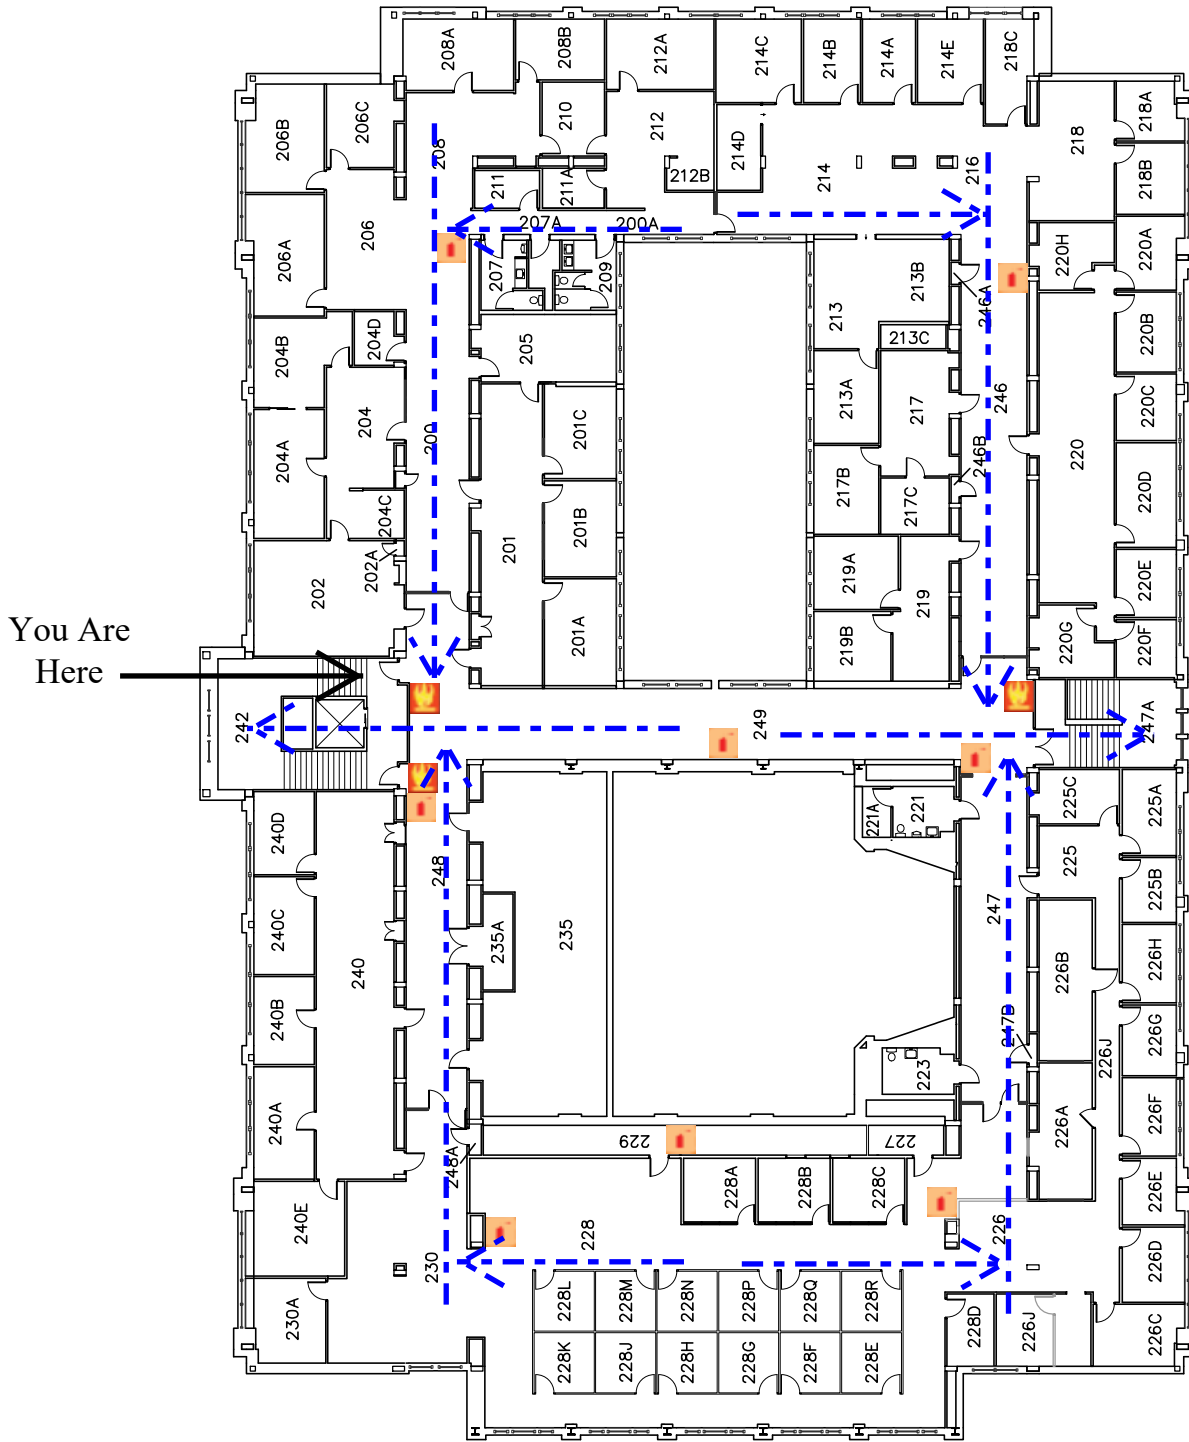
University of Wisconsin-Eau Claire Facilities Planning

Schofield Hall Second Floor Plan

DATE: Dec 2021
DWG NO: 1



	Fire Alarm Pull
	Fire Extinguisher
	Evacuation Route



University of Wisconsin-Eau Claire Facilities Planning

Schofield Hall Second Floor Plan

DATE:

Dec 2021

DWG NO:

2



East